


ISSUE FOR:

DRC SUBMITTAL

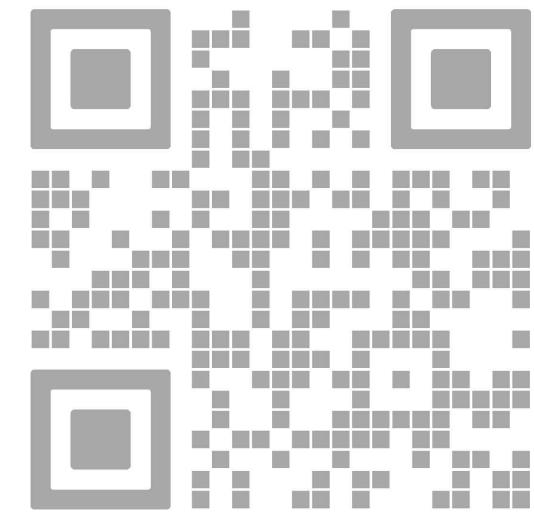

REV.	DATE	DESCRIPTION
01	05-16-2025	DRC SUBMITTAL

PZ24-12000027
04/15/2026

ALL MEASUREMENTS MUST BE VERIFIED BEFORE
BEGINNING THE WORKS. NO MEASUREMENTS ARE TO
BE SCALED DIRECTLY FROM THIS DRAWING.

Key section

Client

VERA FUND
NICK POLYUSHKIN
& YURI KHARITONENKOV
TEL: 305.833.3303

Project


1600 S FEDERAL HIGHWAY
(MIXED-USE PROJECT)

1600 SOUTH FEDERAL HIGHWAY,
POMPANO BEACH, FL 33062

Title	
LEVEL 03 PHOTOMETRICS	
Drawn J. WU	Field ARCHITECTURE
Verified N. TREMBLAY	Scale as shown
Approved S. L'ECUYER	Date 03-11-2026
Project Manager J. WU	Dwg. no. P-003
Project 24-838	

Calculation Summary						
Zone	CalcType	Units	Avg	Max	Min	Avg/Min
Parking Garage Floor	Illuminance	FC	5.39	12.8	1.1	6.89


Luminaire Schedule						
Symbol	Qty	Label	Arrangement	Description	ELF	Luminaire Summa
○	10	○2	Single	810 Lighting PG 18100 G3 FSR (32W)	0.853	4480
○	21	○2E	Single	810 Lighting PG 18100 G3 FSR (32W) (Connected to Generator)	0.900	4480

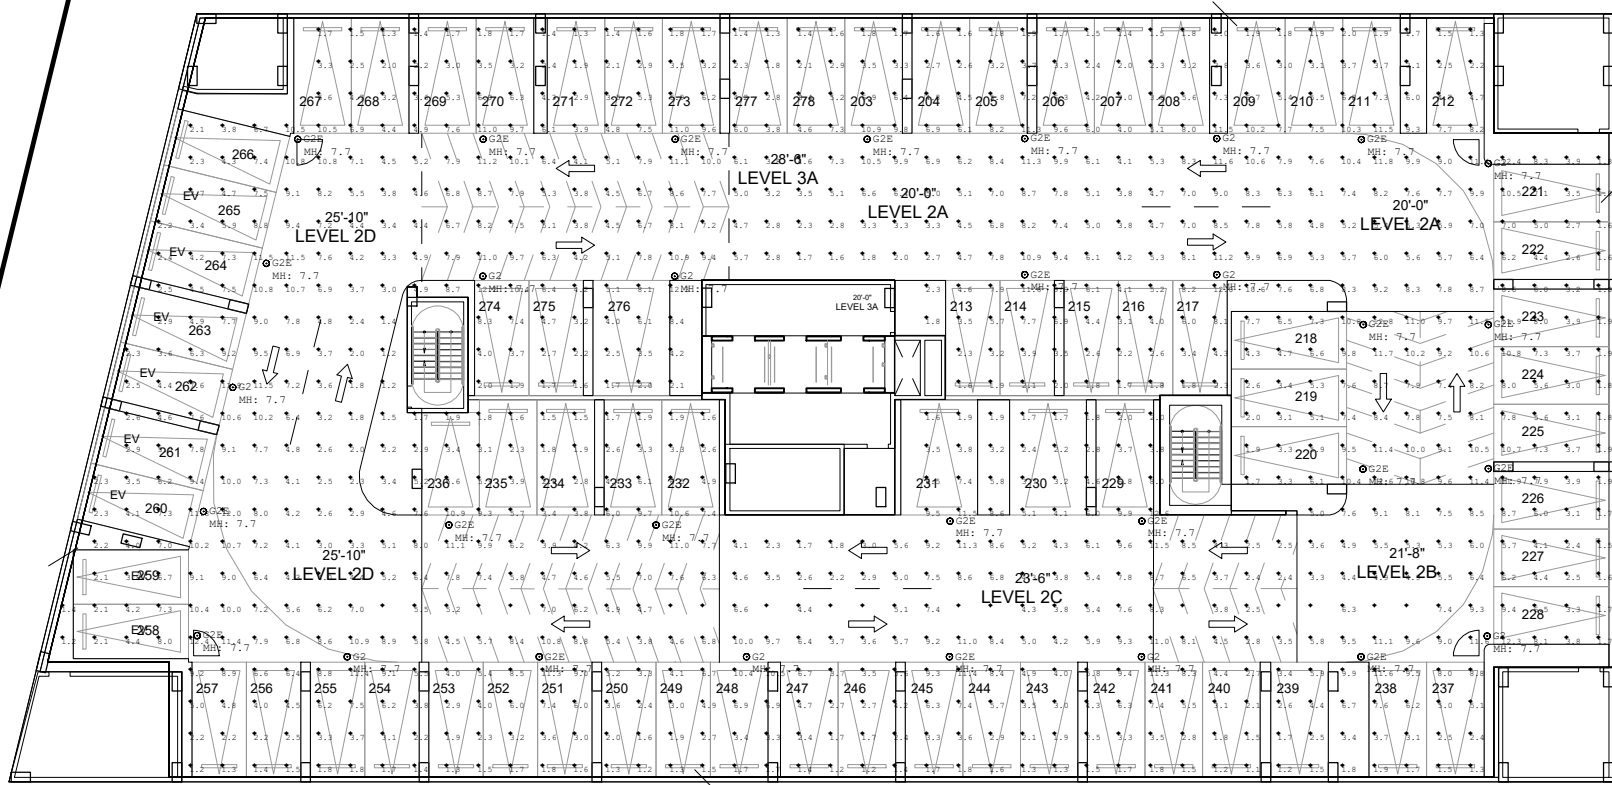

LEVEL 03
PHOTOMETRICS - NORMAL
SCALE: 1"= 30'-0"

Calculation Summary						
Zone	CalcType	Units	Avg	Max	Min	Avg/Min
Parking Garage Floor	Illuminance	FC	5.65	12.4	0.4	5.25

Luminaire Schedule						
Symbol	Qty	Label	Arrangement	Description	ELF	Luminaire Summa
○	10	○2	Single	810 Lighting PG 18100 G3 FSR (32W)	0.853	4480
○	21	○2E	Single	810 Lighting PG 18100 G3 FSR (32W) (Connected to Generator)	0.900	4480

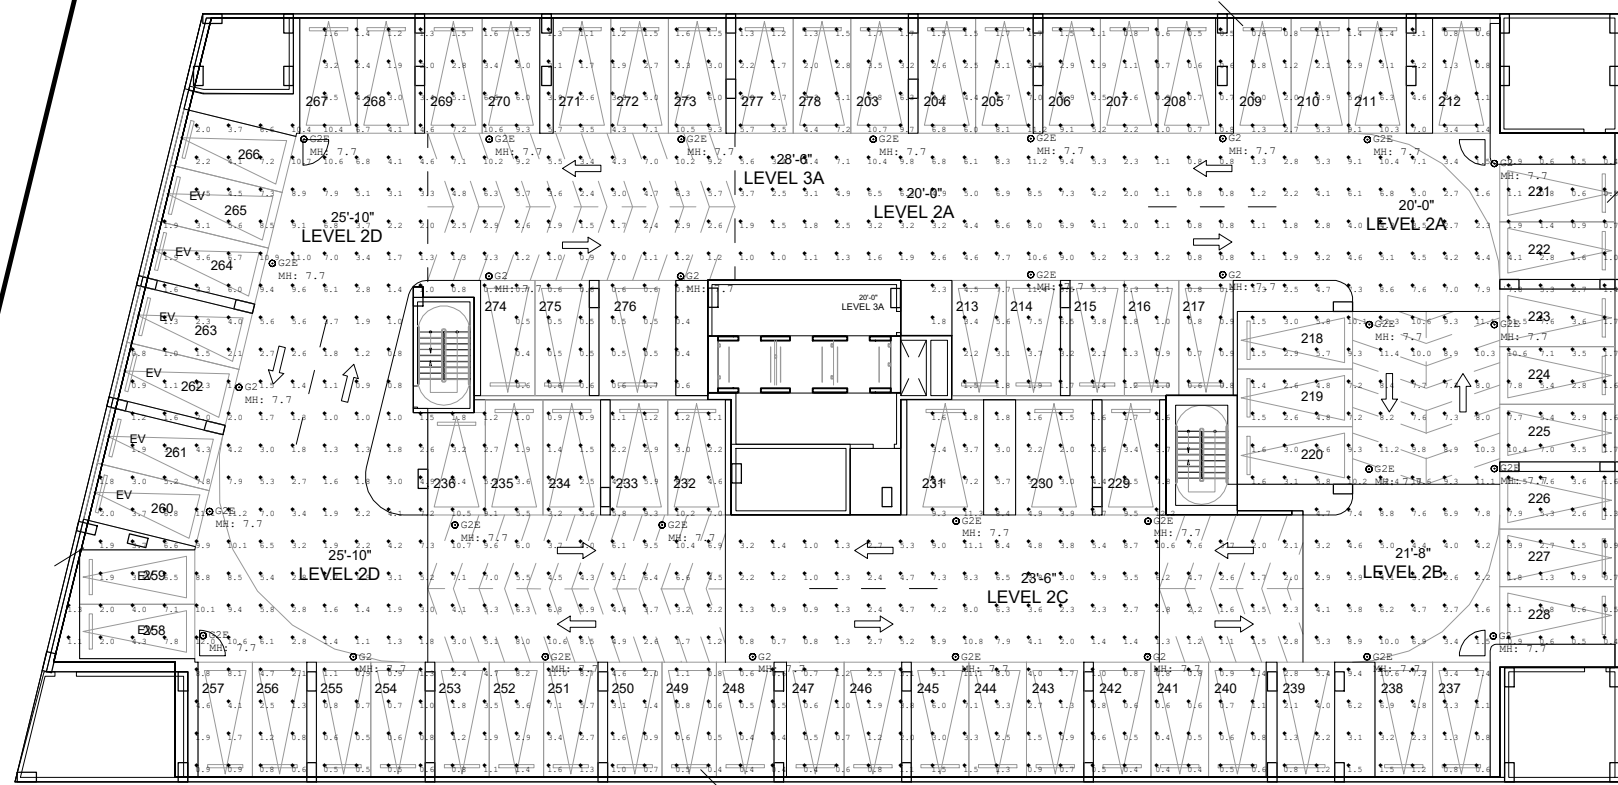

LEVEL 03
PHOTOMETRICS - EMERGENCY
SCALE: 1"= 30'-0"