


DESIGNED  
JY  
DRAWN  
JJ  
CHECKED  
JY

REVISIONS


DATE: 01/12/24  
COMM: 22019

580 BRINY AVE.


580 BRINY AVE.  
POMPANO BEACH, FL

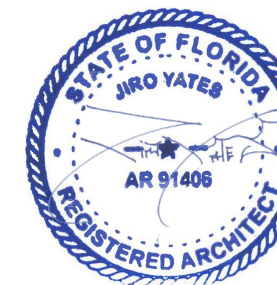

 Digitally signed  
by Jiro Yates  
Date:  
2024.04.09  
11:48:29-04'00'



DATE: 04.09.2024  
PROJECT: 224-12000003  
SHEET: A-501  
05/15/2024

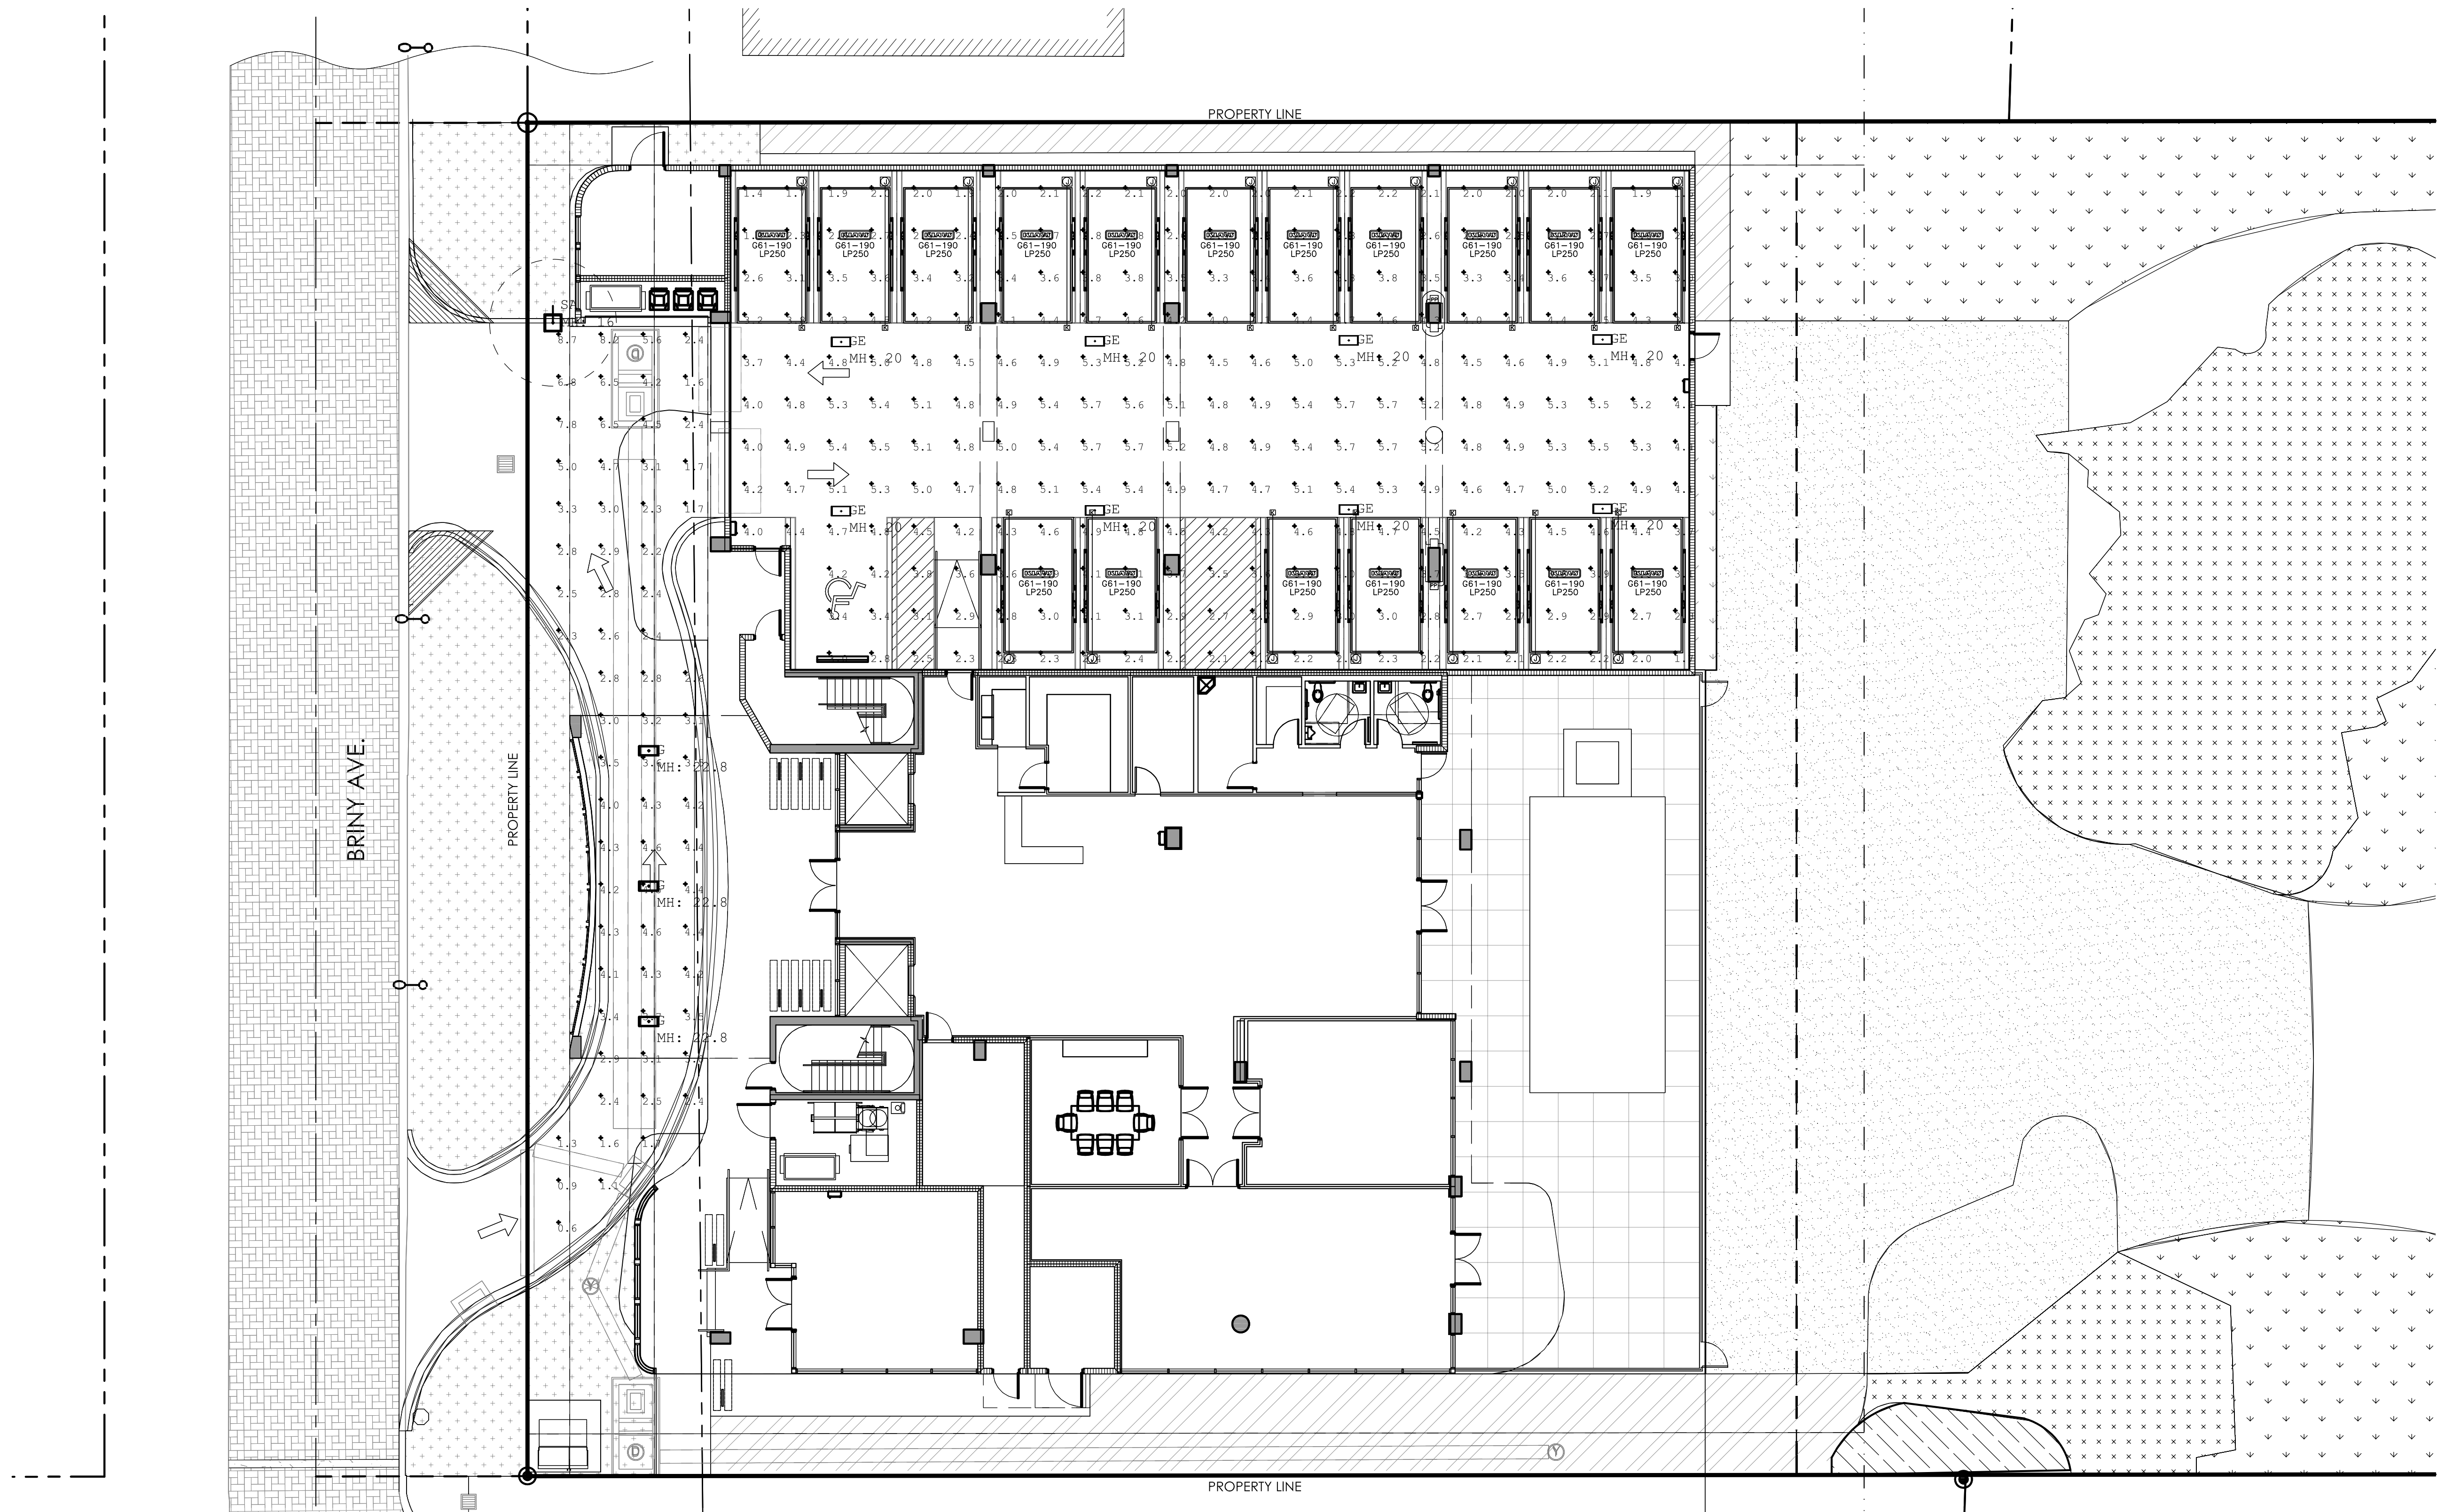

| Luminaire Schedule |     |       |             |  |       |                  |                 |             |
|--------------------|-----|-------|-------------|--|-------|------------------|-----------------|-------------|
| Symbol             | Qty | Label | Arrangement | Description                            | LLF   | Luminaire Lumens | Luminaire Watts | Total Watts |
|                    | 3   | G     | Single      | Xtra Light VTH2-52-AMB-DIM-FCP-STD     | 0.900 | 3634             | 51.2            | 153.6       |
|                    | 8   | GE    | Single      | Xtra Light VTH2-52-AMB-DIM-FCP-STD-EM  | 0.900 | 3634             | 51.2            | 409.6       |
|                    | 1   | SA    | Single      | Xtra Light VNTLEDL032353MNDIMA20XXBZWS | 0.900 | 7346             | 235             | 235         |

| Calculation Summary  |             |       |      |     |     |         |         |  |
|----------------------|-------------|-------|------|-----|-----|---------|---------|--|
| Label                | CalcType    | Units | Avg  | Max | Min | Avg/Min | Max/Min |  |
| Drive Lane           | Illuminance | Fc    | 3.53 | 8.7 | 0.6 | 5.88    | 14.50   |  |
| Parking Garage Floor | Illuminance | Fc    | 3.82 | 5.7 | 1.4 | 2.73    | 4.07    |  |

| TYPE | MANUFACTURER | CATALOG NUMBER               | DESCRIPTION                      | LAMPS |              | VOLTS | MOUNTING | REMARKS | INPUT WATTS |
|------|--------------|------------------------------|----------------------------------|-------|--------------|-------|----------|---------|-------------|
|      |              |                              |                                  | Qty   | Type         |       |          |         |             |
| SA   | XTRALIGHT    | VNTLEDL032353MNDIMA20XXBXXWS | TURTLE AMBER LED SITE LUMINAIRE  | 1     | LED INCLUDED | XX    | POLE     |         | 235W        |
| GE   | XTRALIGHT    | VTH2-52-AMB-DIM-FCP-STD-EM   | TURTLE AMBER LED GARGE LUMINAIRE | 1     | LED INCLUDED | XX    | XX       |         | 52W         |

GROUND FLOOR PHOTOMETRIC PLAN

SCALE: 3/32" = 1'-0"