

| DESIGNED | DRAWN | CHECKED |
|----------|-------|---------|
| NH | NH | JY |

R E V I S I O N S

| DATE: | COMM: |
|-----------|-------|
| 9.27.2023 | 23008 |

POMPANO HOTEL


101 S. OCEAN BLVD
POMPANO BEACH, FL 33062

Digitally signed
by Joshua D
Bailey
Date:
2023.12.15
14:50:57-05'00'

PHOTOMETRIC THIRD FLOOR PLAN

DRC SET

AR-503

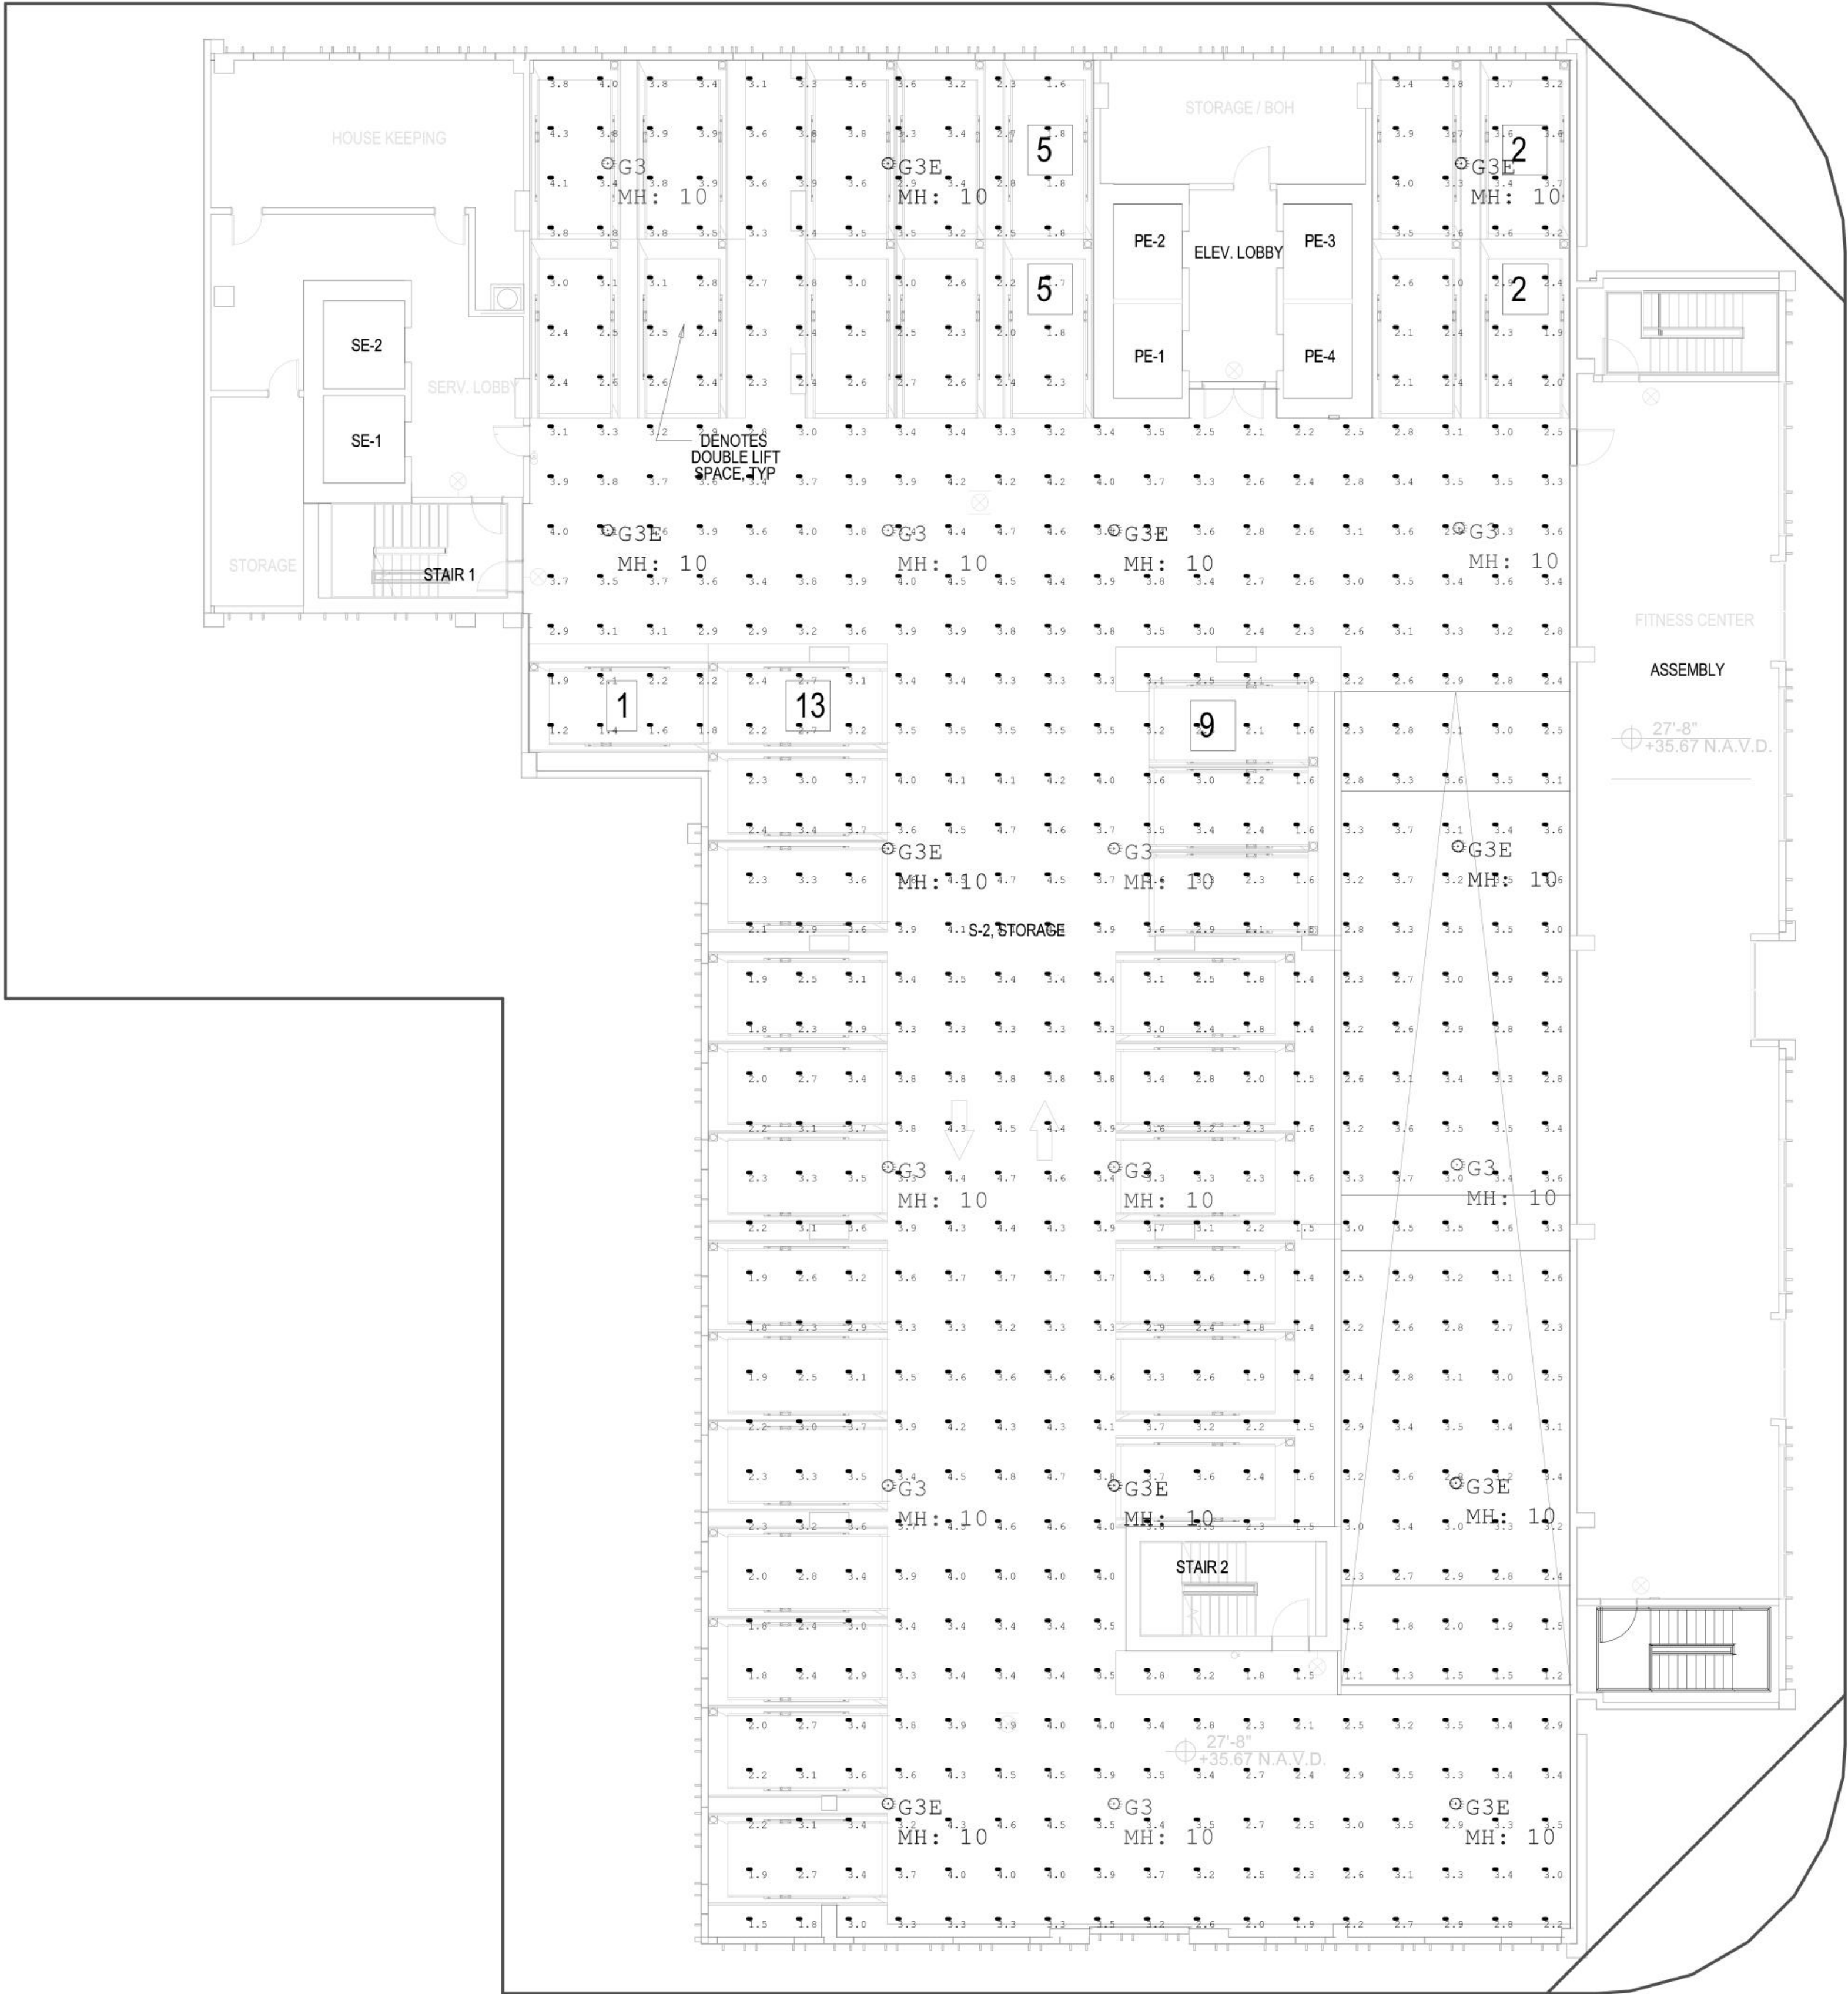

| Luminaire Schedule | | | | | | | | |
|--------------------|-----|-------|-------------|--|-------|------------------|-----------------|-------------|
| Symbol | Qty | Label | Arrangement | Description | LLF | Luminaire Lumens | Luminaire Watts | Total Watts |
| ⊙ | 10 | G3E | Single | LSI Industries EXN-D-EGLED-03L-T5W-UNV-DIM-40-80CRI-XX (Connected To Generator) | 0.900 | 3140 | 22 | 220 |
| ⊙ | 9 | G3 | Single | LSI Industries EXN-D-EGLED-03L-T5W-UNV-DIM-40-80CRI-XX | 0.900 | 3140 | 22 | 198 |

| Calculation Summary | | | | | | | | |
|----------------------|-------------|-------|------|-----|-----|---------|---------|--|
| Label | CalcType | Units | Avg | Max | Min | Avg/Min | Max/Min | |
| Parking Garage_Floor | Illuminance | Fc | 3.10 | 4.8 | 1.1 | 2.82 | 4.36 | |

DRC
PZ23-12000042
02/07/2024