


DESIGNED	DRAWN	CHECKED
NH	NH	JY

R E V I S I O N S

DATE:	COMM:
9.27.2023	23008

POMPAÑO HOTEL


101 S. OCEAN BLVD  
POMPAÑO BEACH, FL 33062

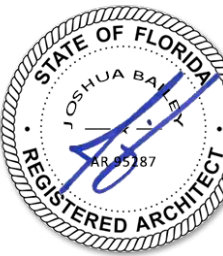

Digitally signed  
by Joshua D  
Bailey  
Date:  
2023.12.15  
14:50:48-05'00'

PHOTOMETRIC GROUND FLOOR  
PLAN  
DRC SET

AR-501

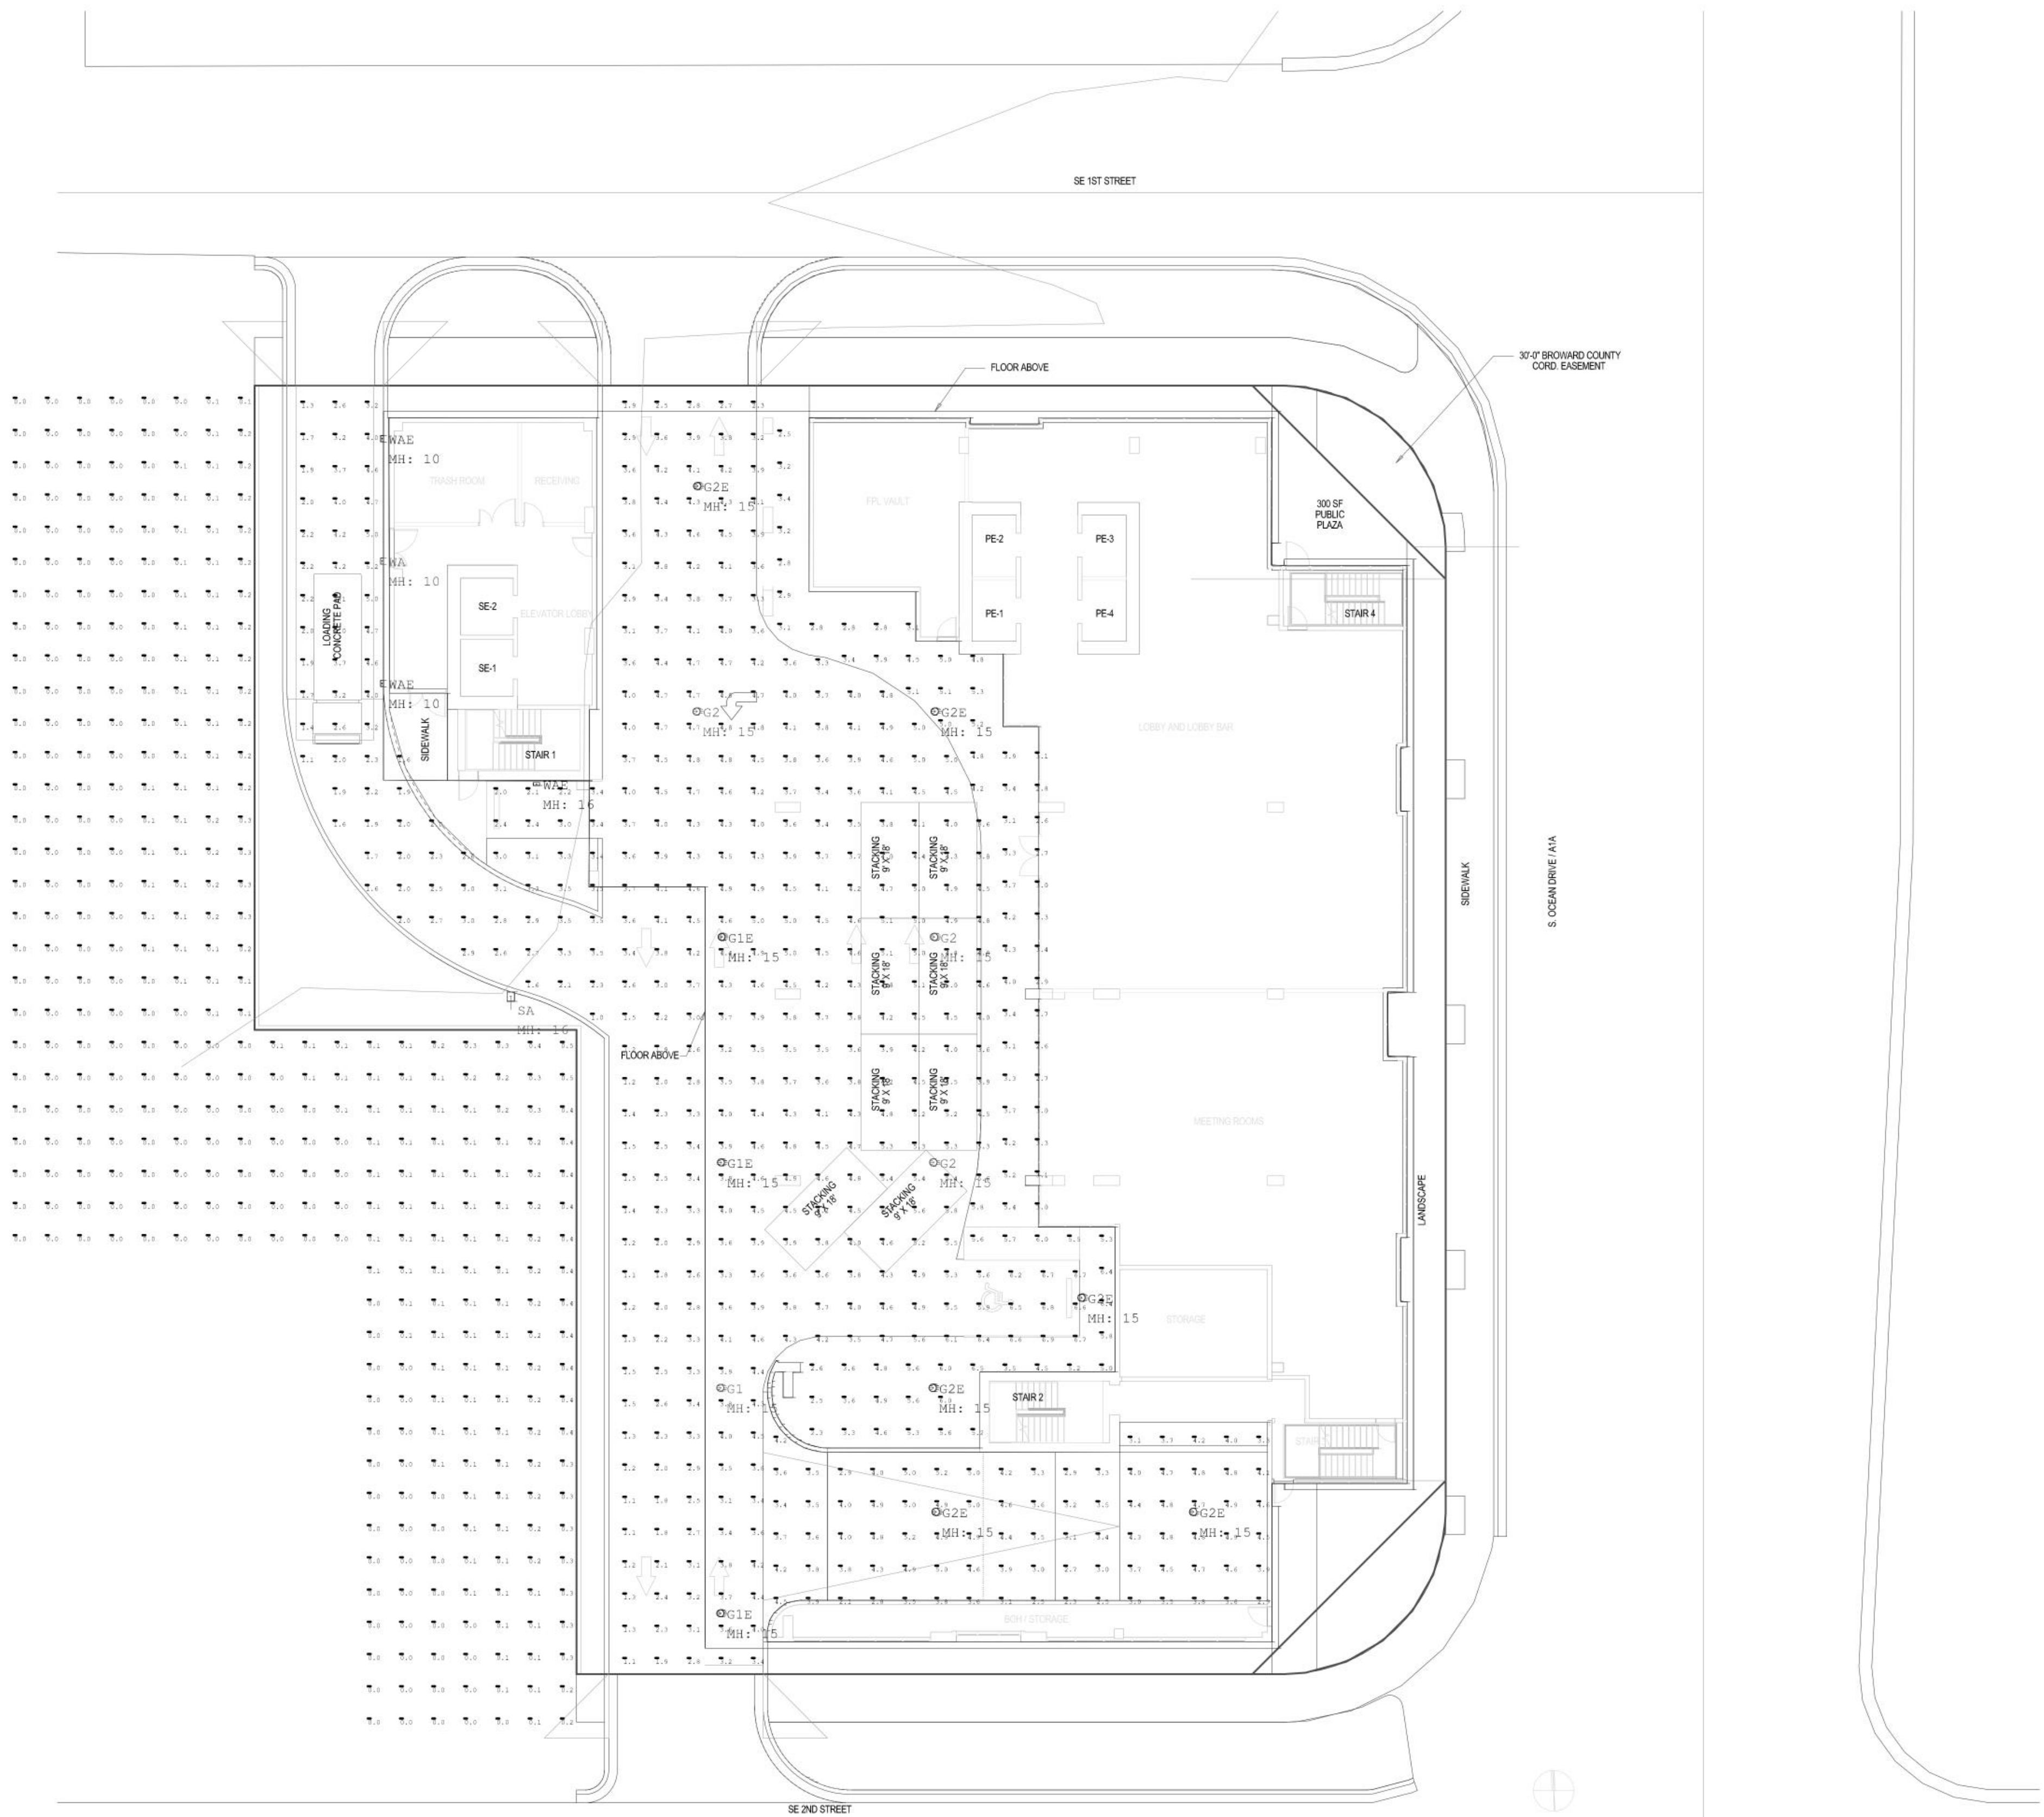

Luminaire Schedule									
Symbol	Qty	Label	Arrangement	Description	LLF	Luminaire Lumens	Luminaire Watts	Total Watts	
SA	1	SA	Single	LSI Industries MRS-LED-06L-SIL-4-UNV-DIM-40-70CRI-XX-IL	0.900	3800	39	39	
G1	1	G1	Single	LSI Industries EXN-D-EGL-06L-T5N-UNV-DIM-40-80CRI-XX-HSS	0.900	4444	44	44	
G1E	3	G1E	Single	LSI Industries EXN-D-EGL-06L-T5N-UNV-DIM-40-80CRI-XX-HSS (Connected to Generator)	0.900	4444	44	132	
G2	3	G2	Single	LSI Industries EXN-D-EGL-06L-T5N-UNV-DIM-40-80CRI-XX	0.900	6380	44	132	
G2E	6	G2E	Single	LSI Industries EXN-D-EGL-06L-T5N-UNV-DIM-40-80CRI-XX (Connected to Generator)	0.900	6380	44	264	
WA	1	WA	Single	LSI Industries XWS-LED-02L-SIL-2-UNV-DIM-40-70CRI-XX	0.900	1974	13	13	
WAE	3	WAE	Single	LSI Industries XWS-LED-02L-SIL-2-UNV-DIM-40-70CRI-XX (Connected to Generator)	0.900	1974	13	39	

Calculation Summary								
Label	CalcType	Units	Avg	Max	Min	Avg/Min	Max/Min	
Parking and Drive Lanes	Illuminance	Fc	3.69	6.9	1.0	3.69	6.90	
Ramp	Illuminance	Fc	3.97	5.2	2.1	1.89	2.48	
Sidewalk	Illuminance	Fc	4.10	6.5	2.3	1.78	2.83	
Spill	Illuminance	Fc	0.08	0.5	0.0	N.A.	N.A.	