

DESIGNED	DRAWN	CHECKED
NH	NH	JY

R E V I S I O N S

DATE:	COMM:
9.27.2023	23008


POMPANO HOTEL

101 S. OCEAN BLVD  
POMPANO BEACH, FL 33062

Digitally signed  
by Joshua D  
Bailey  
Date:  
2023.12.15  
14:51:01-05'00'

PHOTOMETRIC FOURTH FLOOR  
PLAN  
DRC SET

AR-504

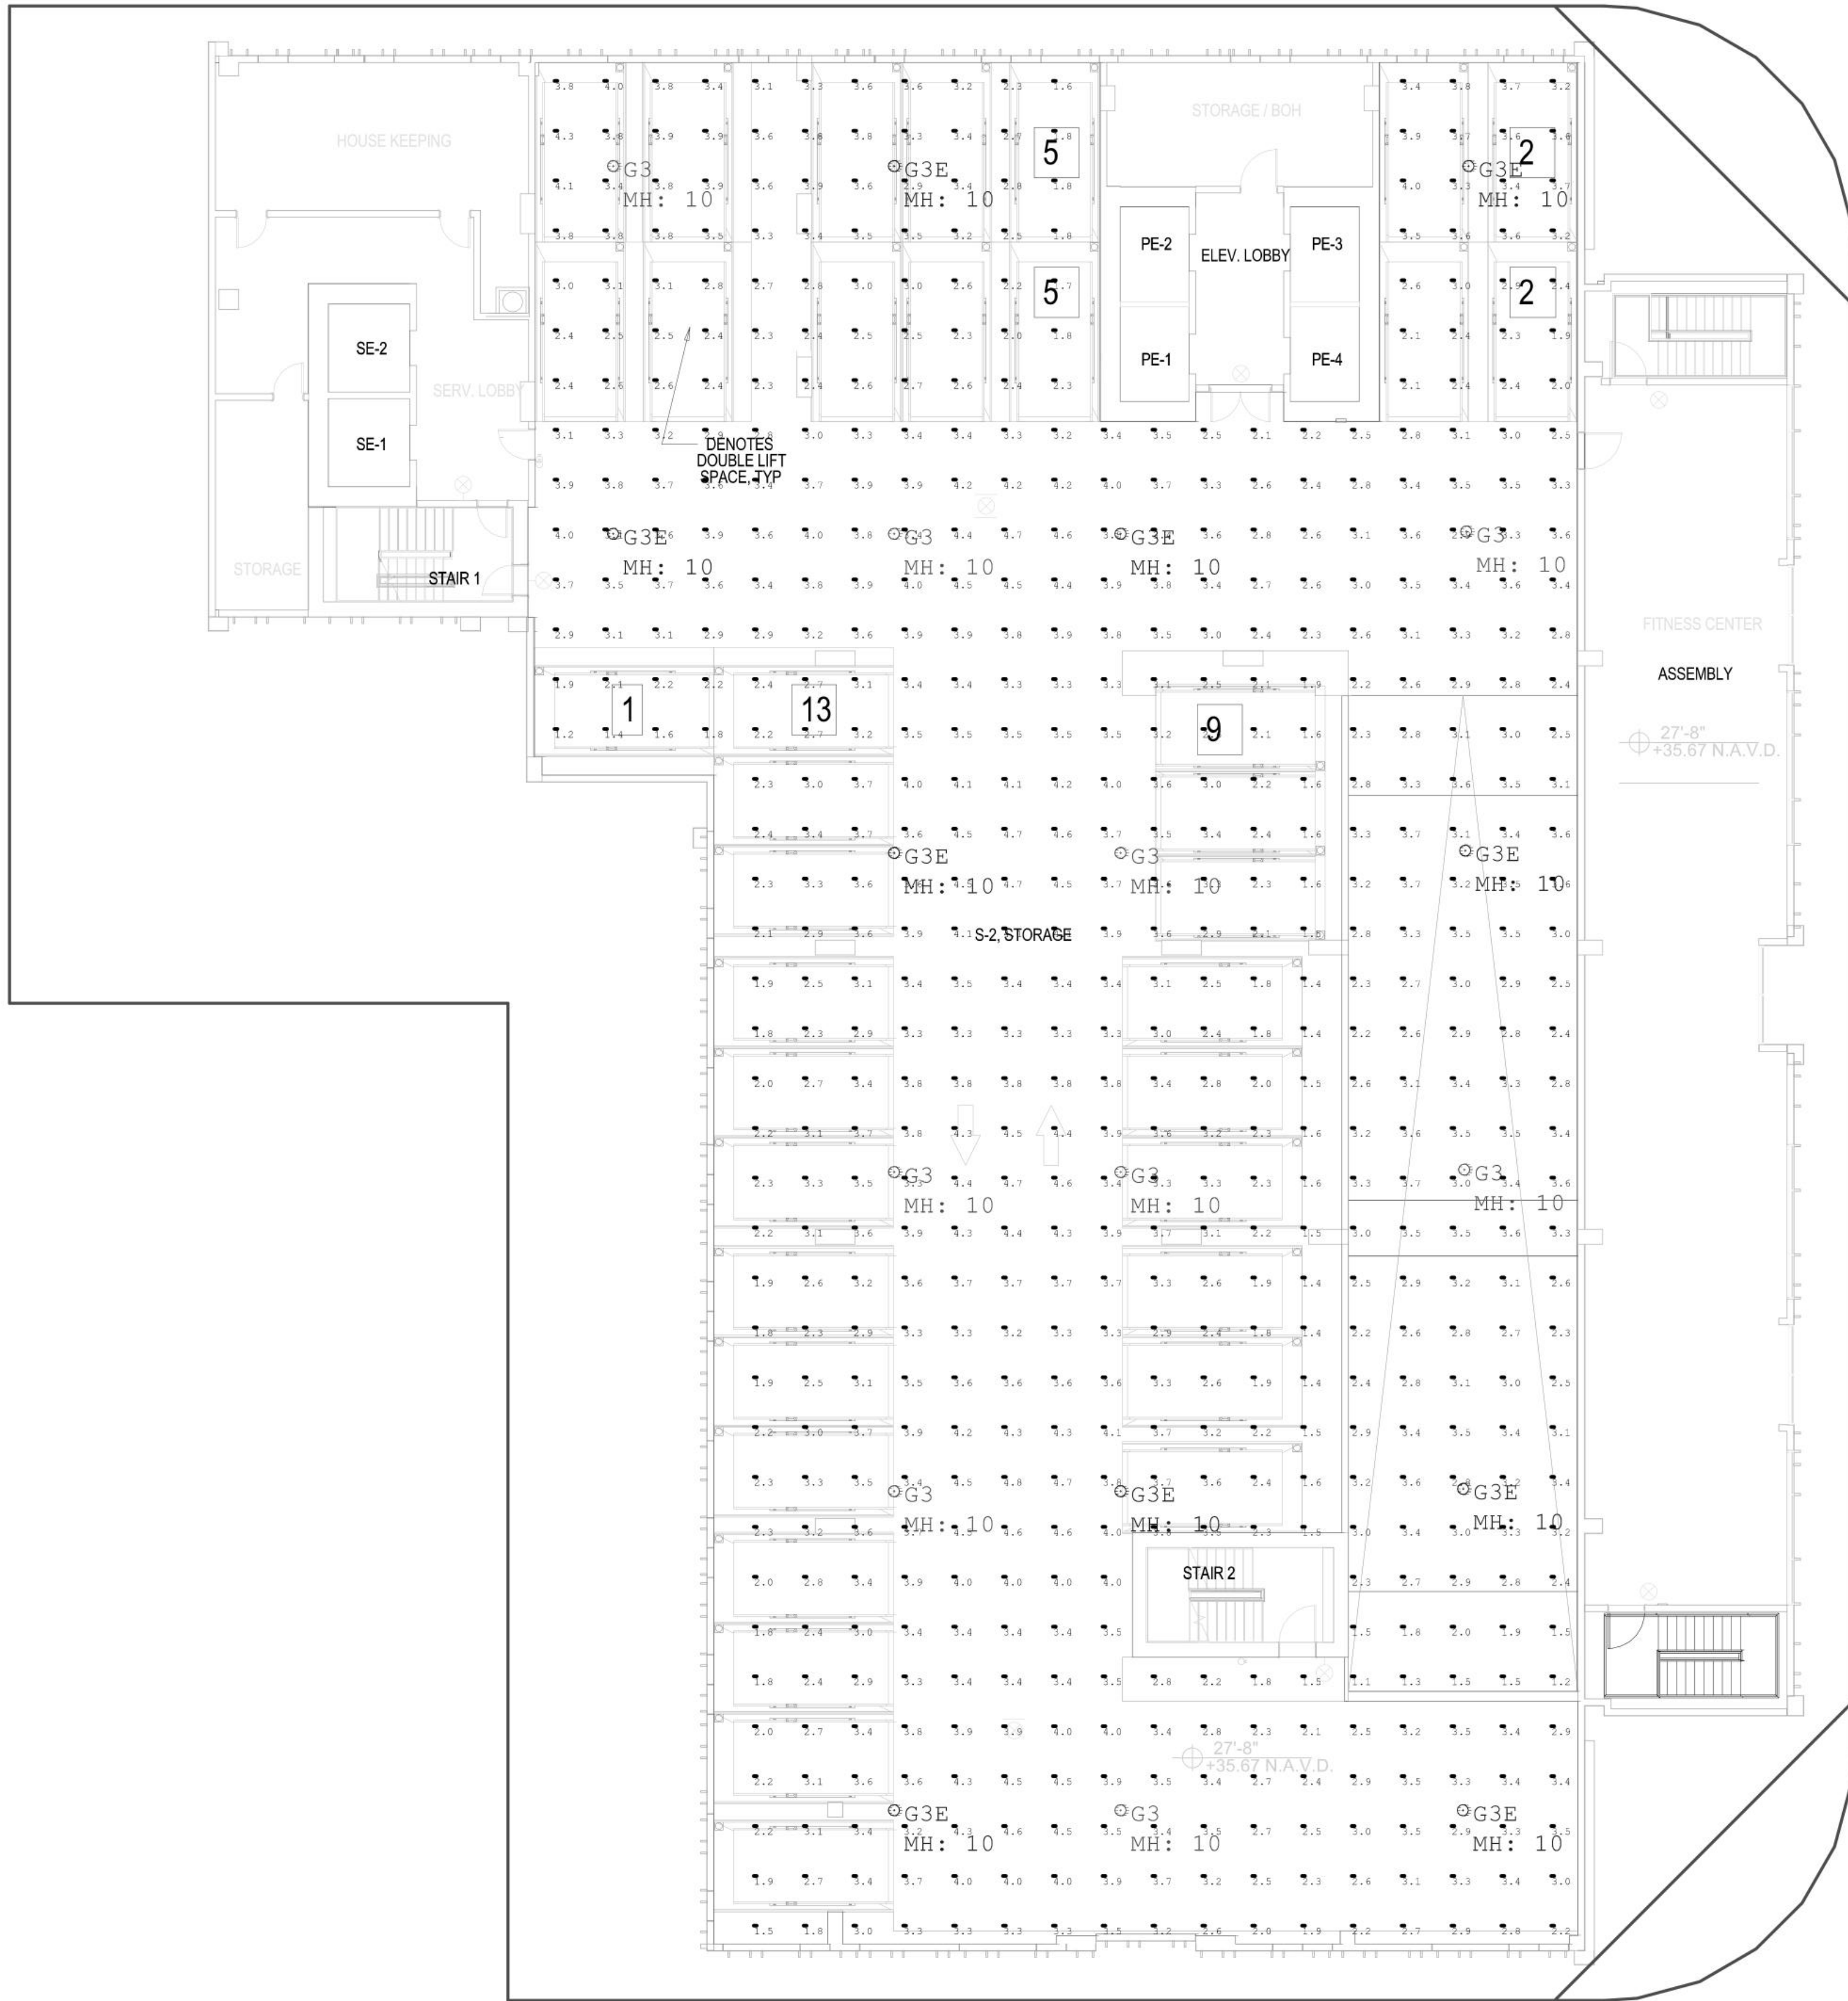

Luminaire Schedule								
Symbol	Qty	Label	Arrangement	Description	LLF	Luminaire Lumens	Luminaire Watts	Total Watts
⊙	10	G3E	Single	LSI Industries EXN-D-EGLED-03L-T5W-UNV-DIM-40-80CRI-XX (Connected To Generator)	0.900	3140	22	220
⊙	9	G3	Single	LSI Industries EXN-D-EGLED-03L-T5W-UNV-DIM-40-80CRI-XX	0.900	3140	22	198

Calculation Summary								
Label	CalcType	Units	Avg	Max	Min	Avg/Min	Max/Min	
Parking Garage_Floor	Illuminance	Fc	3.10	4.8	1.1	2.82	4.36	

DRC  
PZ23-12000042  
02/07/2024