

P&Z

PZ24-12000924

09/24/2025

MATCHLINE - SEE SHEET C-2.1 FOR CONTINUATION

F




E

D

C

B

A

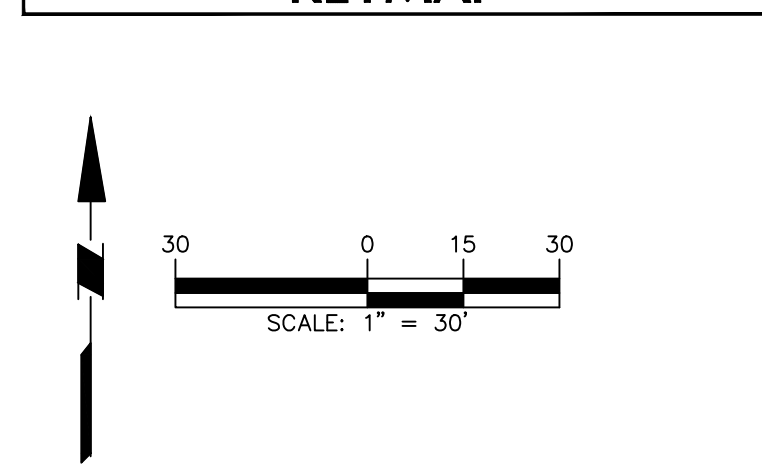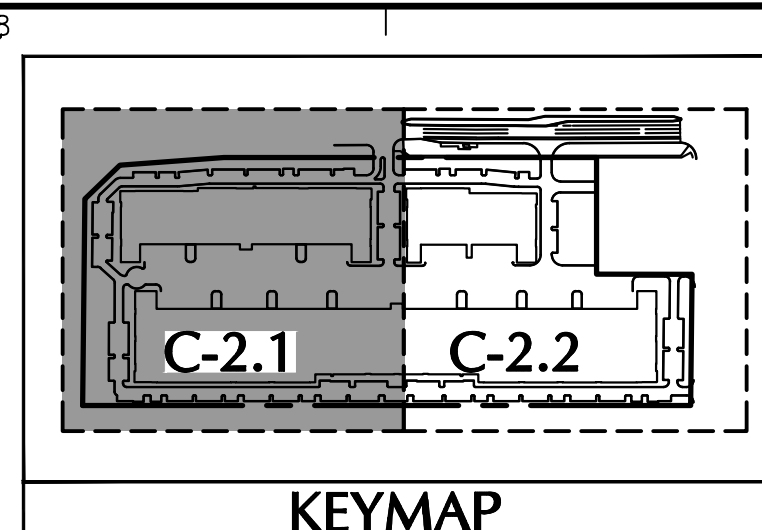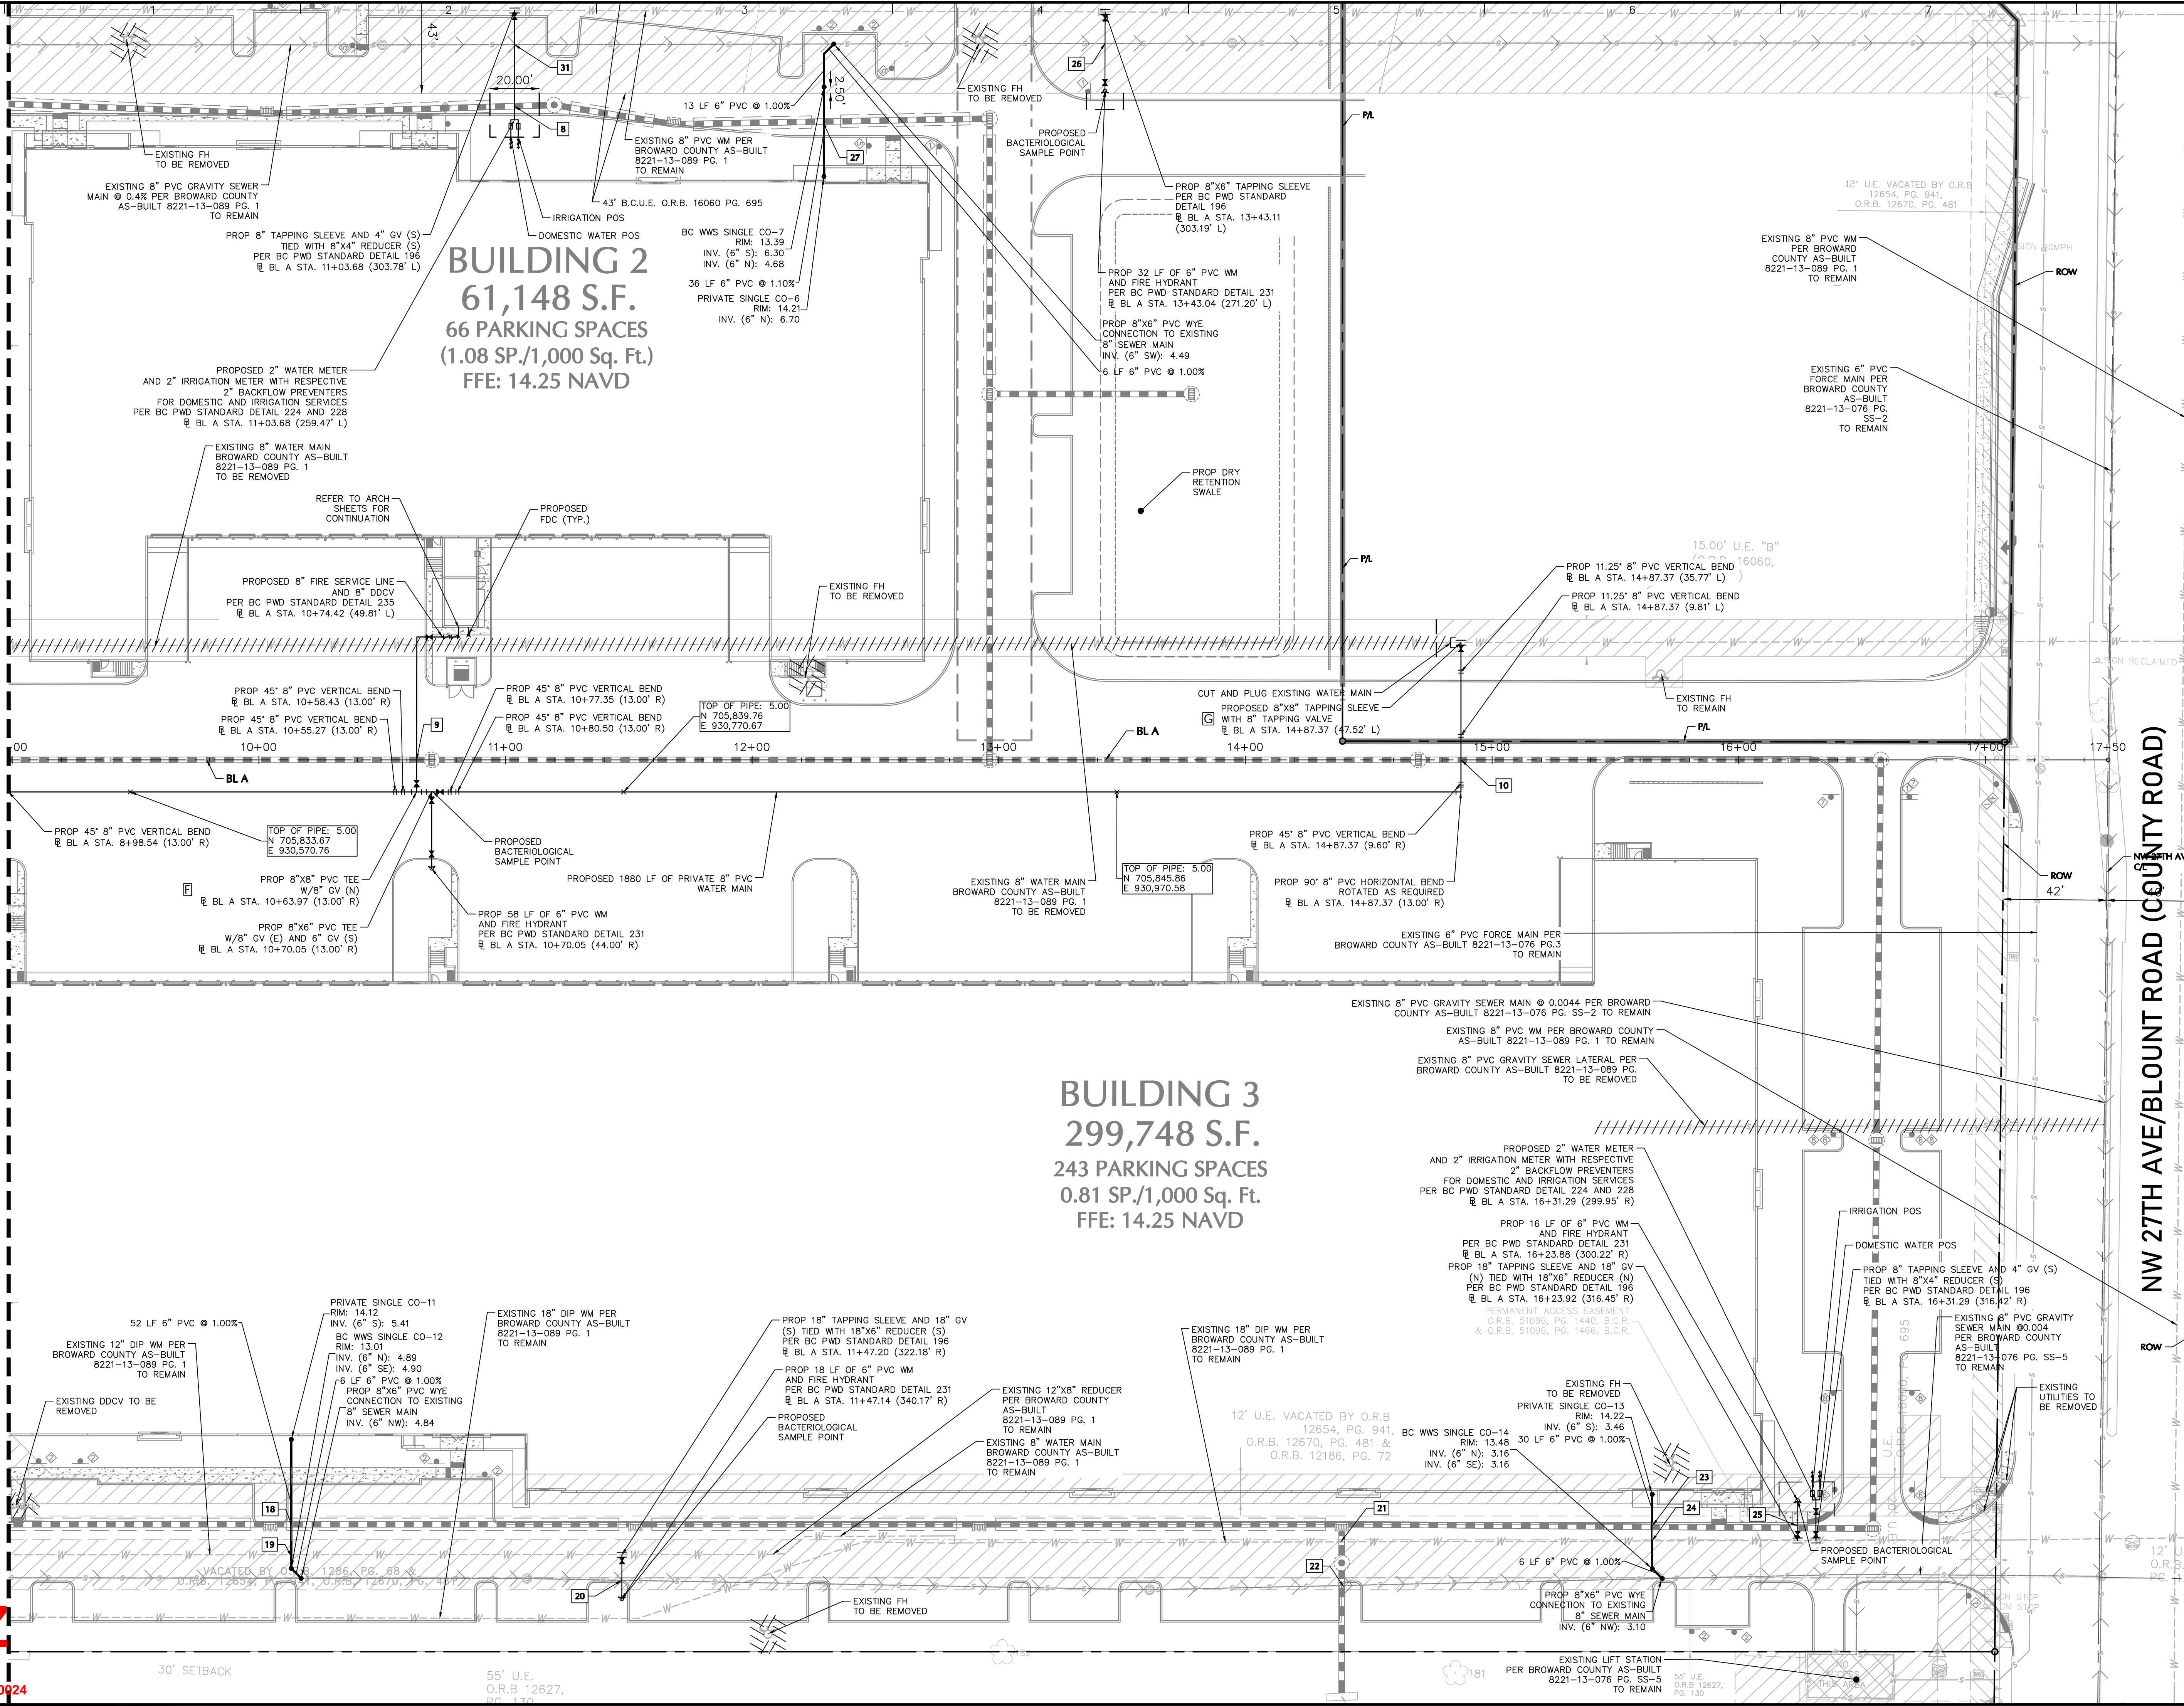

| UTILITY LEGEND | |
|----------------|------------------------------------|
| | FIRE HYDRANT |
| | BACKFLOW PREVENTER |
| | DOUBLE DETECTOR CHECK VALVE (DDCV) |
| | FIRE DEPT CONNECTION (FDC) |
| | METER BOX |
| | SANITARY SEWER MANHOLE |
| | SANITARY CLEANOUT |
| | PROPOSED WATER MAIN |
| | PROPOSED SEWER MAIN |
| | PROPOSED STORM PIPE |
| | EXISTING WATER MAIN |
| | EXISTING SEWER MAIN |
| | PROPOSED DRAINAGE MANHOLE |
| | PROPOSED CATCH BASIN |
| | UTILITY TO BE REMOVED |

| Date | Description | No. |
|---|-------------|-------------|
| REVISIONS | | |
| | | |
| SIGNATURE | | DATE SIGNED |
| MICHAEL CARR | | |
| PROFESSIONAL ENGINEER FL Lic. No. 72424 | | |
| LANGAN | | |
| Langan Engineering and Environmental Services, LLC | | |
| 110 East Broward Boulevard, Suite 1500 Fort Lauderdale, FL 33301 | | |
| T: 954.320.2100 F: 954.320.2101 www.langan.com | | |
| FL CERTIFICATE OF AUTHORIZATION NO. 00006601/LB172/LB198 | | |
| Project | | |

FESTIVAL INDUSTRIAL

POMPAÑO BEACH
BROWARD COUNTY FLORIDA

Drawing Title

| UTILITY PLAN | |
|---------------|-------------|
| Project No. | Drawing No. |
| 330134201 | C-2.2 |
| Date | Drawn By |
| JULY 2025 | MEP |
| Checked By | Drawn By |
| PZ24-12000924 | |