


Logo Cutout

SCALE: 1/4" = 1'-0"


07

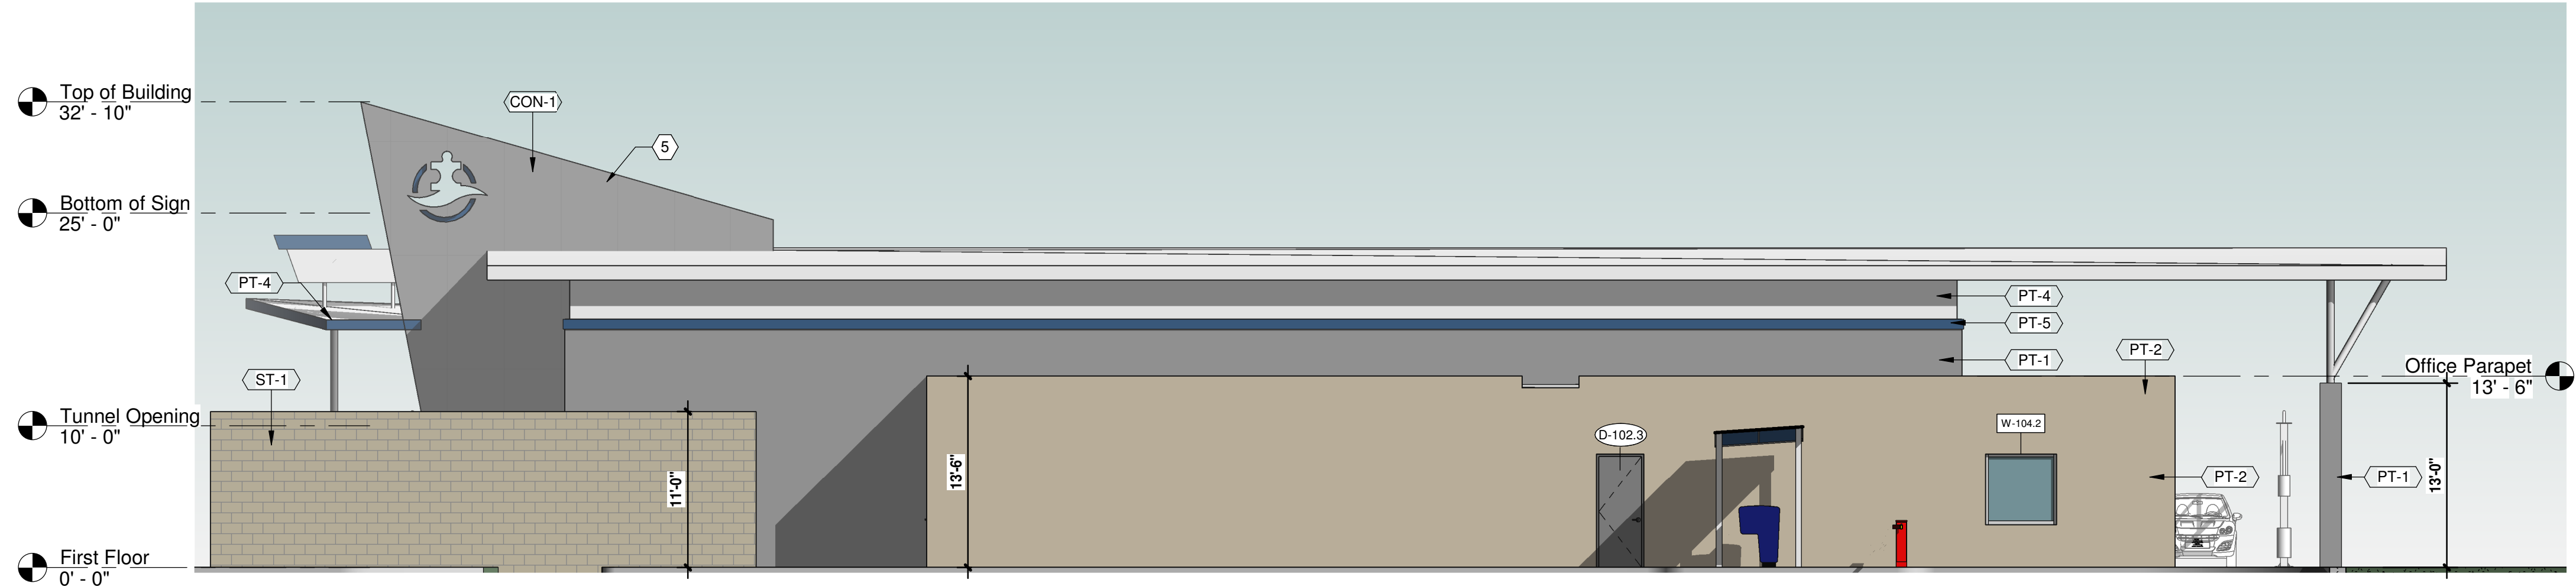

North Elevation

SCALE: 1/8" = 1'-0"

05

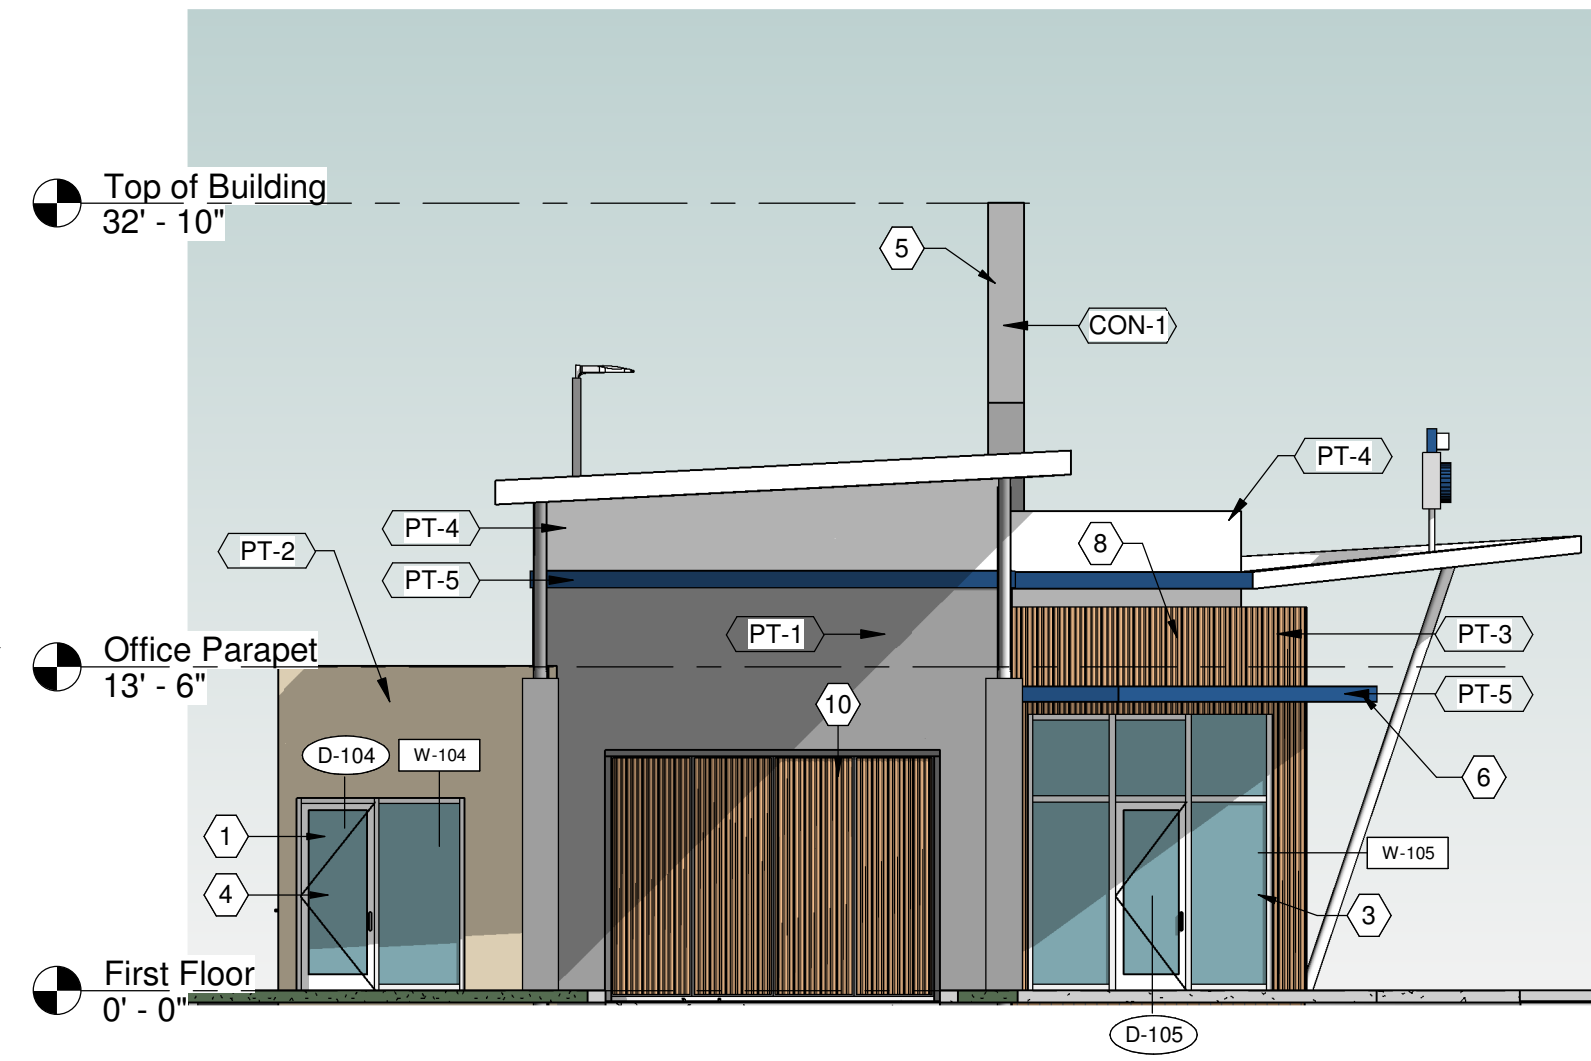

West Elevation

SCALE: 1/8" = 1'-0"


06



South Elevation

SCALE: 1/8" = 1'-0"

04

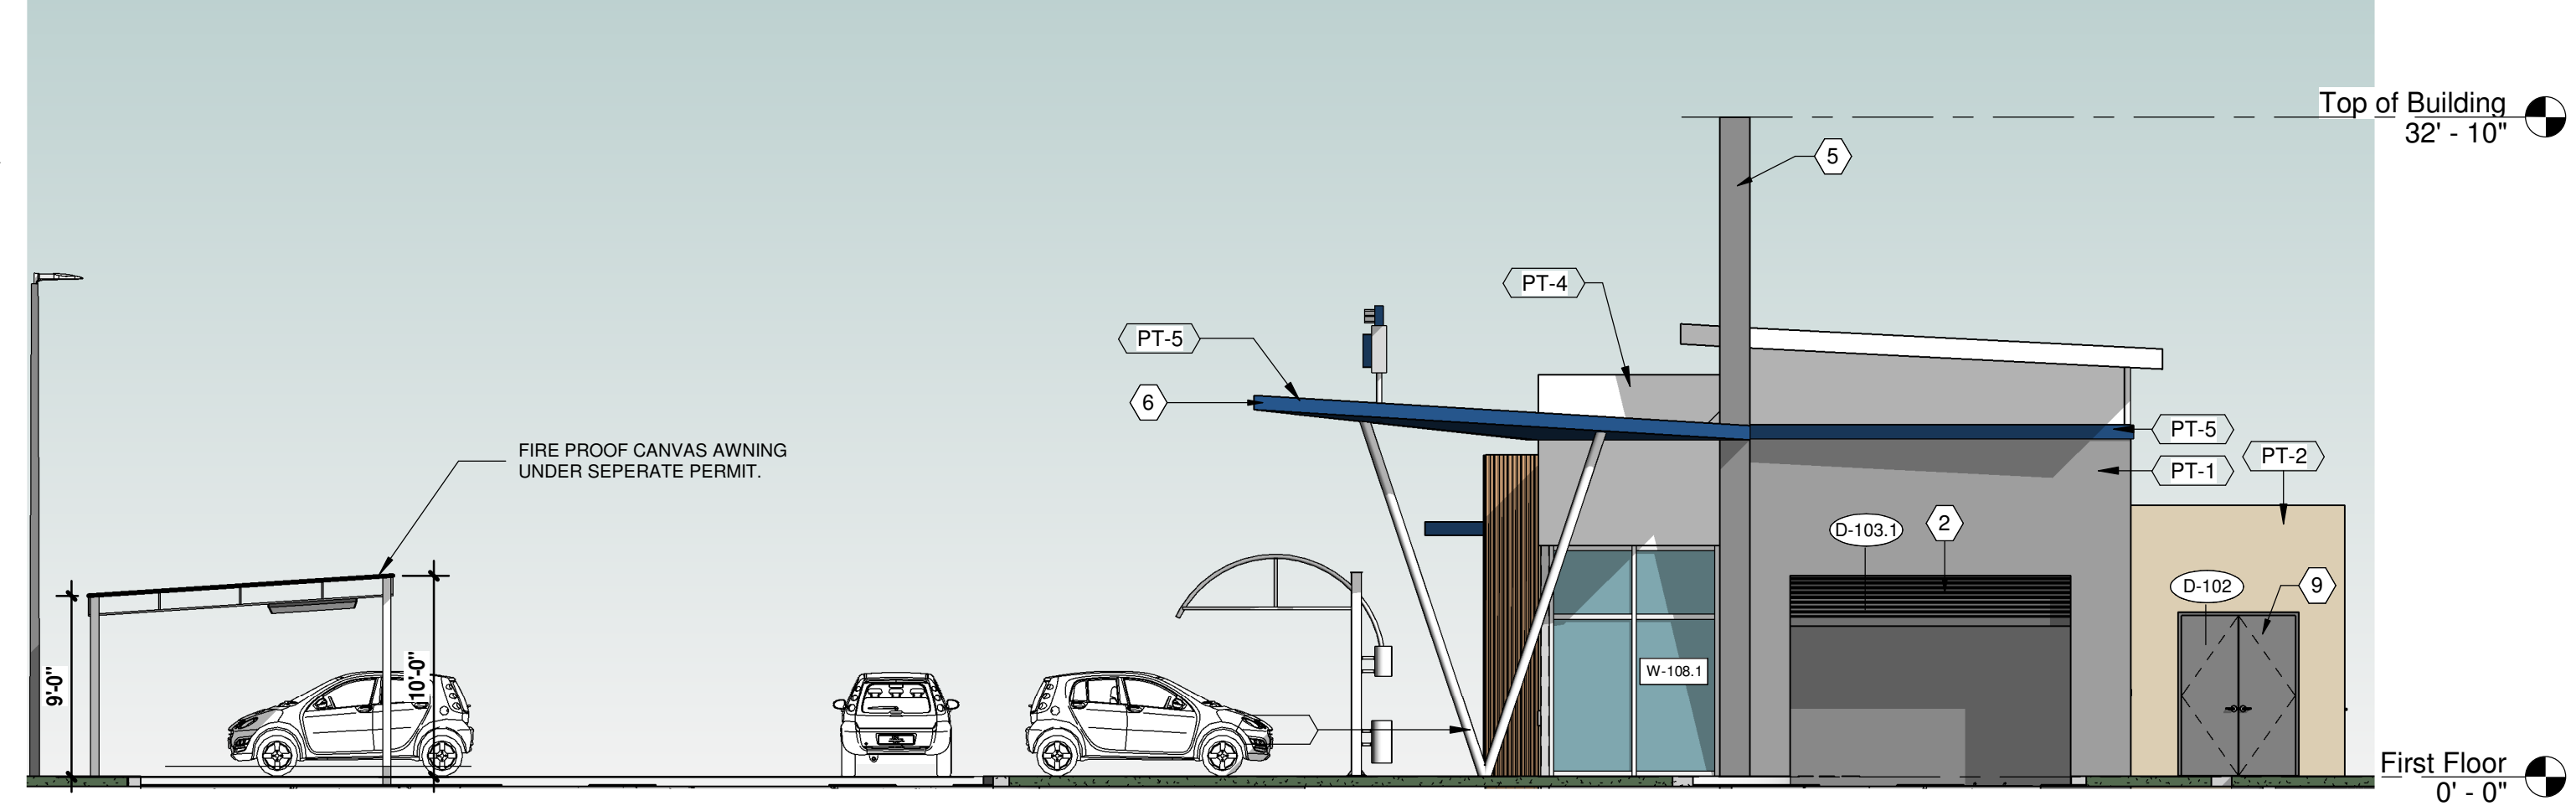

East Elevation

SCALE: 1/8" = 1'-0"

03

Exterior Material Schedule	
Mark	Description
CON-1	Exposed Cast in Place Concrete
PT-1	Paint Finish Sherwin Williams Gauntlet Gray SW 7019
PT-2	Paint Finish Sherwin Williams Sand Dollar SW 6599
PT-3	Paint Finish Sherwin Williams Decorous Amber 0007
PT-4	Paint Finish Sherwin Williams Reserved White SW 7056
PT-5	Paint Finish Sherwin Williams Capri SW 6788
ST-1	Split Face Block Wall Cream Color
WT-1	Porcelain tile, 4", white



Finish Schedule

GENERAL NOTES

- CONTRACTOR SHALL VERIFY ALL EXTERIOR MATERIAL COLORS AND FINISHES WITH THE ARCHITECT. ANY DISCREPANCIES NOTED SHALL BE BROUGHT TO THE ATTENTION OF THE ARCHITECT FOR CLARIFICATION.
- REFER TO LIGHTING PLANS FOR LIGHTING FIXTURE LOCATION AND SCHEDULE.
- SEPERATE BUILDING PERMIT MUST BE OBTAINED FOR ALL SIGNS

Elevations Keynote	
No.	Keynote
1	MAIN ENTRY DOOR: 3'-0" X 8'-0" STOREFRONT SYSTEM, IMPACT RATED ANODIZED
2	14" WIDE X 10'-0" HIGH ROLLING OVERHEAD GARAGE DOOR, FACTORY FINISH TO MATCH PT-1 PAINT FINISH
3	STOREFRONT GLAZING SYSTEM - IMPACT RATED ANODIZED ALUM. MULLIONS WITH CLEAR IMPACT GLASS PANELS REFER TO S-5.0 FOR WIND LOADS
4	STOREFRONT GLAZING SYSTEM - ANODIZED ALUM. MULLIONS WITH BLACKED-OUT GLASS PANELS
5	VACUUM PUMP
6	METAL CANOPY CONTRACTOR TO PROVIDE SHOP DRAWINGS, GROUT FILLED CELLS FOR SUPPORT TIE PLATE
7	VACUUM BOOM
8	NATURALLY WEATHERED CORRUGATED METAL PANELS, BURNT ORANGE
9	PAIR OF 5' W X 6' H HOLLOW METAL IMPACT DOORS, PC-1 SEMI GLOSS PAINT
10	BI FOLDING METAL DOORS

Joshua A. Gonzalez
The Sherwin Williams Company
Professional Coatings Representative
954-868-4952
Joshua.a.gonzalez@sherwin.com

Elevation Notes

01

DRC