


Y:\Shared\Documents\001-Engineering\Sunshine Gasoline Distributors\21119 - 525-8010 Che-301 Pompano Hwy re-issued Nov 202402 - DWG File\0305 - Cn\0003 21119 DWG.dwg, 3/15/2025 1:30:16 PM




Know what's below.
Call before you dig.

Copyright © MDM SERVICES, INC.


All rights reserved. No part of this plan may be reproduced, distributed, or transmitted in any form or by any means, including photocopying, recording, electronic or mechanical methods, without the prior written permission of MDM Services, Inc. For permission requests, write MDM Services, Inc., 1055 Kathleen Road, Lakeland, FL 33809.

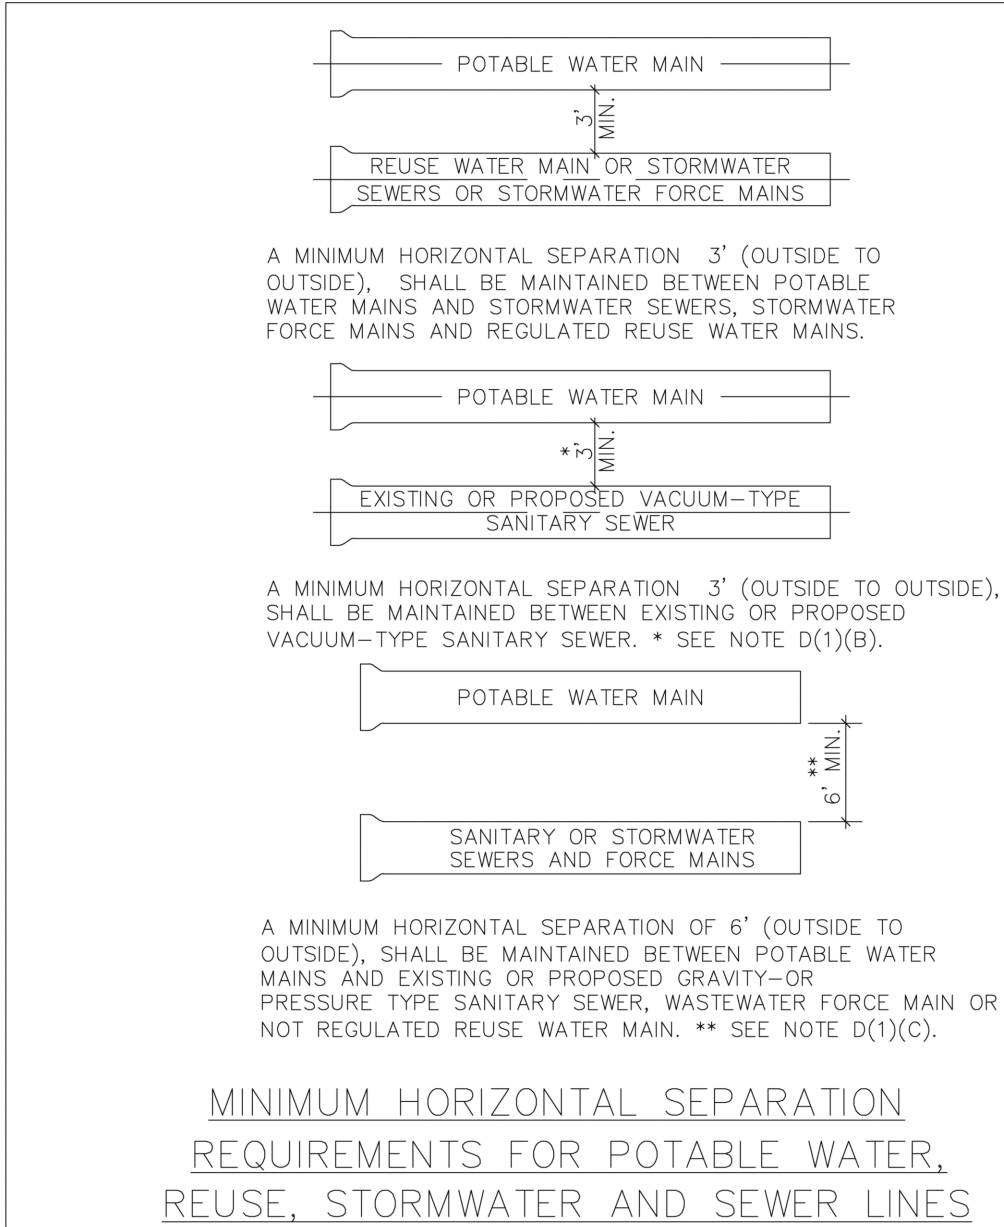

ENGINEERING STANDARDS 2022			
REVISIONS	ENGINEERING DIVISION	MIN. HORIZONTAL SEPARATION FOR SANITARY SEWER	
BY DATE	CITY OF POMPAÑO BEACH		
S.S. 01/30/12		DATE: JUNE 2022	DWG. NO. 209-1
	SCALE: N.T.S.		

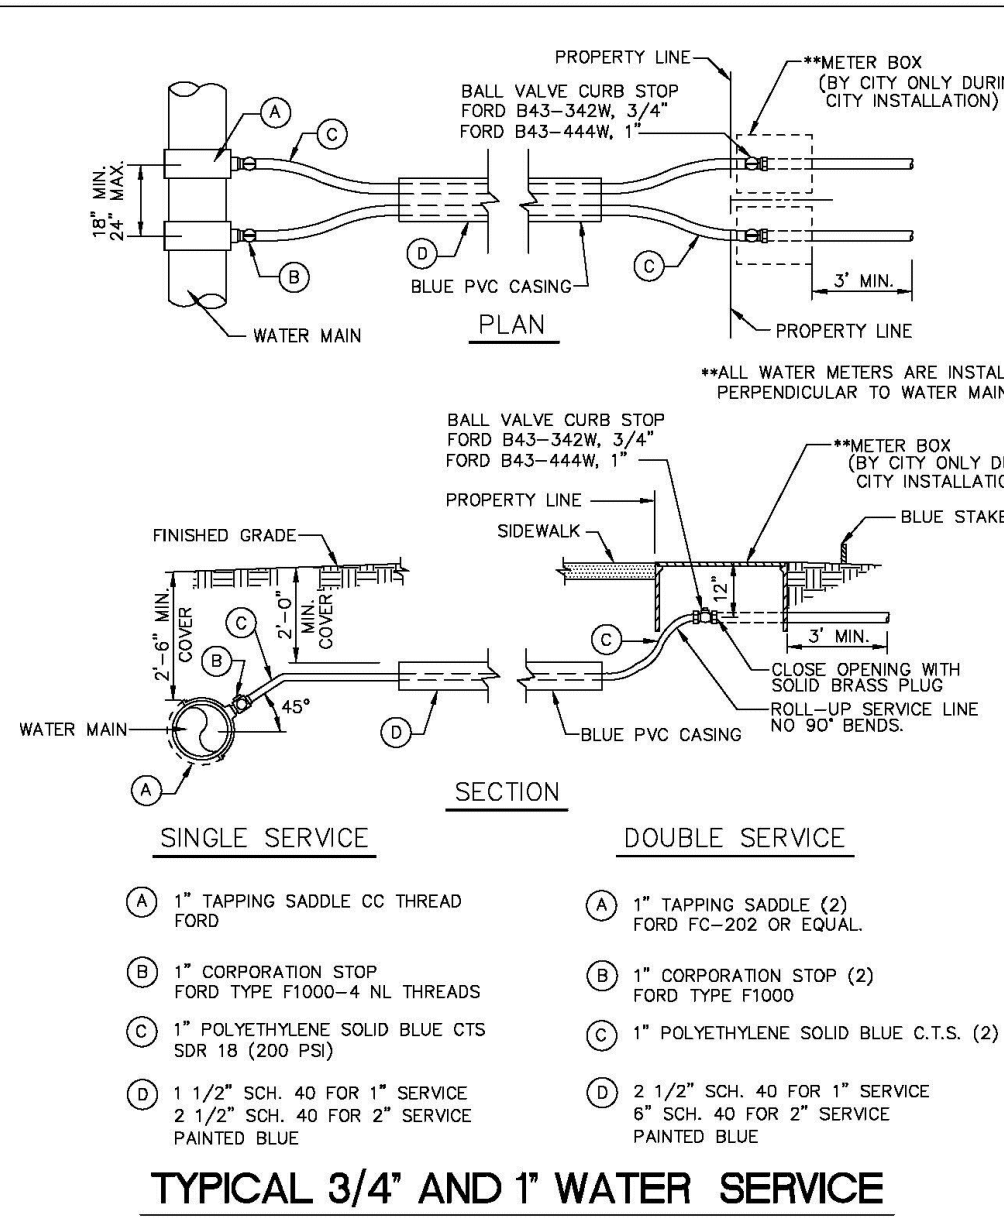


ENGINEERING STANDARDS 2025			
REVISIONS	ENGINEERING DIVISION	TYPICAL 1\"/>	
BY DATE	CITY OF POMPAÑO BEACH		
T.W. 11-2007		DATE: MAY 2022	DWG. NO. 107-1
S.S. 05-2012			
S.S. 11-2015	SCALE: N.T.S.		
A.S. 08-2021			

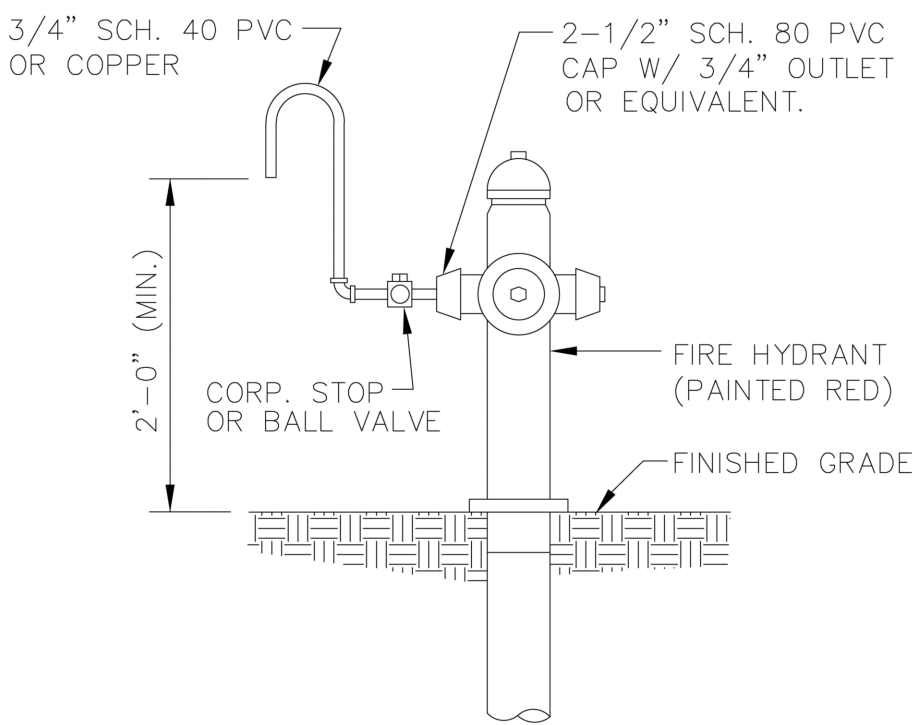


SAMPLE POINT (HYDRANT)

ALL POMPAÑO BEACH HYDRANTS SHALL BE PAINTED RED.

ENGINEERING STANDARDS 2022			
REVISIONS	ENGINEERING DIVISION	SAMPLE POINT (HYDRANT)	
BY DATE	CITY OF POMPAÑO BEACH		
S.S. 04-2009		DATE: JAN. 2022	DWG. NO. 101-1
	SCALE: N.T.S.		

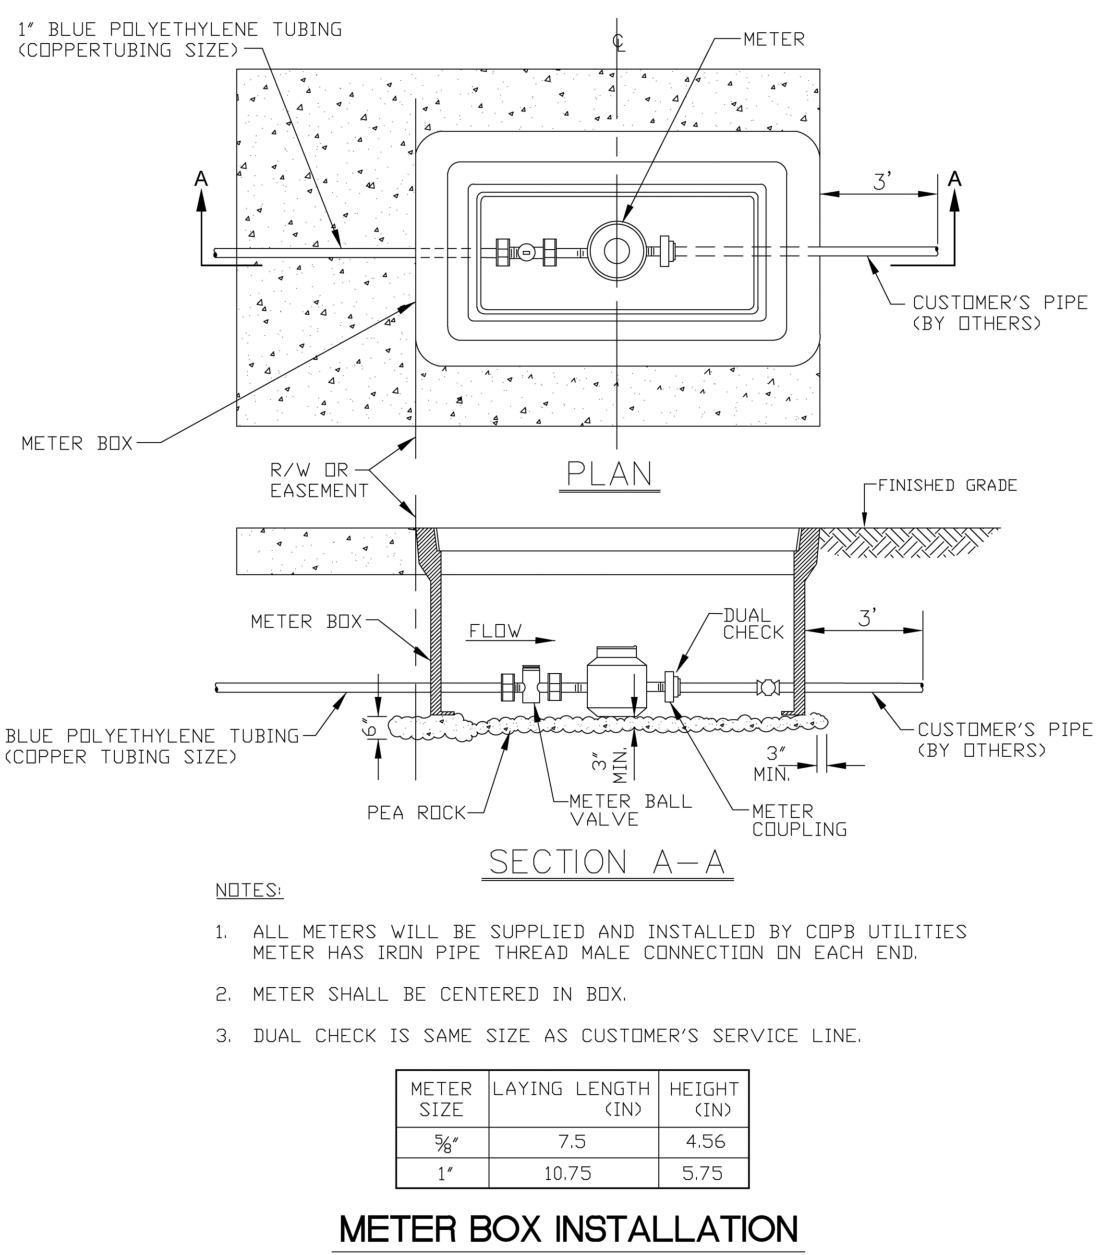


ENGINEERING STANDARDS 2022			
REVISIONS	ENGINEERING DIVISION	METER BOX INSTALLATION FOR 5/8\"/>	
BY DATE	CITY OF POMPAÑO BEACH		
S.S. 11-2012		DATE: JAN. 2022	DWG. NO. 105-2
	SCALE: N.T.S.		

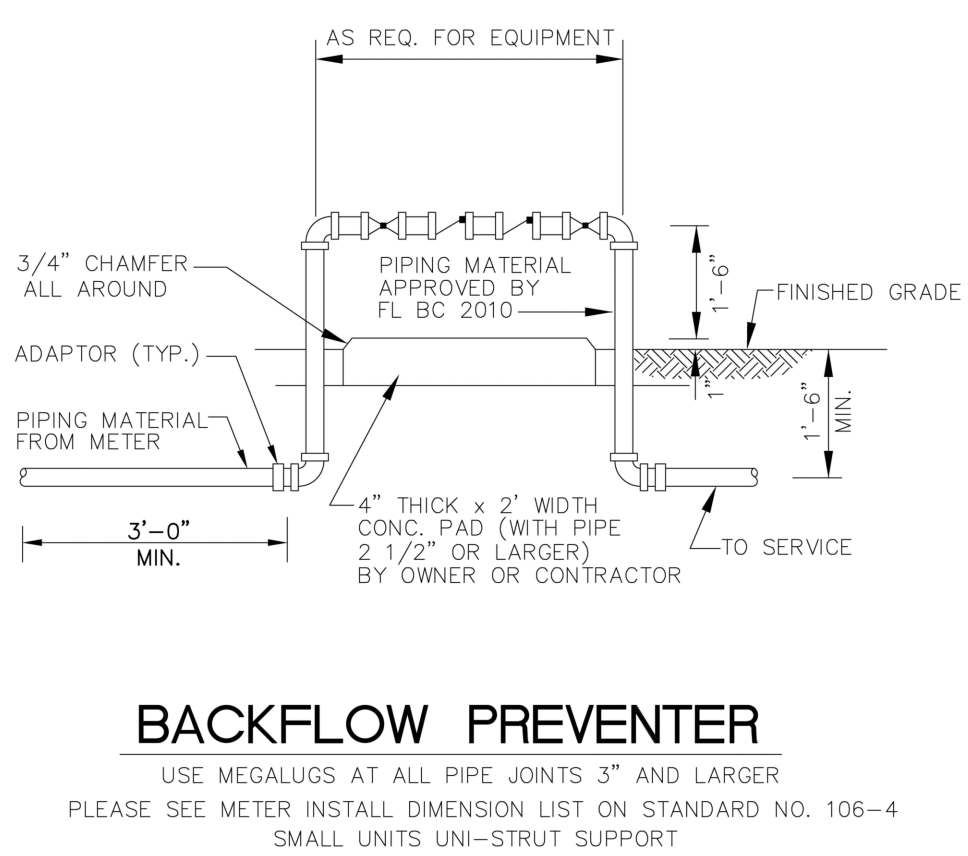

BACKFLOW PREVENTER

USE MEGALUGS AT ALL PIPE JOINTS 3" AND LARGER
PLEASE SEE METER INSTALL DIMENSION LIST ON STANDARD NO. 106-4
SMALL UNITS UNI-STRUT SUPPORT

ENGINEERING STANDARDS 2022			
REVISIONS	ENGINEERING DIVISION	BACKFLOW PREVENTER	
BY DATE	CITY OF POMPAÑO BEACH		
T.W. 04-2009		DATE: MAY 2022	DWG. NO. 106-1
S.S. 03-2009			
S.S. 11-2012	SCALE: N.T.S.		
S.S. 01-2013			

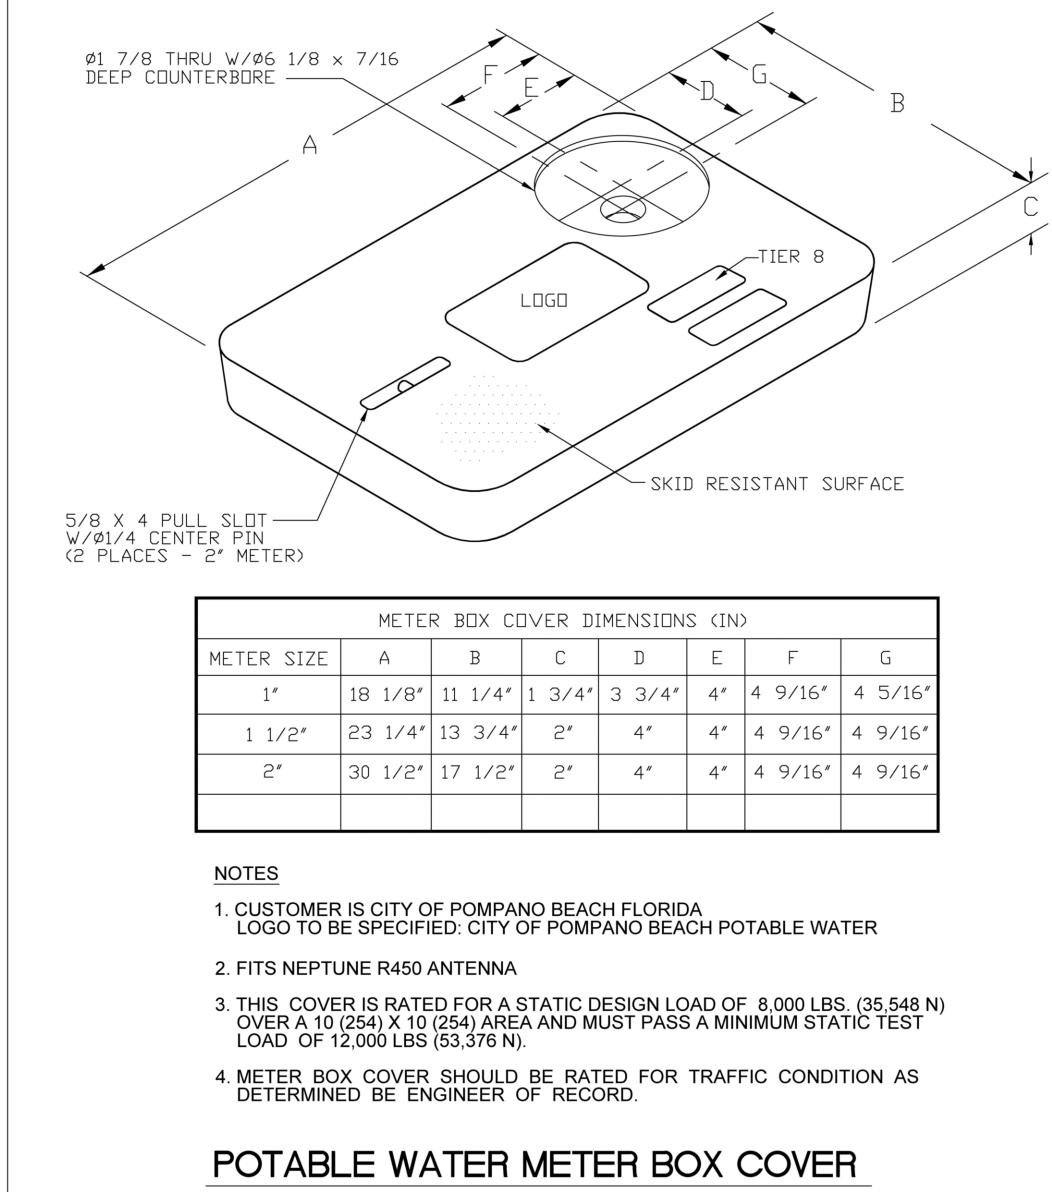

ENGINEERING STANDARDS 2022			
REVISIONS	ENGINEERING DIVISION	TYPICAL METER BOX COVER	
BY DATE	CITY OF POMPAÑO BEACH		
S.S. 11-2012		DATE: JAN. 2022	DWG. NO. 105-3
	SCALE: N.T.S.		

CLIENT:




DESIGN TEAM TITLE:

MDM
SERVICES, INC.

engineering • environmental • construction

2151 W. HILLSBORO BLVD, DEERFIELD BEACH,
FLORIDA 33442
Phone: (954) 427-3076
FLORIDA CA #4857

NO. DATE REVISION DESCRIPTION

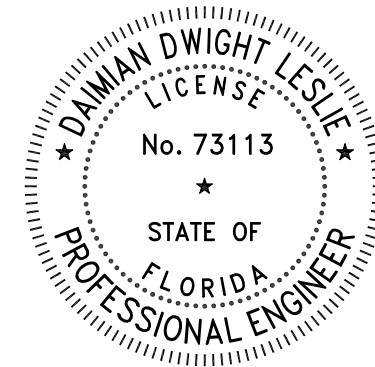

DAIMAN D. LESLIE
FL REG # 73113

THIS FIRM HAS BEEN DIGITALLY SIGNED AND SEALED BY DAIMAN D. LESLIE. ON THE DATE
MAGNET TO THE SEAL. THESE COPIES OF THIS DOCUMENT ARE NOT CONSIDERED SIGNED
AND SEALED AND THE SIGNATURE MUST BE VERIFIED ON ANY ELECTRONIC COPIES.

PROJECT DESCRIPTION:

**NEW
C-STORE**

SITE DESIGNATION:

**SUNSHINE GASOLINE DISTRIBUTORS
CHEVRON
GAS STATION #010**

SITE ADDRESS:

**301 POMPAÑO PKWY,
POMPAÑO BEACH, FL
33069**

SCALE: AS NOTED MDM JOB # 21119

DATE: 08-11-2022

DESIGNED BY:

DRAWN BY:

FILE NAME:

CHECKED BY:

21119 CD.DWG

DRAWING TITLE:

UTILITY PLAN

SHEET NO:

DRG-C-4.1

PZ25-12000017

07/02/2025