





absolute-idea.com  
CANAL PARK  
3523 NE 163rd Street, Suite 200 North Miami Beach, FL 33160  
T 305.792.0015 T 305.931.0279 @info@absolute-idea.com

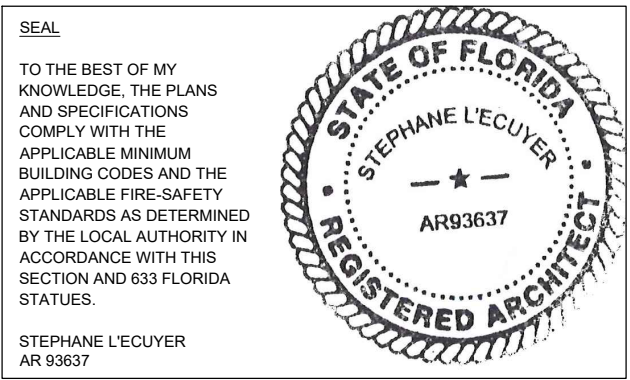

ISSUE FOR:  
**DRC SUBMITTAL**

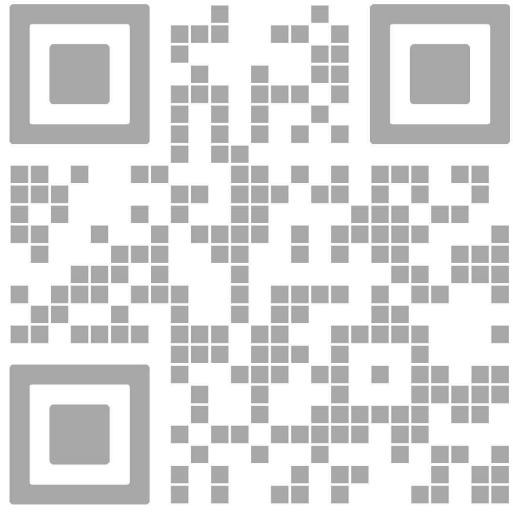

REV.	DATE	DESCRIPTION
01	05-13-2025	DRC SUBMITTAL

ALL MEASUREMENTS MUST BE VERIFIED BEFORE BEGINNING THE WORKS. NO MEASUREMENTS ARE TO BE SCALED DIRECTLY FROM THIS DRAWING.

Key section

Client  
**VERA FUND**  
NICK POLYUSHKIN  
& YURI KHARITONENKOV  
TEL: 305.833.3303


Project  
**1600 S FEDERAL HIGHWAY  
(MIXED-USE PROJECT)**  
1600 SOUTH FEDERAL HIGHWAY,  
POMPAÑO BEACH, FL 33062

Title  
**LEVEL 1.5  
PHOTOMETRICS**


Drawn	Field
J. WU	ARCHITECTURE
N. TREMBLAY	Scale
S. L'ECUYER	as shown
J. WU	Date
11/19/2025	08-15-2025
24-838	Dwg. no.
P-002	

Calculation Summary							
Label	CalcType	Units	Avg	Max	Min	Avg/Min	Max/Min
Parking Garage Floor	Illuminance	FC	12.24	81.1	1.2	6.84	103.5
Luminaire Schedule							
Symbol	Qty	Label	Arrangement	Description	LMF	Luminaire Lumens	Luminaire Watts
○	18	01E	Single	Utopia Lighting LRC-36-SLE8-40K-08V-W8 (connected to	0.900	4810	57
○	18	01E	Single	Utopia Lighting LRC-36-SLE8-40K-08V-W8 (connected to	0.900	4810	57
○	11	01	Single	Utopia Lighting LRC-36-SLE8-40K-08V-W8 (connected to	0.900	4810	57

Calculation Summary							
Label	CalcType	Units	Avg	Max	Min	Avg/Min	Max/Min
Parking Garage Floor	Illuminance	FC	12.24	81.1	1.2	6.84	103.5
Luminaire Schedule							
Symbol	Qty	Label	Arrangement	Description	LMF	Luminaire Lumens	Luminaire Watts
○	18	01E	Single	Utopia Lighting LRC-36-SLE8-40K-08V-W8 (connected to	0.900	4810	57
○	18	01E	Single	Utopia Lighting LRC-36-SLE8-40K-08V-W8 (connected to	0.900	4810	57
○	11	01	Single	Utopia Lighting LRC-36-SLE8-40K-08V-W8 (connected to	0.900	4810	57

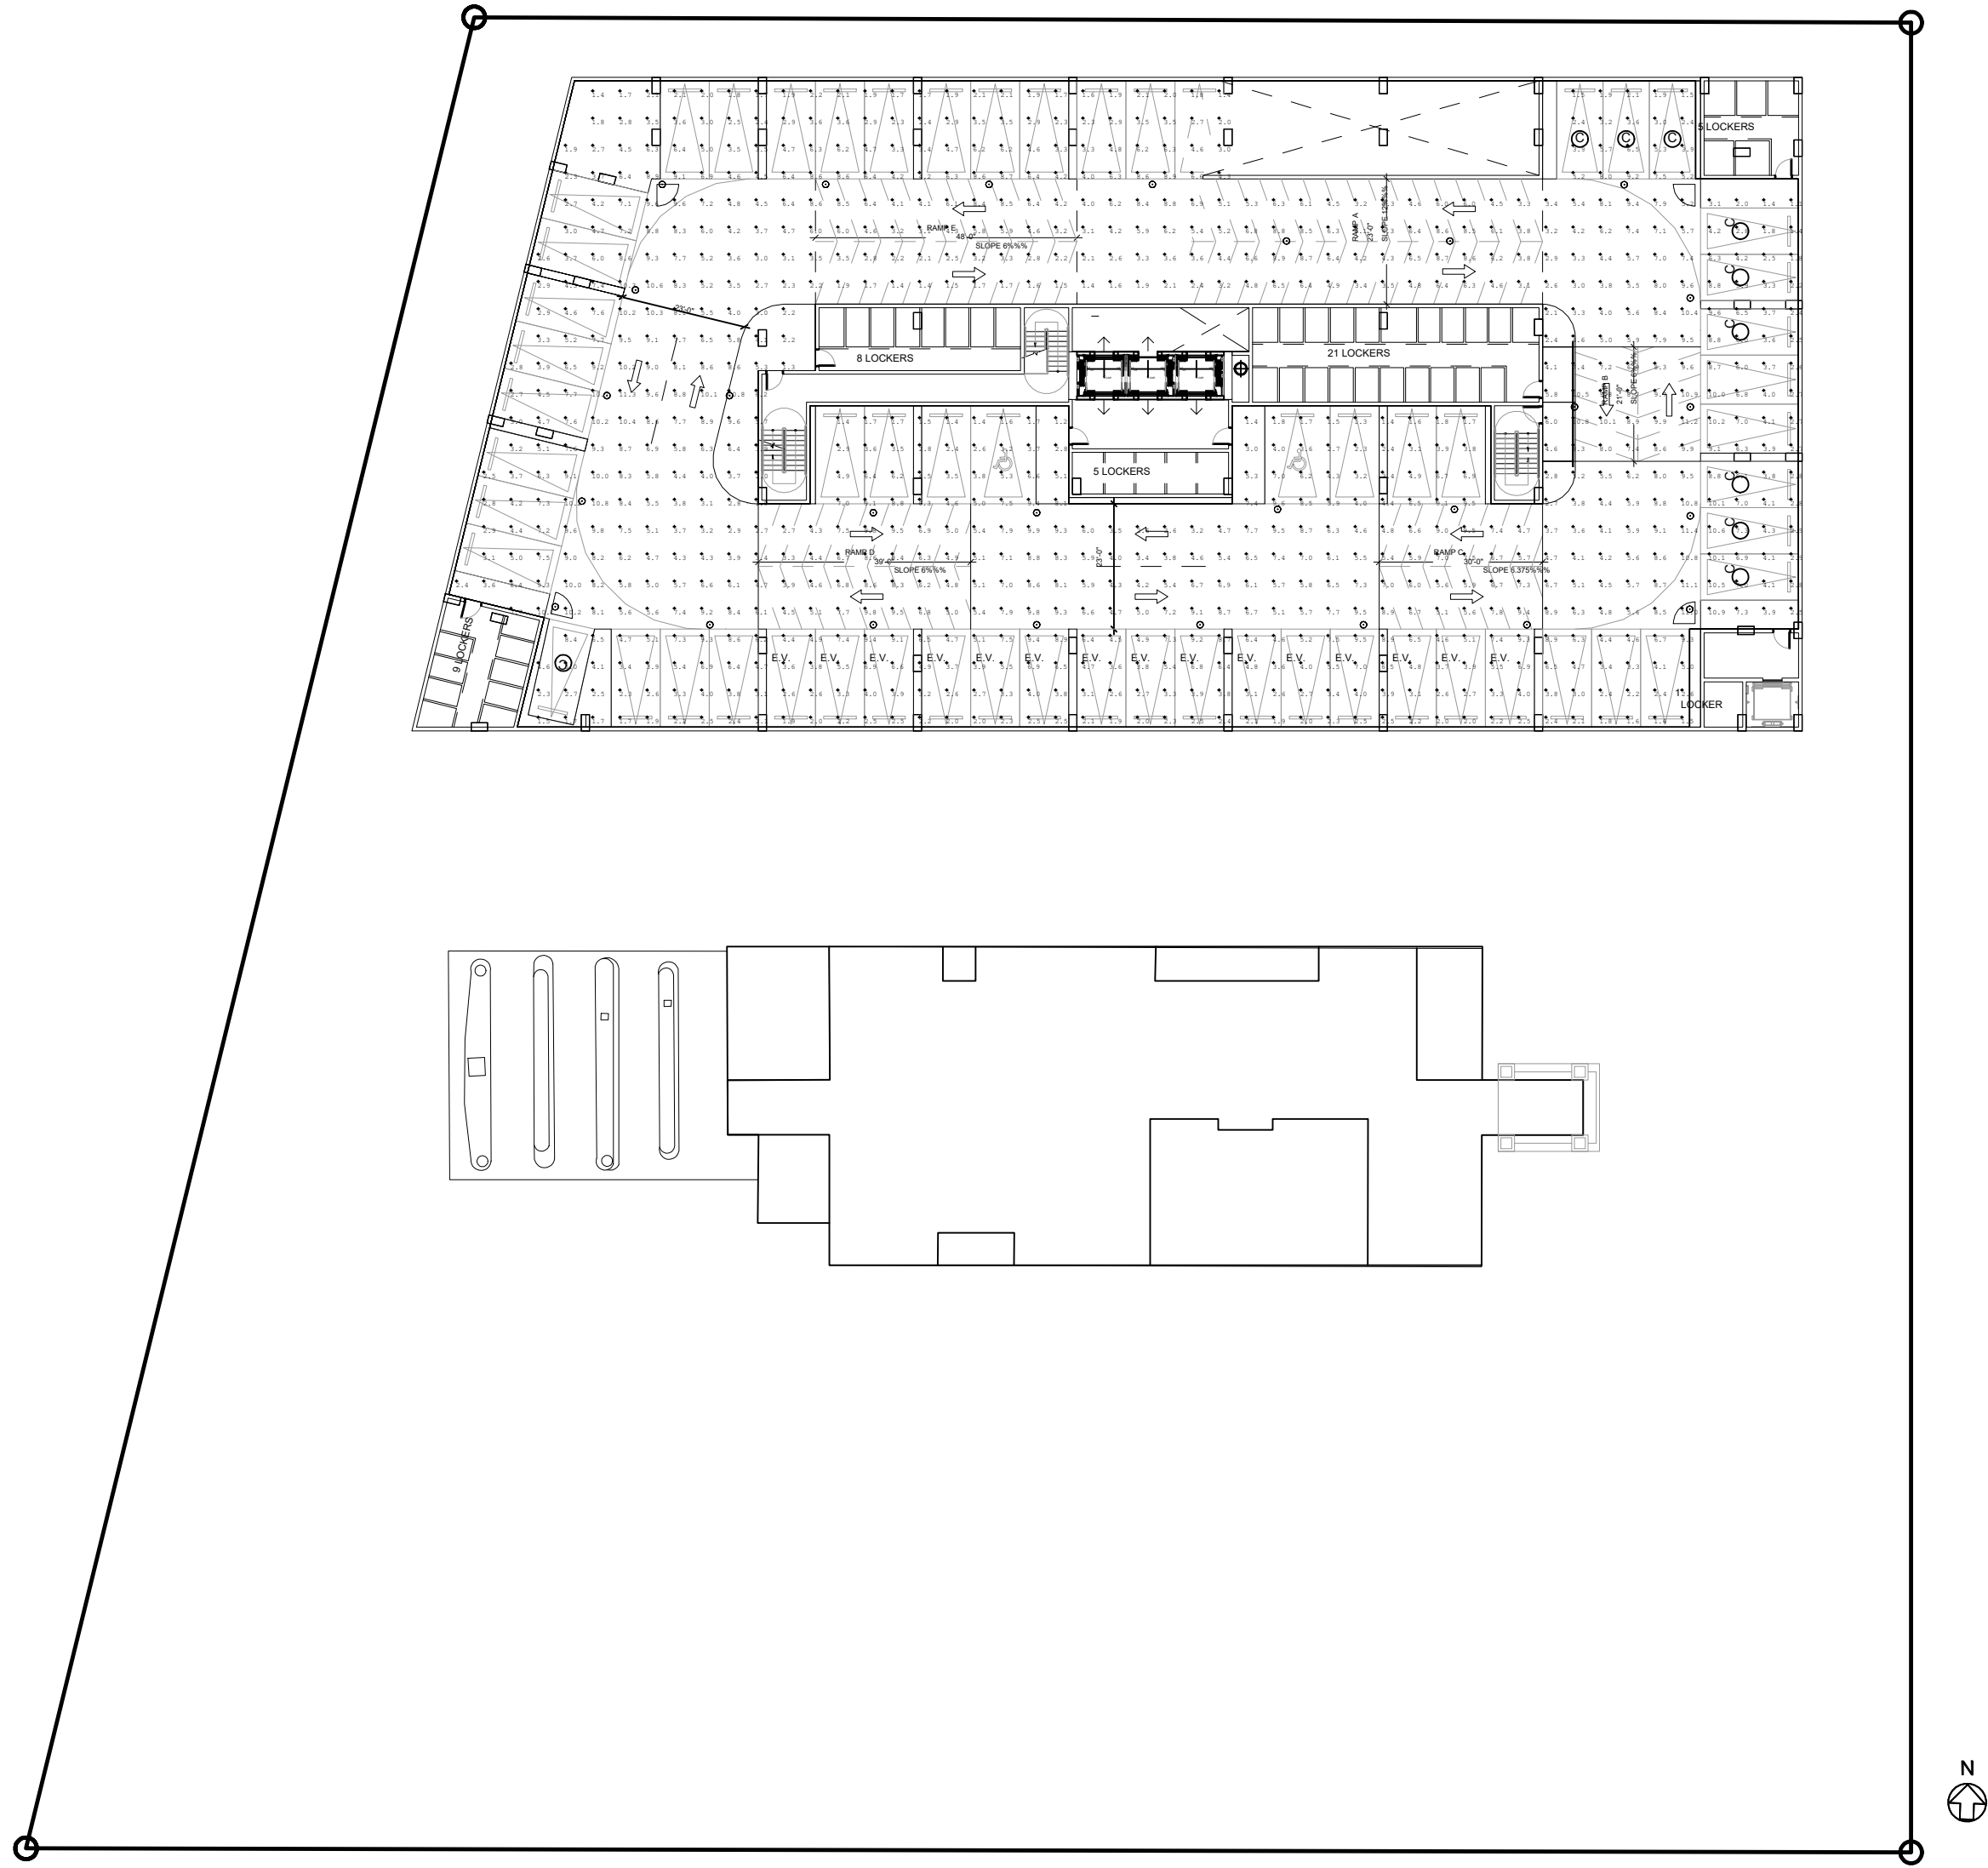

LEVEL 1.5  
PHOTOMETRICS - NORMAL  
SCALE: 1"= 30'-0"

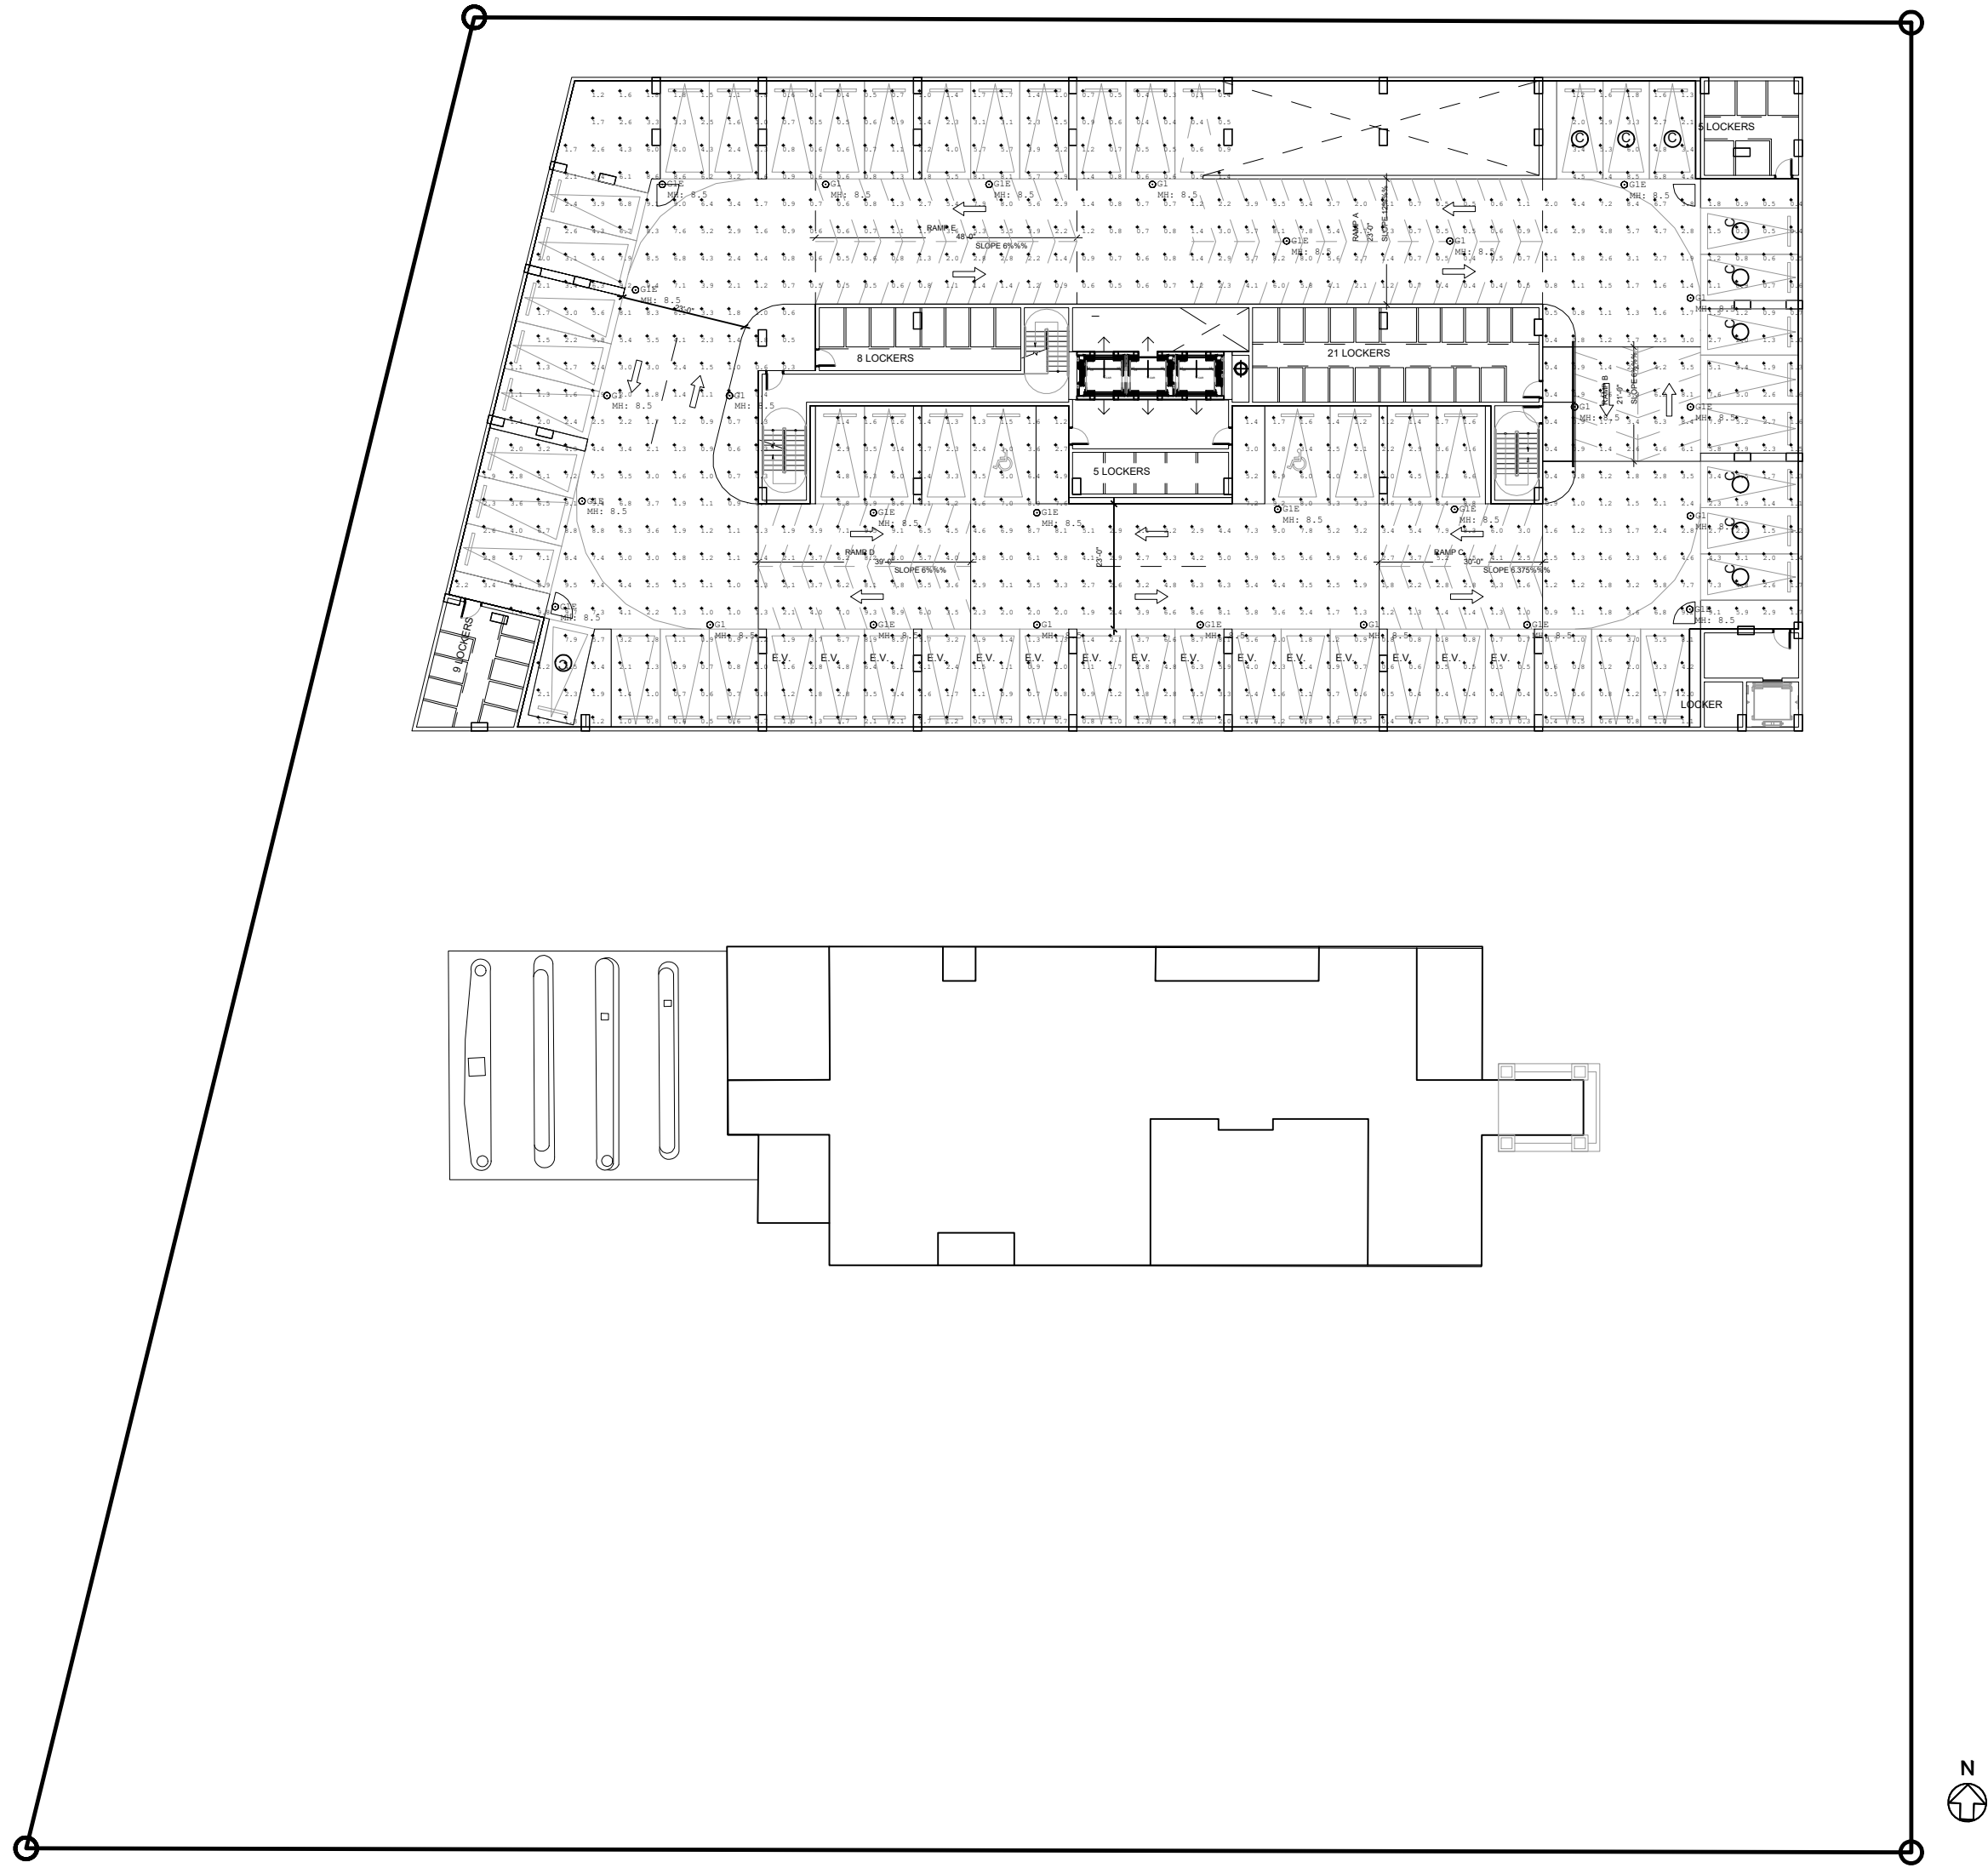

LEVEL 1.5  
PHOTOMETRICS - EMERGENCY  
SCALE: 1"= 30'-0"

