


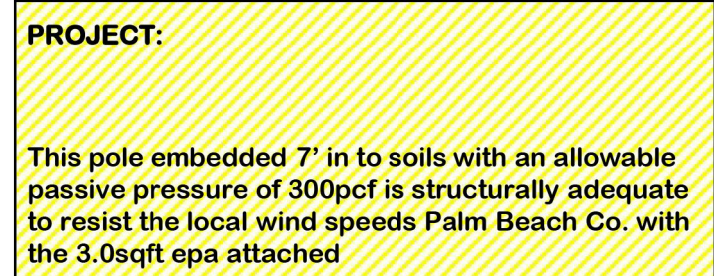


Luminaire Schedule								
Symbol	Qty	Label	Arrangement	Description	LLF	Luminaire Lumens	Luminaire Watts	Total Watts
	4	S1B	Single	Xtra Light VNTS-10000L-40K-DIM-3M-N-XX-XX	0.900	11308	75.8	303.2
	10	S1A	Single	Xtra Light VNTS-10000L-40K-DIM-4M-N-XX-XX-HSS	0.900	7484	76	760
	9	G	Single	LA Lighting CIT202-8-4L-L1RAFR-DRDM-UNV-2-840	0.900	6578	52.6944	474.25

**MP STRUCTURES**  
**RUTH POWELL, P.E., S. E.**



Title	
POTOMETRIC PLAN	
Drawn Author	Field Architecture
Verified Checker	Scale 1" = 20'-0"
Approved Approver	Date 07-17-24
Project Manager Jacob Wu	Dwg. no. Page
Project 23-805	A-802