


12/23/2024 11:21:55 AM



1 PHOTOMETRIC SITE PLAN

ESP-1 SCALE: 1" = 50'-0"

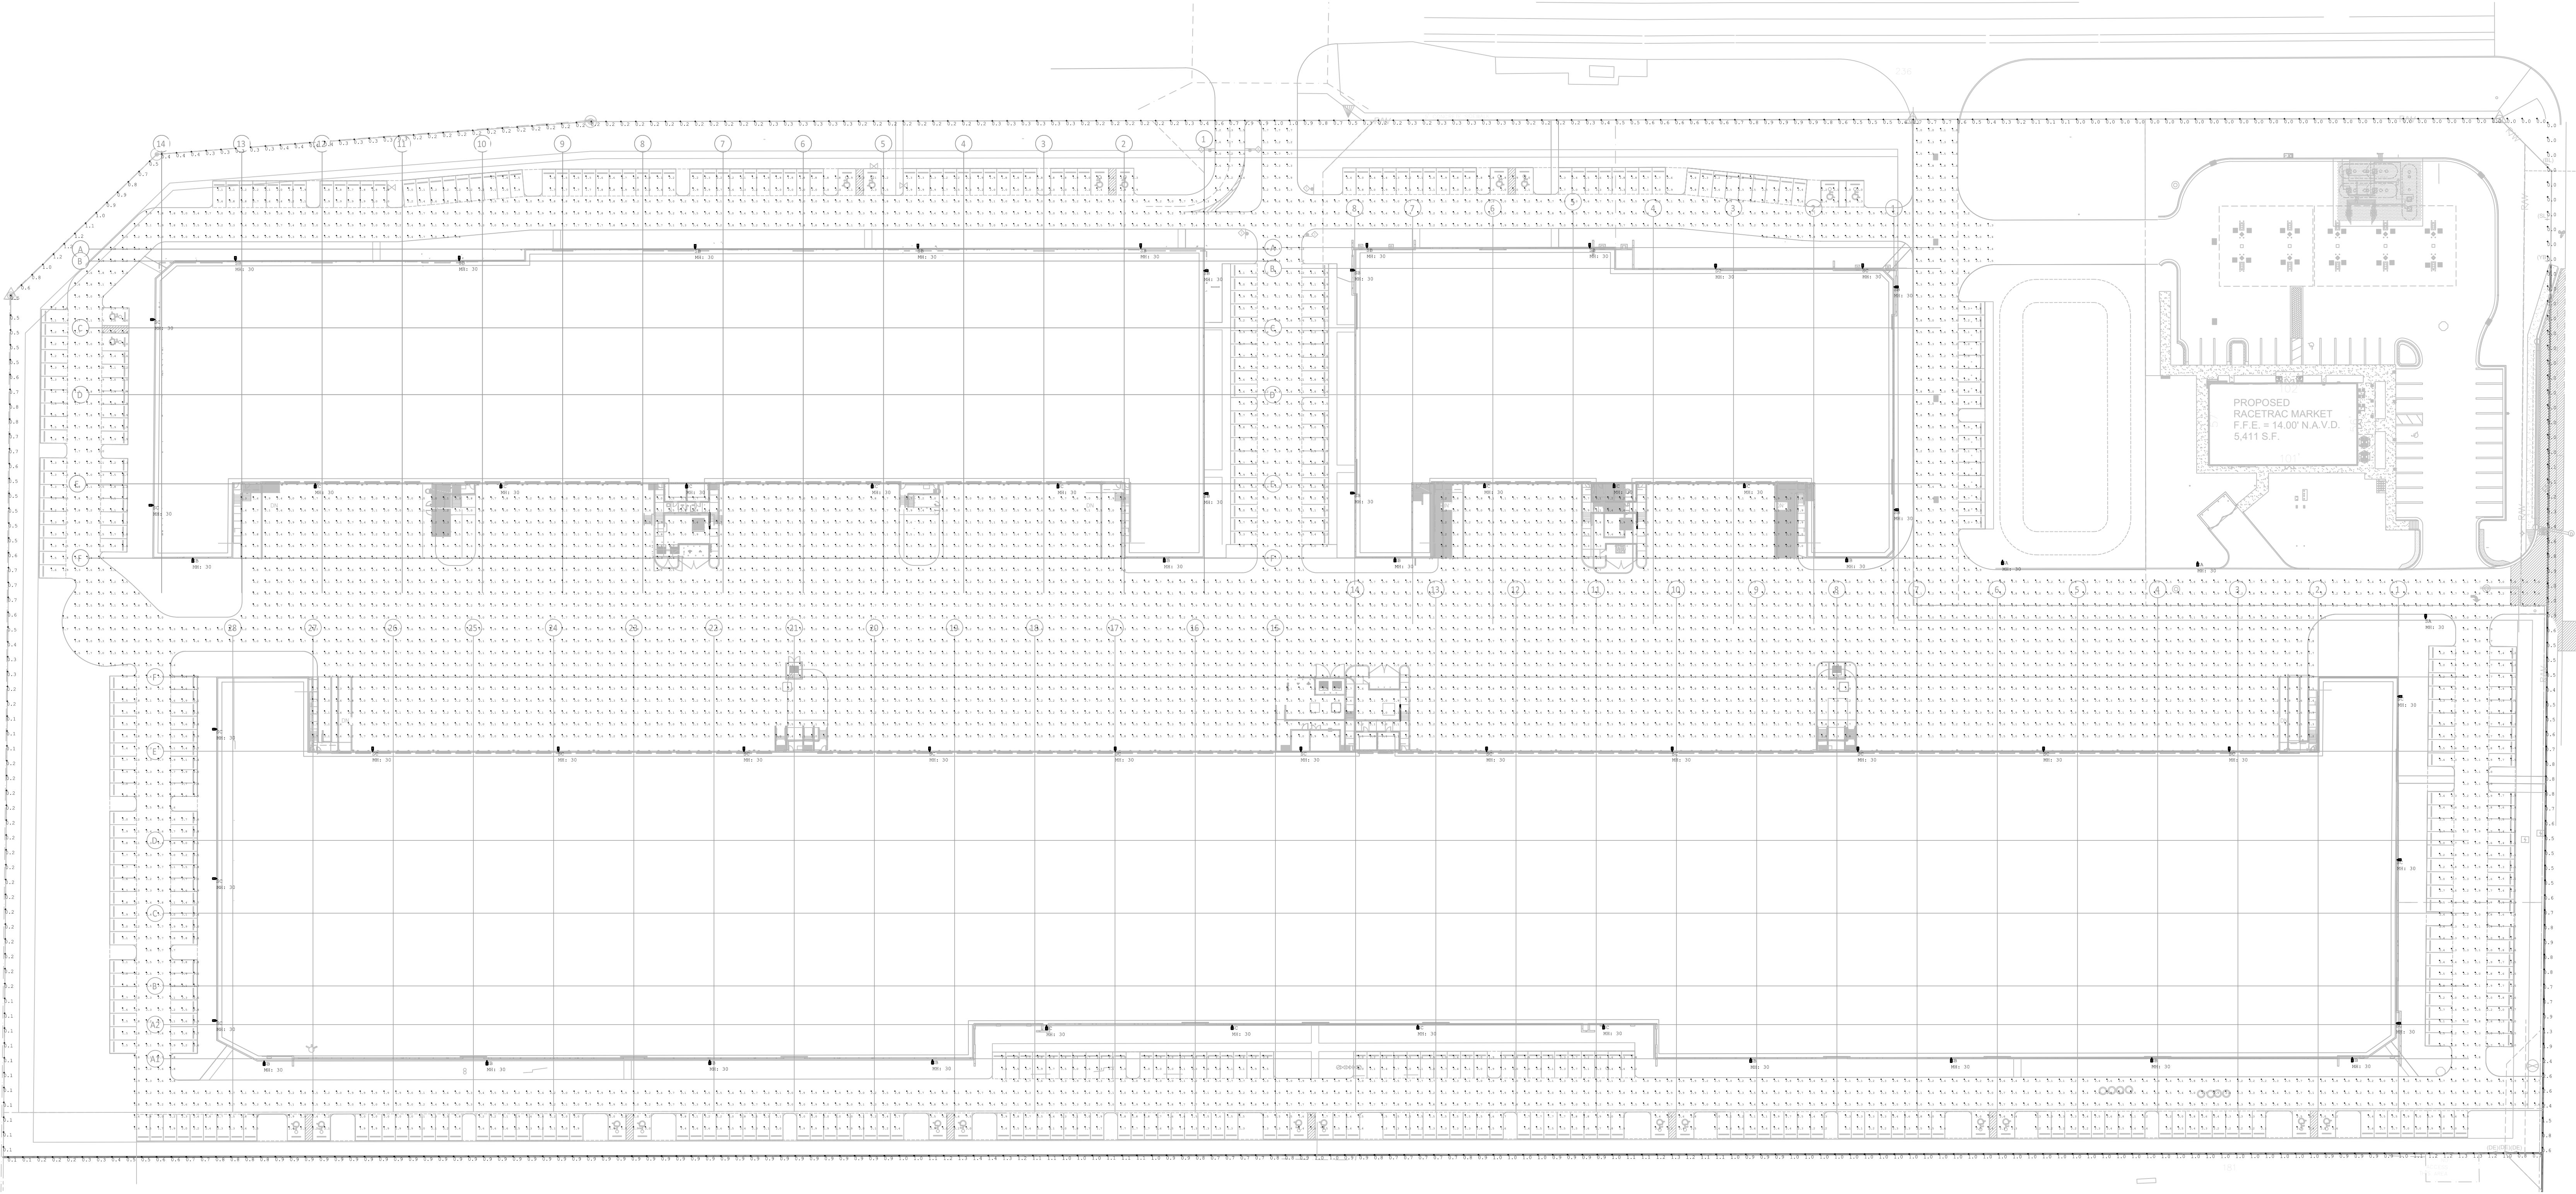

LUMINAIRE SCHEDULE										
SYMBOL	QTY	LABEL	ARRANGEMENT	MANUFACTURER	CATALOG NUMBER	MOUNTING	EMERGENCY	LLF	LUMINAIRE LUMENS	LUMINAIRE WATTS
	4	SA	Single	Lithonia Lighting	DSX1 LED P9 40K 70CRI T3M	POLE MOUNTED: 30' A.F.G.	N/A	0.900	34003	277.07
	33	SC	Single	Lithonia Lighting	DSX1 LED P9 40K 70CRI TFTM	WALL MOUNTED: 30' A.F.G.	N/A	0.900	34749	277.07
	26	SB	Single	Lithonia Lighting	DSX1 LED P9 40K 70CRI T3M	WALL MOUNTED: 30' A.F.G.	N/A	0.900	34003	277.07

CALCULATION SUMMARY										
LABEL	CALC TYPE	UNITS	SPACING L-R (FT)	SPACING T-B (FT)	HEIGHT (FT)	AVG	MAX	MIN	AVG/MIN	MAX/MIN
SITE	Illuminance	Fc	8	8	0	2.71	5.8	1.0	2.71	5.80
SPILL	Illuminance	Fc	10	N.A.	N.A.	0.58	2.6	0.0	N.A.	N.A.

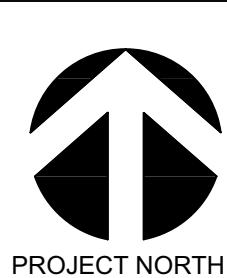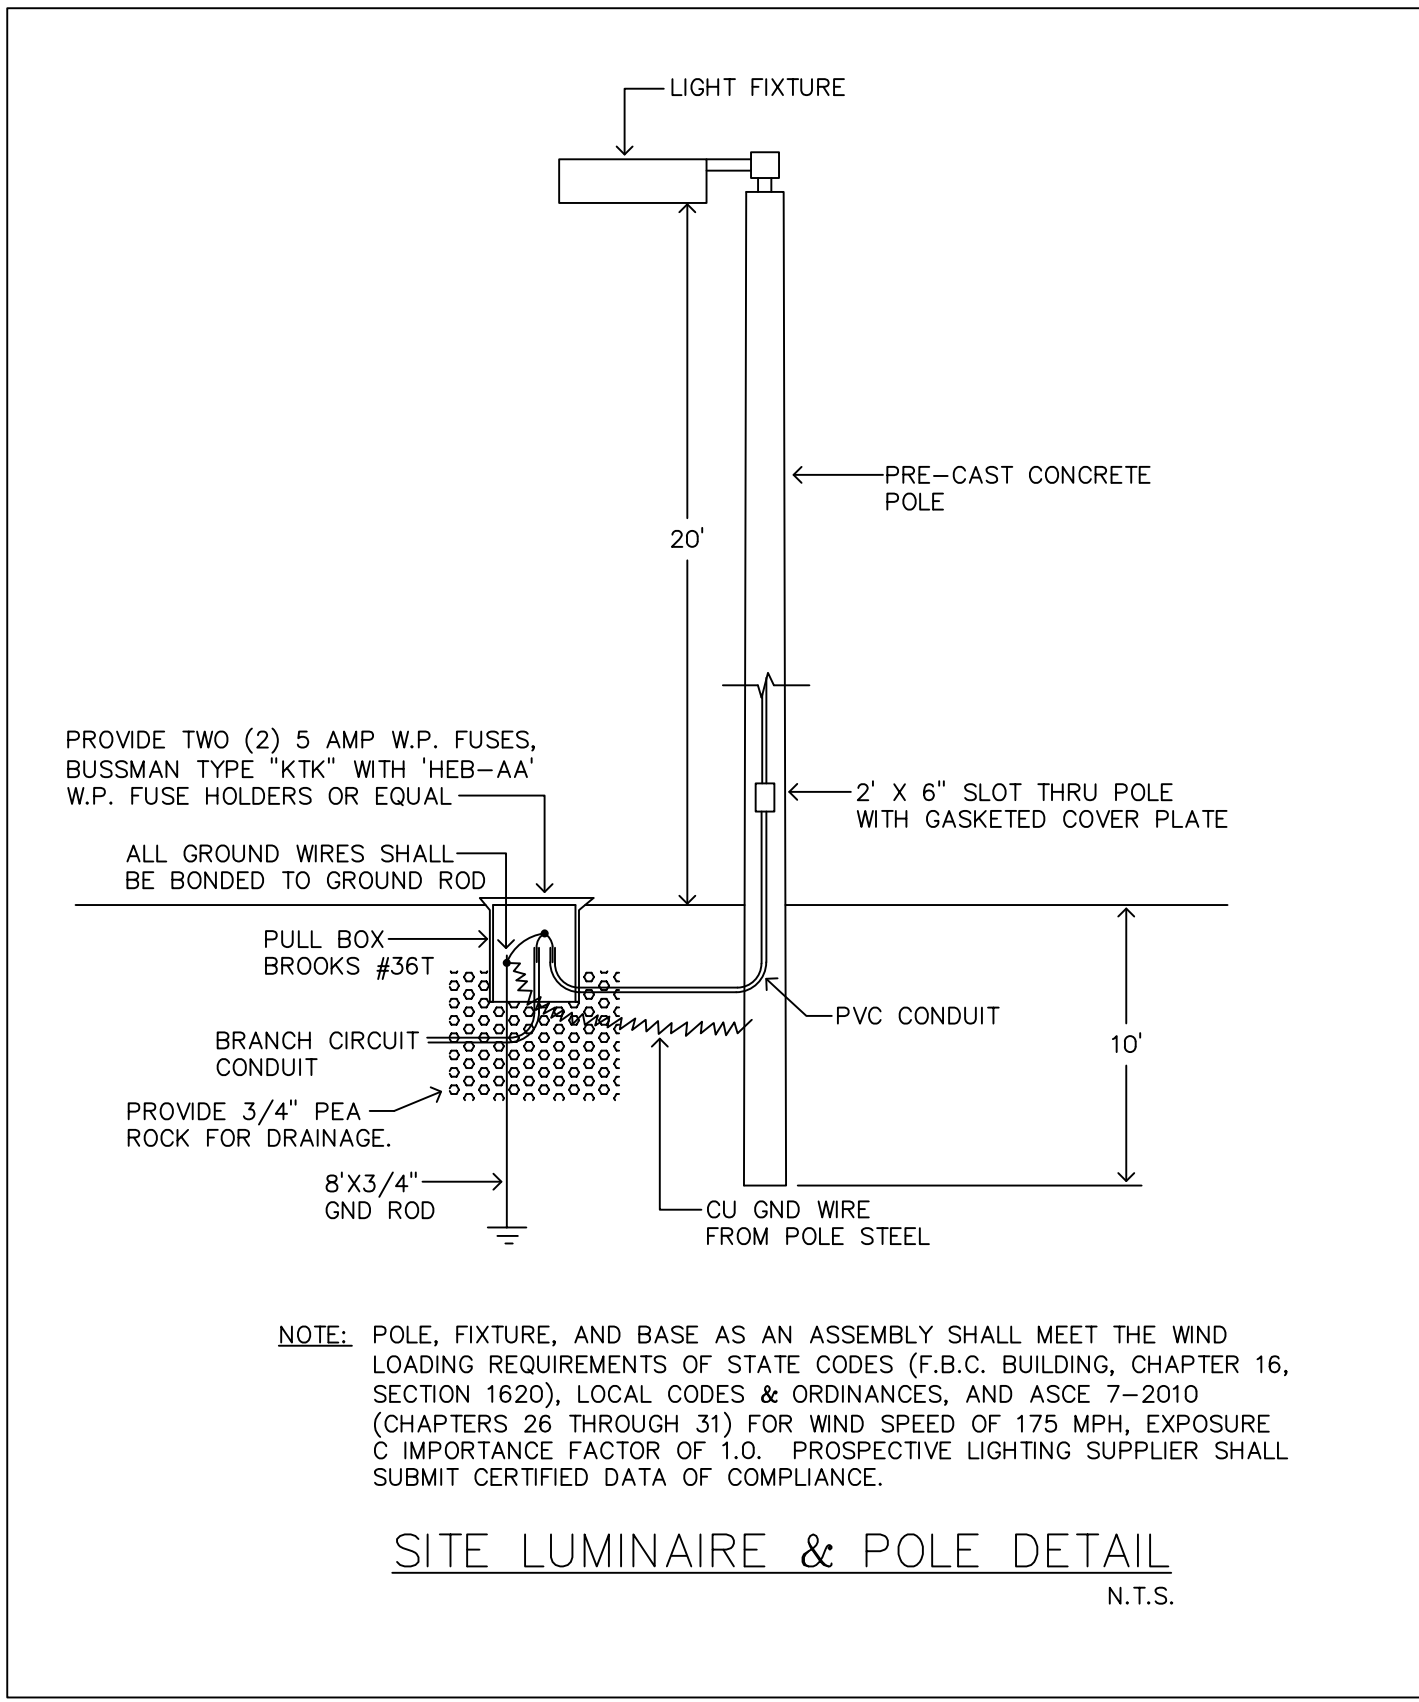

CLIENT  
FOUNDRY COMMERCIAL

**COPYRIGHT**  
This drawing has been prepared solely for the intended use, thus any reproduction or distribution for any purpose other than that authorized by Arcadis is forbidden. Written dimensions shall have precedence over scaled dimensions. Contractors shall verify and be responsible for all dimensions and conditions on the job, and Arcadis shall be informed of any variations from the dimensions and conditions shown on the drawing. Shop drawings shall be submitted to Arcadis for general conformance before proceeding with fabrication.

ISSUES		
No.	DESCRIPTION	DATE

CONSULTANTS




7000 N Federal Hwy - 2nd Floor  
Boca Raton FL 33487 USA  
tel 248 936 8000  
www.arcadis.com

SEAL



THIS ITEM HAS BEEN DIGITALLY SIGNED AND SEALED BY JUAN DAVID PUGA ON THE DATE ADJACENT TO THE SEAL. PRINTED COPIES OF THIS DOCUMENT ARE NOT CONSIDERED SIGNED AND SEALED AND THE SIGNATURE MUST BE VERIFIED ON ANY ELECTRONIC COPIES.

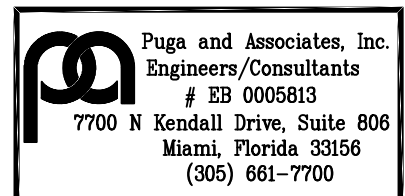

PROJECT  
FOUNDRY - FESTIVAL FLEA MARKET  
Pompano Beach, Florida

PROJECT NO: NEEDS PROJECT #	CHECKED BY: Checker
DRAWN BY: Author	APPROVED BY: Approver
PROJECT MGR: Designer	
2024/12/23	

SHEET TITLE  
PHOTOMETRIC SITE PLAN  
SHEET NUMBER  
E-120  
ISSUE

PZ24-12000024  
02/05/2025