


- LEGEND:**
- MONITORING WELL
 - DEEP MONITORING WELL
 - PROPOSED MONITORING WELL
 - ABANDONED/DESTROYED MONITORING WELL
 - WATER UTILITY
 - ELECTRICAL UTILITY
 - GAS UTILITY

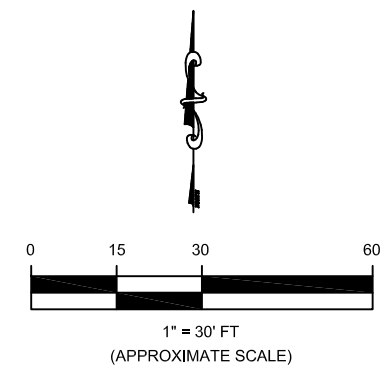

REV	DESCRIPTION OF REVISION	BY	DATE

HILLSBORO SHOPPING PLAZA
 2608 N. OCEAN BLVD.
 HILLSBORO BEACH, FLORIDA
 FDEP# 069101766

AECOM 4168 SOUTHPOINT PARKWAY SUITE 205 JACKSONVILLE, FLORIDA 32216 (904)-632-6983


SCALE 1" = 30'	DRAWN BY: CMP	DATE: 04/30/2024
CHECKED BY: RGR		

DRAWING FILE: SHELL 2608 HILLSBORO (MASTER)

SITE PLAN

PROJECT NUMBER 60705235
FIGURE NUMBER 1

MONITORING WELL TO BE INSTALLED VIA THE HOLLOW STEM AUGER METHOD. PRIOR TO WELL INSTALLATION ACTIVITIES A GROUND PENETRATING RADAR LOCATE (GPR) LOCATE WILL BE CONDUCTED. NEXT, THE BOREHOLE WILL BE VACCUUMED CLEARED TO APPROXIMATELY FIVE FEET BELOW LAND SURFACE (BLS).

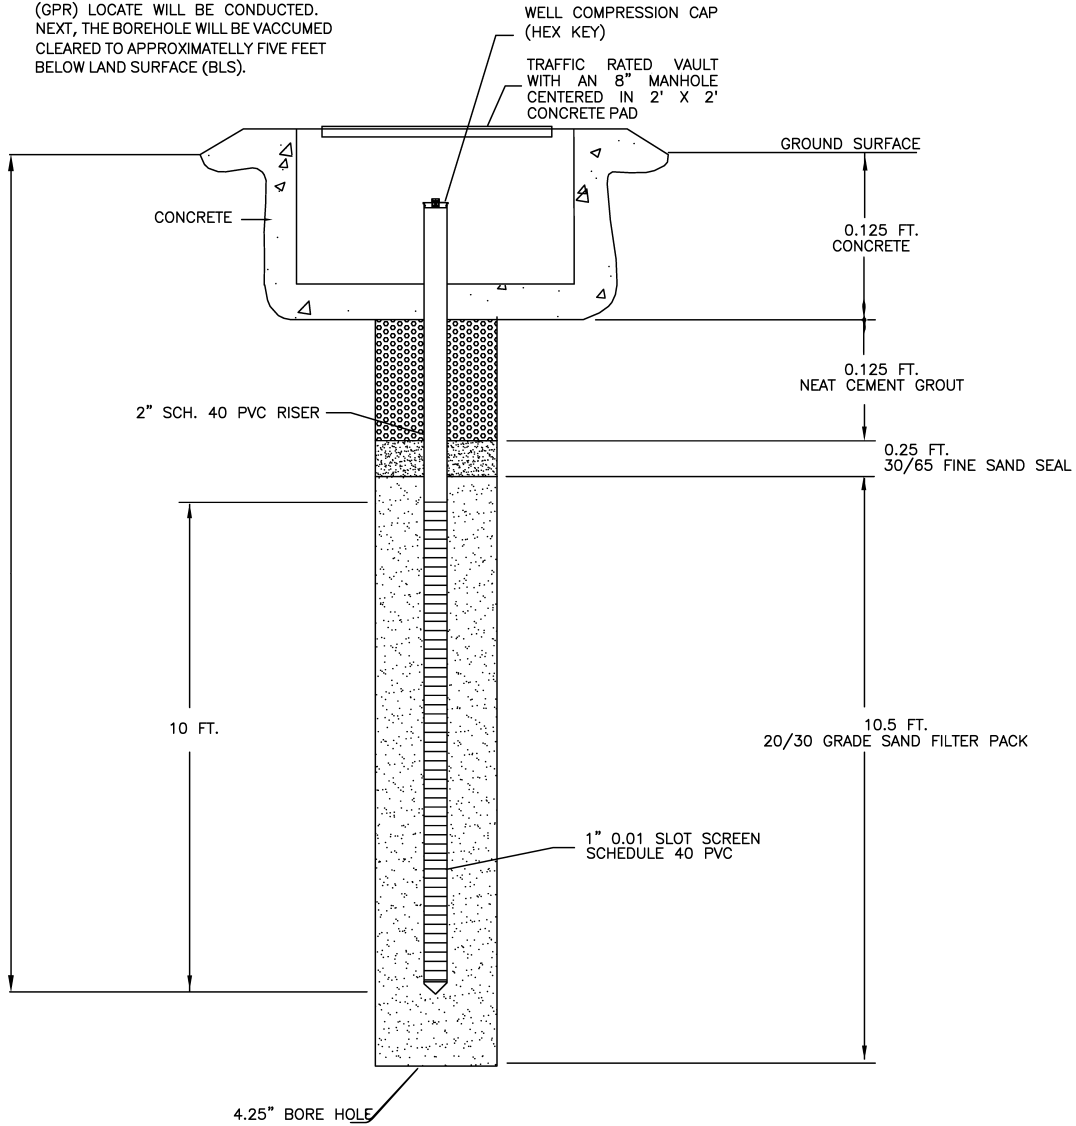

PROPOSED MONITORING WELL(S) CONSTRUCTION DETAILS
 NOT TO SCALE