



DRC

PZ25- 12000043
01/21/2026

A
B
C
D
E
F

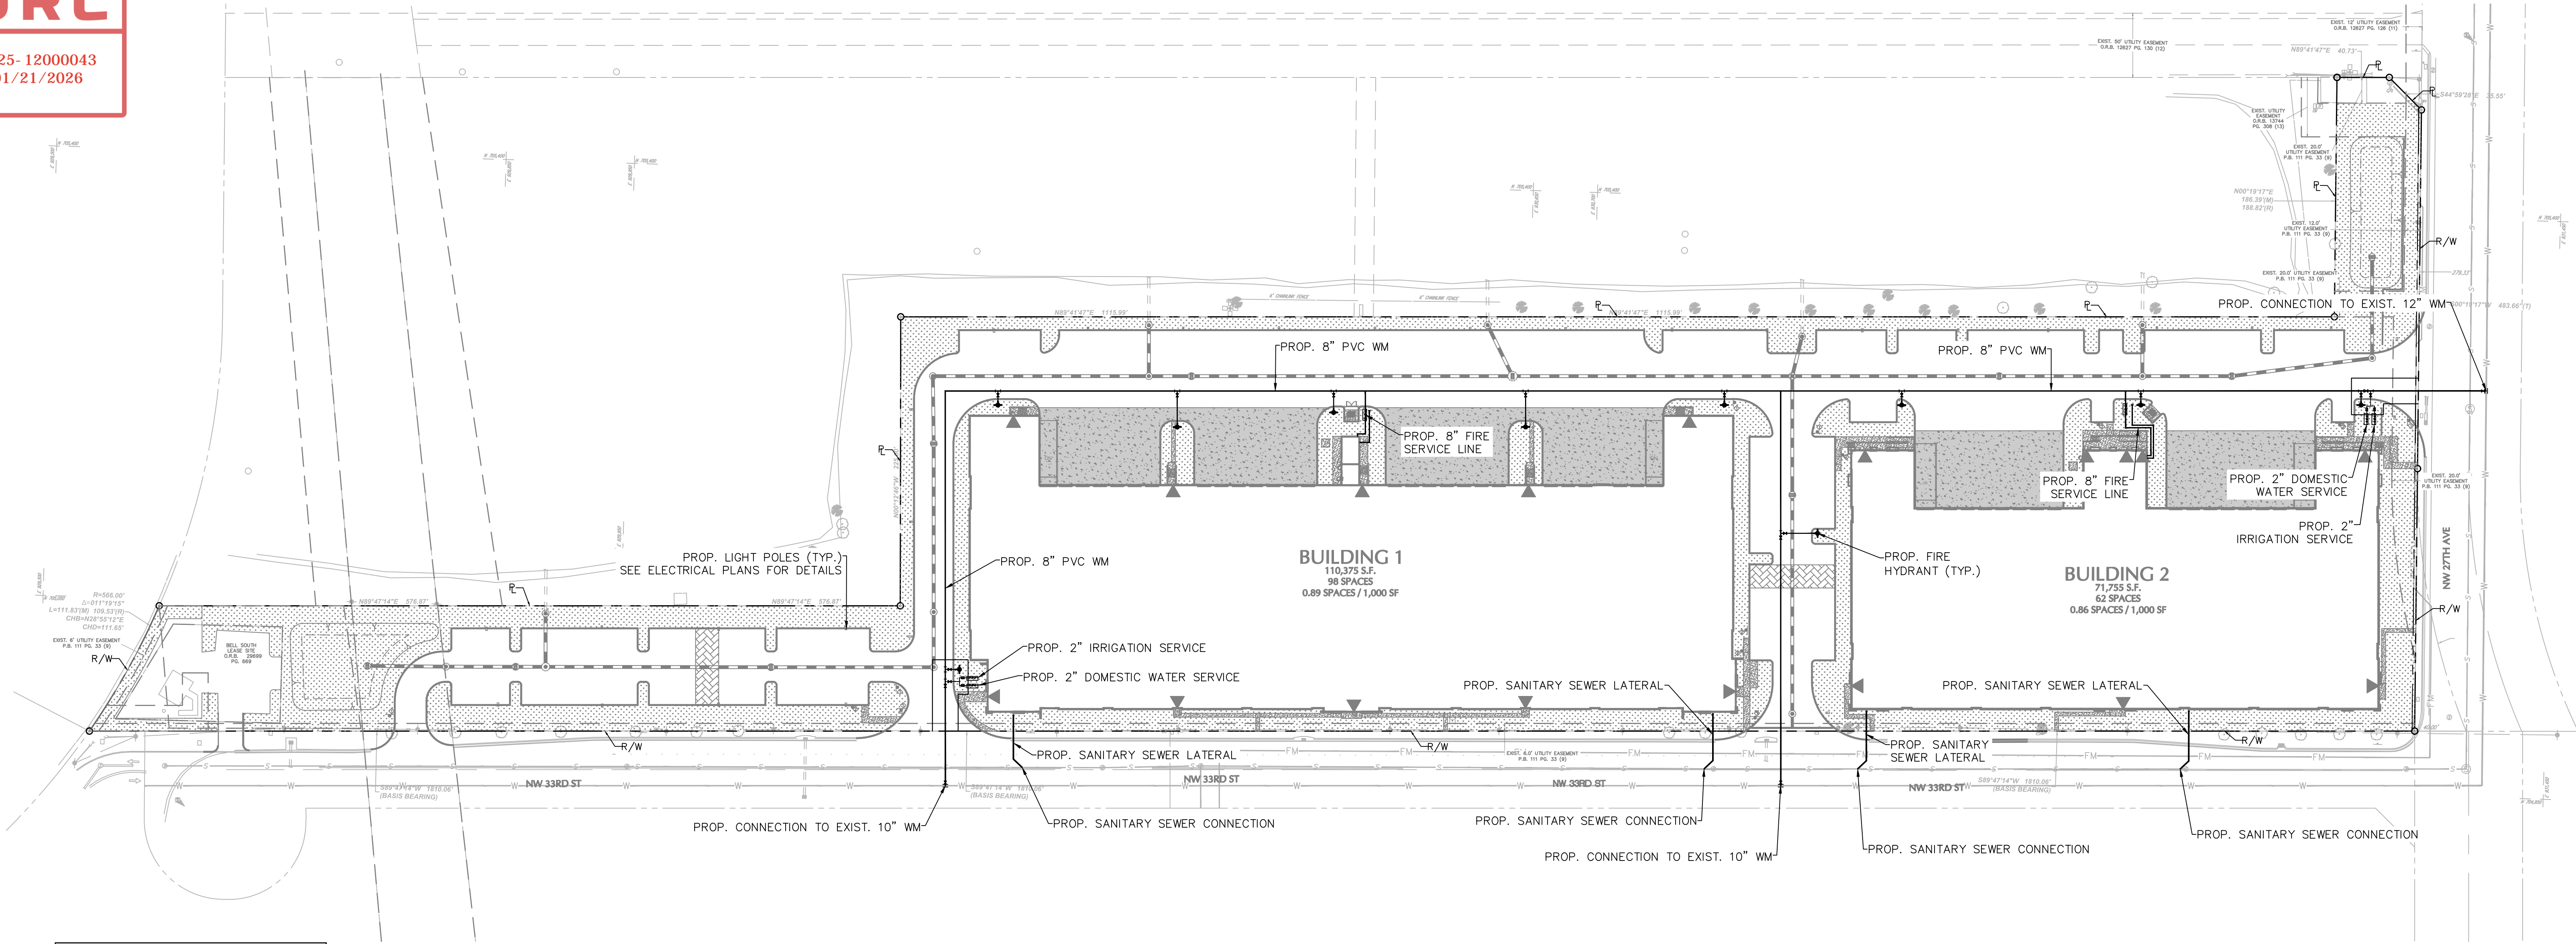

UTILITY LEGEND	
	FIRE HYDRANT
	BACKFLOW PREVENTER
	DOUBLE DETECTOR CHECK VALVE (DDCV)
	FIRE DEPT CONNECTION (FDC)
	METER BOX
	SANITARY SEWER MANHOLE
	SANITARY CLEANOUT
	PROPOSED WATER MAIN
	PROPOSED SEWER MAIN
	PROPOSED STORM PIPE
	EXISTING WATER MAIN
	EXISTING SEWER MAIN
	PROPOSED DRAINAGE MANHOLE
	PROPOSED CATCH BASIN
	UTILITY TO BE REMOVED

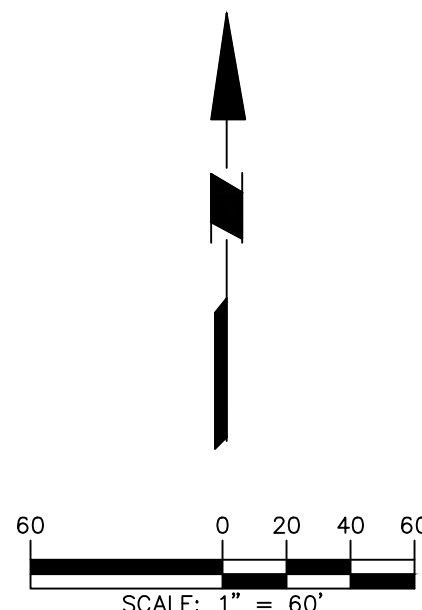

PROFESSIONAL ENGINEER
MICHAEL P. CARR
No. 72424
STATE OF FLORIDA
DATE SIGNED
MICHAEL CARR
PROFESSIONAL ENGINEER FL Lic. No. 72424

LANGAN
Langan Engineering and Environmental Services, LLC.
110 East Broward Boulevard, Suite 1500
Fort Lauderdale, FL 33301
T: 954.320.2100 F: 954.320.2101 www.langan.com
FBPE REGISTRY NO. 66011.B8172L.B8198

Project
FESTIVAL SOUTH
NW 33RD ST
POMPANO BEACH
BROWARD COUNTY FLORIDA
Drawing Title

OVERALL UTILITY PLAN
Project No. 330134202
Date DECEMBER 2025
Drawn By EWM
Checked By CL
Drawing No. C-2.0

Date	Description	No.
Revisions		