


Luminaire Schedule				
Symbol	Qty	Label	Arrangement	Description
•	-	A	Single	Cree Lighting ZR22-30L-840-AR-UNV-10V5
•	-	AE	Single	Cree Lighting ZR22-30L-840-AR-UNV-10V5-EB
•	-	B	Single	Utopia Lighting LHB-4G-260LED-2T-UNV (210W, 4000K)
•	-	BE	Single	Utopia Lighting LHB-4G-260LED-2T-UNV-EMG25 (210W, 4000K)

Luminaire Schedule			
Symbol	TYPE	Label	MOUNTING
□	A1	LITHONIA AFN-WL (OR EQUAL) W/ 90 MINUTE EMERGENCY BATTERY PACK	WALL

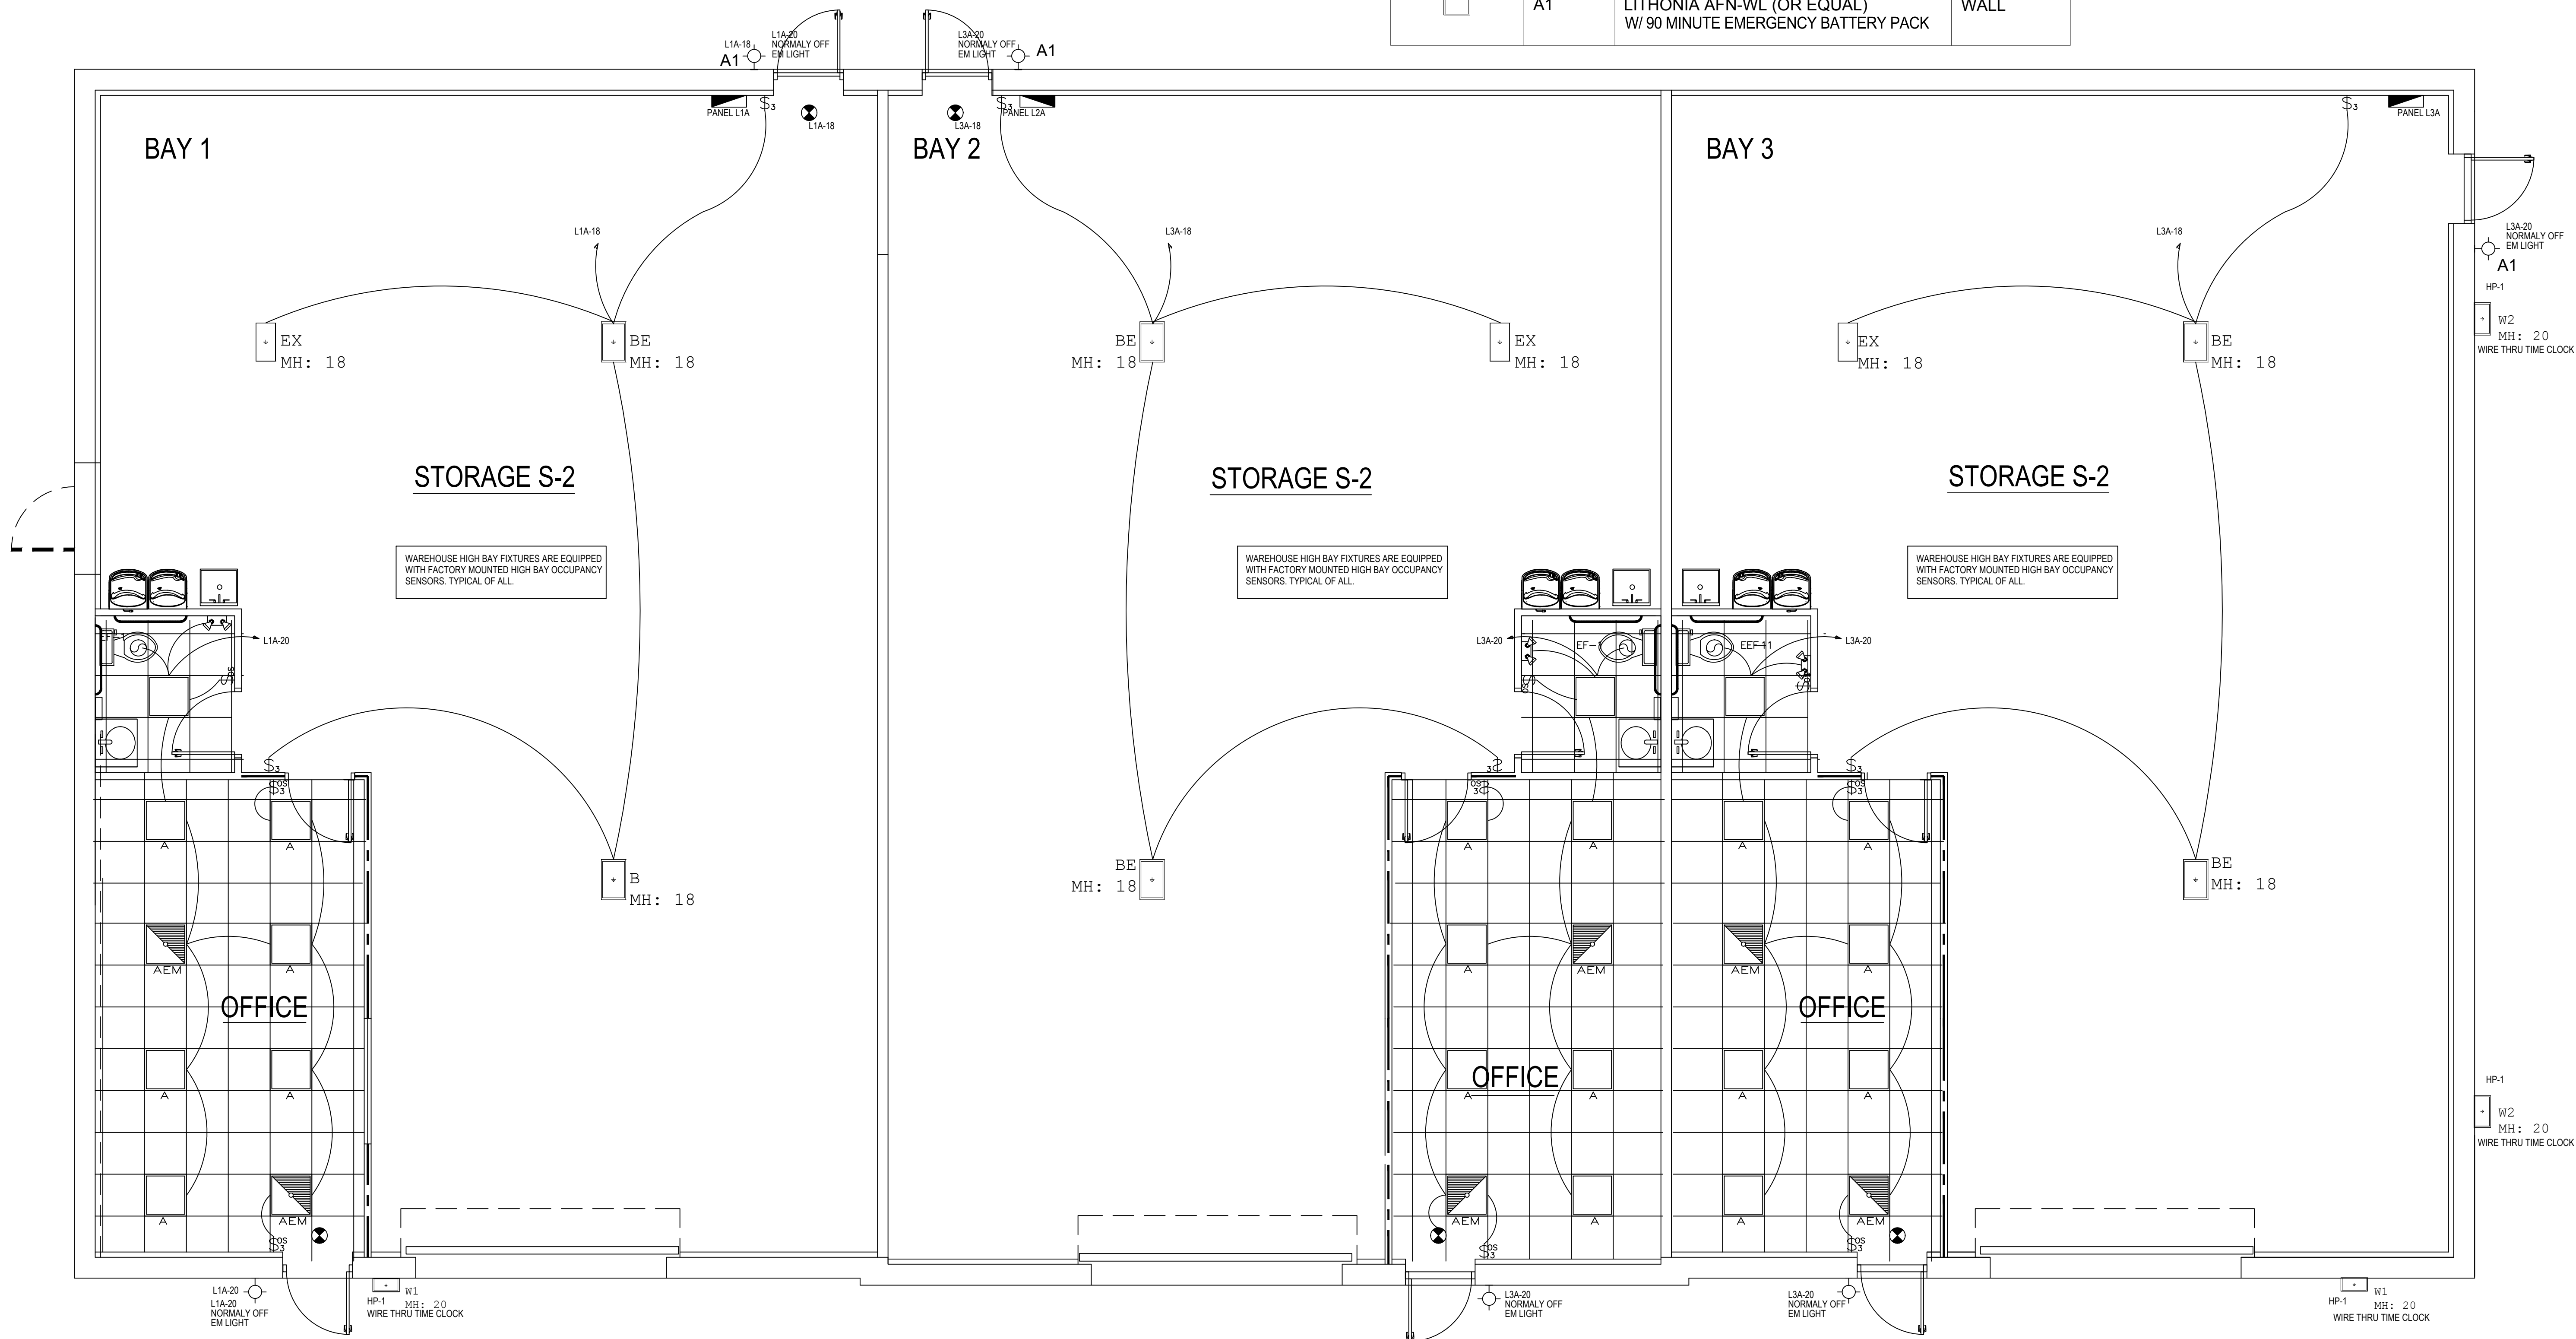

REVISIONS	BY

MIKAH J. ABBOTT
STATE OF FLORIDA
FE# 98054

1859 S. DIXIE HWY
POMPANO BEACH, FL 33060
(205) 360-3582

ELECTRICAL PLANS FOR:
1150 SW 30TH AVE.
POMPANO BEACH, FL 33069

EVERYTHING ENERGY INC.
1859 S. DIXIE HWY.
POMPANO BEACH, FLORIDA
EMAIL: autocal587@hotmail.com
PHONE: (561) 334-3170
(954) 776-2003

Drawn By: N.R.
Checked By: M.J.A.
MIKAH ABBOTT
1859 S. DIXIE HWY
POMPANO BEACH FL
PHONE: 561-334-3170
EMAIL: autocal587@hotmail.com
DATE: 11-12-25
SCALE: 1/4"
PROJECT:
1150 SW 30TH AVE.

SHEET
E-2
20F4_PAGES

PROPOSED LIGHTING FLOOR PLAN

1/4" = 1'