




PZ24-12000020
12/03/2025

Calculation Summary

Label	CalcType	Units	Avg	Max	Min	Avg/Min	Max/Min
Marina Parking	Illuminance	Fc	2.67	5.4	1.0	2.67	5.40
New Sidewalk	Illuminance	Fc	3.10	7.8	1.0	3.10	7.80
Parking Lot	Illuminance	Fc	2.21	4.7	1.0	2.21	4.70
Property Line	Illuminance	Fc	0.48	2.7	0.0	N.A.	N.A.

Luminaire Schedule

Symbol	Qty	Label	Arrangement	Description	LLF	Luminaire Lumens	Luminaire Watts	Total Watts
WA	3	WA	Single	Xtra Light VNTW-15000L-40K-DIM-4M-XX	0.900	3329	19.3	57.9
SA	5	SA	Single	Xtra Light VNTS-15000L-40K-DIM-4M-N-XX-XX-HSS	0.900	10366	109	545
WB	2	WB	Single	Xtra Light VNTW-15000L-40K-DIM-4M-XX	0.900	14969	106	212

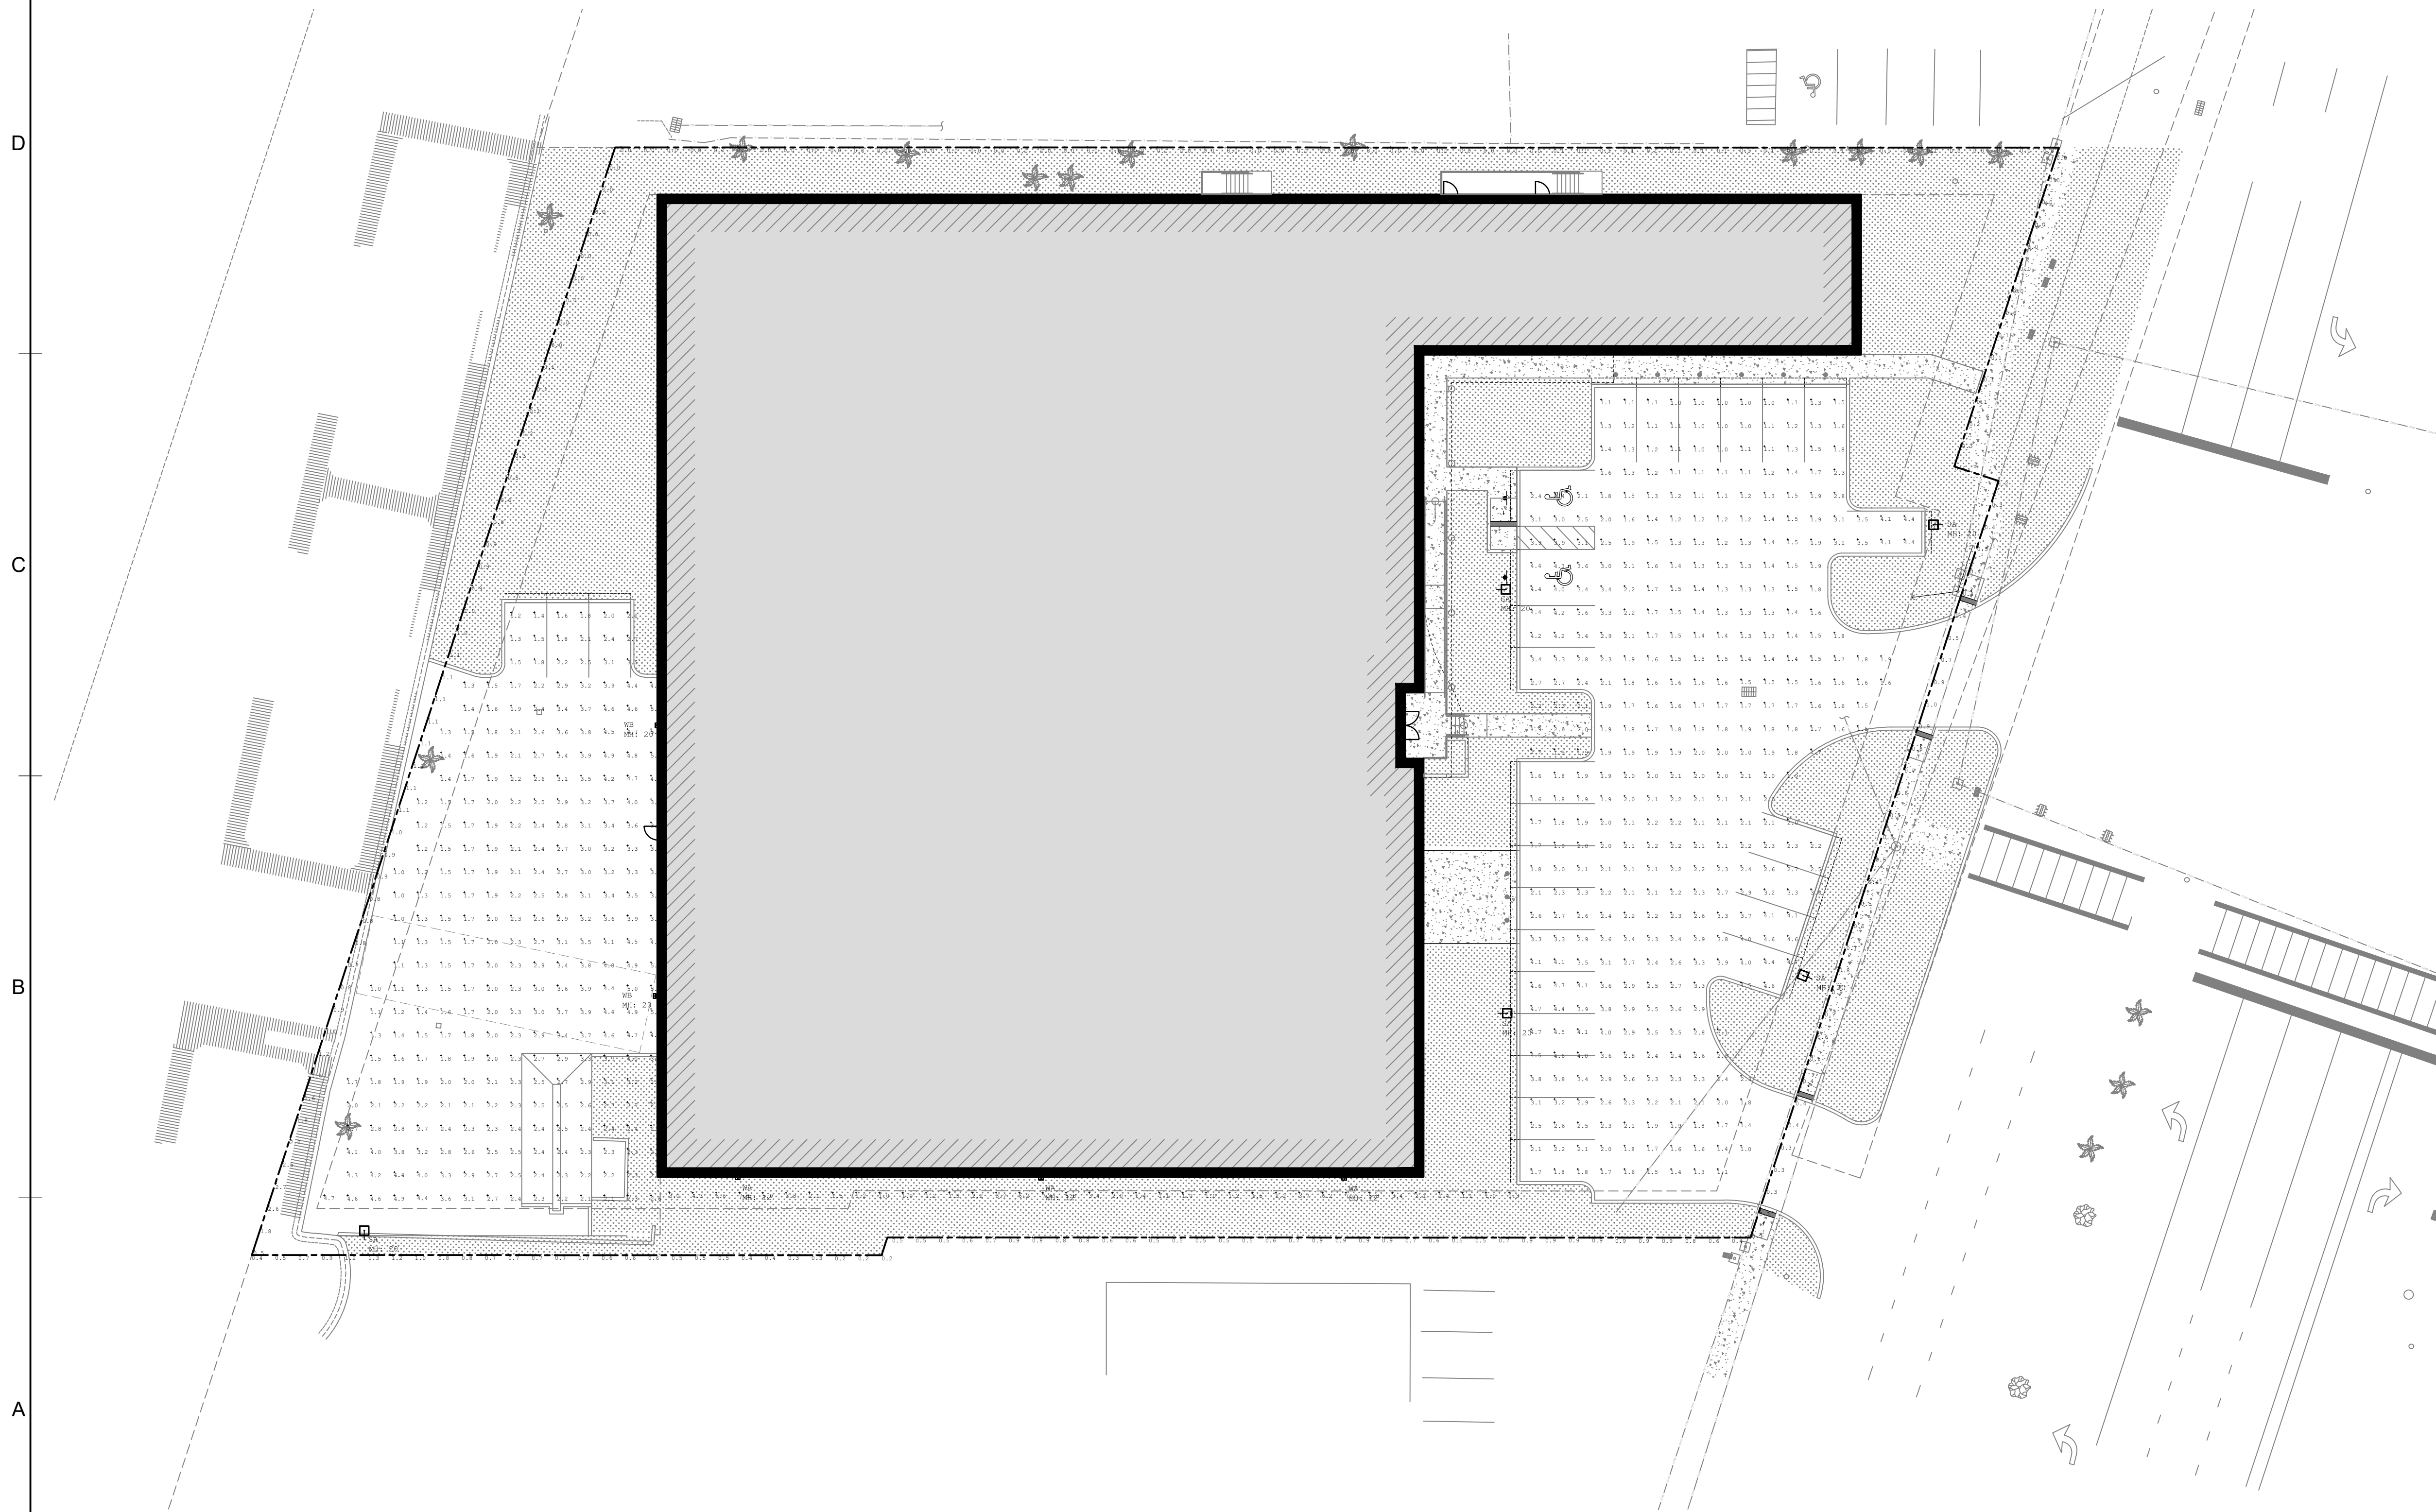


A1 PHOTOMETRIC PLAN
1" = 20'-0"



PZ24-12000020
03/18/2026

PROPOSED SITE IMPROVEMENTS FOR:
POMPANO BEACH MARINE CENTER

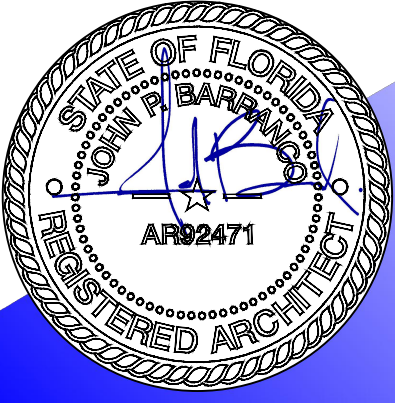

701 FEDERAL HIGHWAY POMPANO BEACH, FL 33062
barranco gonzalez • architecture • planning • interior design
phone: (954) 961-7685 fax: (954) 961-7675
1915 southeast 4th avenue Fort Lauderdale, FL 33316
mail@bgarchitecture.com

DESIGNED	DRAWN	CHECKED
JPB	JO/SRS	JPB
DATE:	DATE:	DATE:
06.27.2025	06.27.2025	06.27.2025

this document or parts thereof may not be reproduced in any form without permission copyrighted material ©

REVISIONS

PHOTOMETRIC PLAN

DESIGN DEVELOPMENT

AS-102

A6 NOT USED