


NOTE:
EXTERIOR LIGHTING
SIGNAGE
PARKING LOT LIGHTING
TO BE DUSK TO DAWN

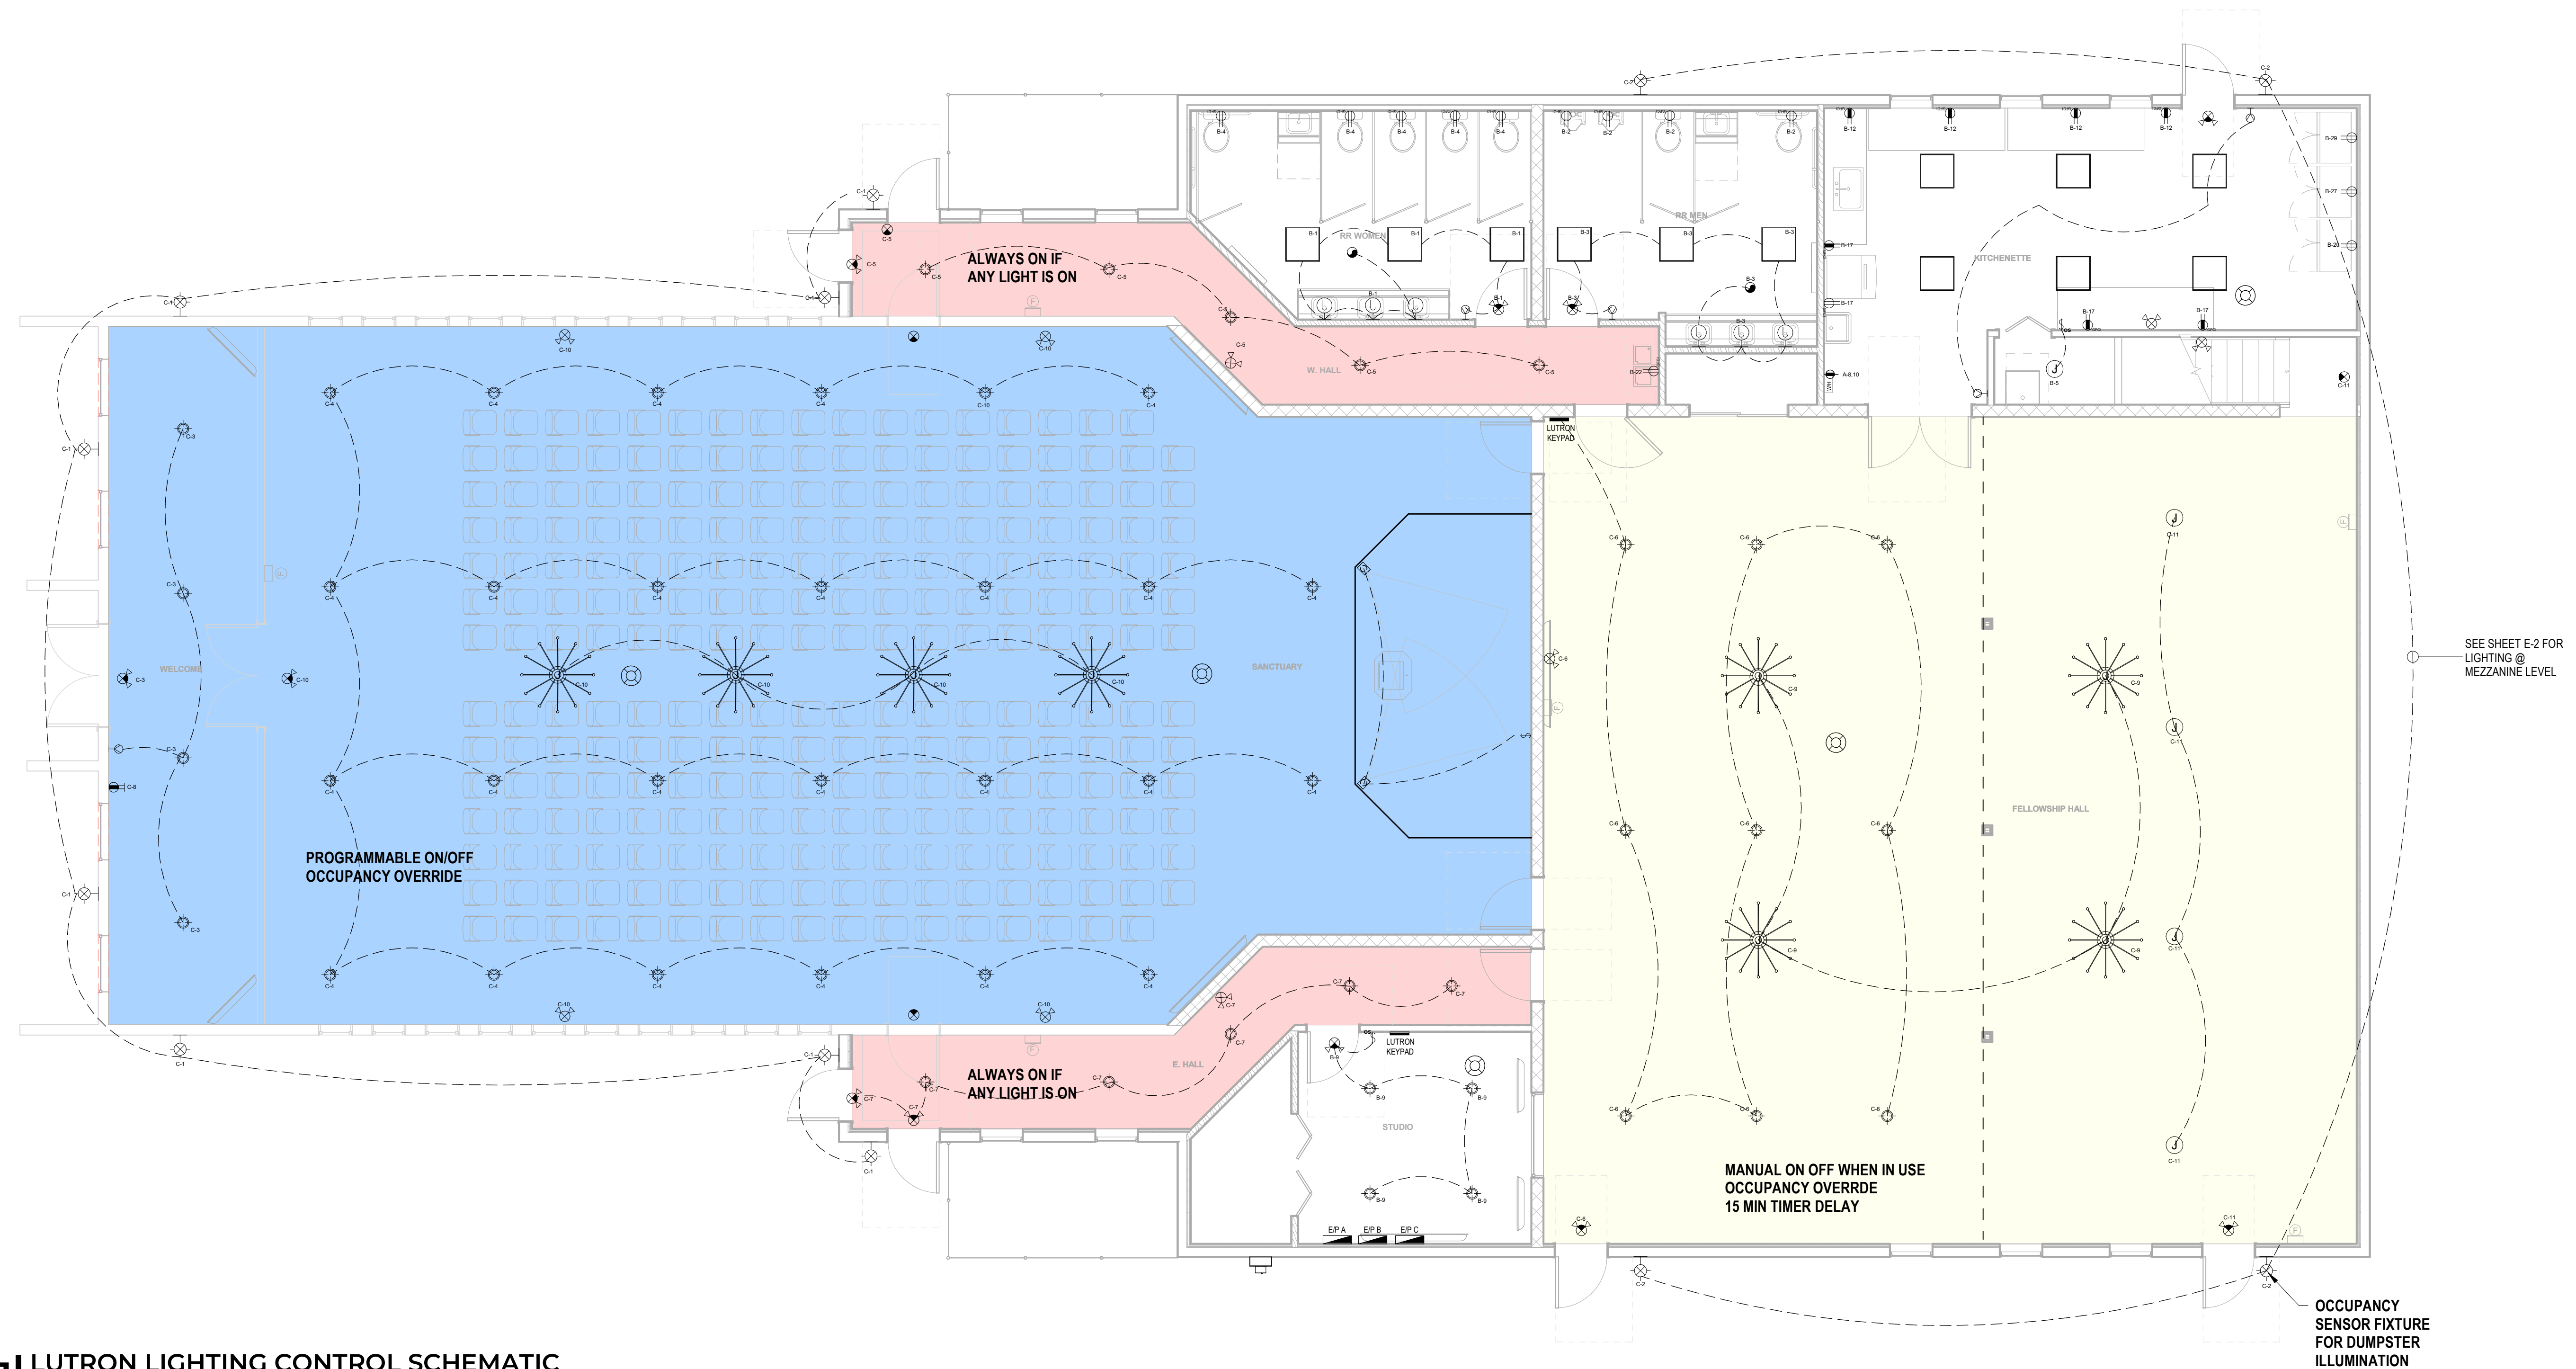


SEE SHEET E-2 FOR
— LIGHTING @
MEZZANINE LEVEL

OCCUPANCY SENSOR FIXTURE FOR DUMPSTER ILLUMINATION



AJOKU STUDIOS
550 S RAINBOW DR,
HOLLYWOOD, FL 33021
NFO@AJOKUSTUDIOS.COM
(561) 384-3923

THIS ITEM HAS BEEN DIGITALLY SIGNED AND
SEALED BY RAFAEL BALLESTER ON THE DATE
ADJACENT TO THE SEAL SIGNATURE
MUST BE VERIFIED ON ANY ELECTRONIC COPIES.

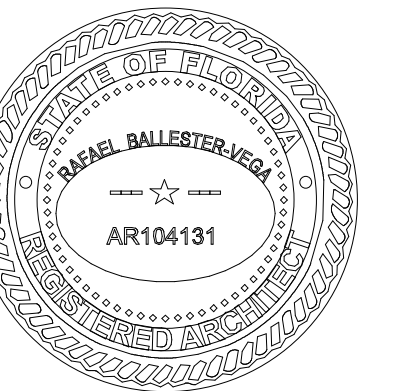

DRAWING INFO

DATE: 11/25/2025

SCALE: As indicated

DRAWN BY: I.A.A.

CHECKED BY: I.A.A.

APPROVED BY: R.B.V.

CONTRACT NO.: CD241610

IN MY PROFESSIONAL JUDGEMENT AND TO THE BEST OF MY KNOWLEDGE AND BELIEF, THESE PLANS AND SPECIFICATIONS COMPLY WITH APPLICABLE BUILDING CODES AND FIRESAFETY CODES, AS MANDATE BY STATUTE, FOR THE JURISDICTION IN WHICH THE STRUCTURE CONTAINED IN THESE DOCUMENTS SHALL BE CONSTRUCTED.

REVISIONS


**EBENEZER SDA
CHURCH**
1210 NW 27TH AVE.
POMPANO BEACH, FL 33069

OWNER
SOUTHEASTERN ASSOC. OF
SEVENTH-DAY ADVANTISTS

TITLE
LIGHTING CONTROL PLAN

LV-2

ELECTRICAL LEGEND

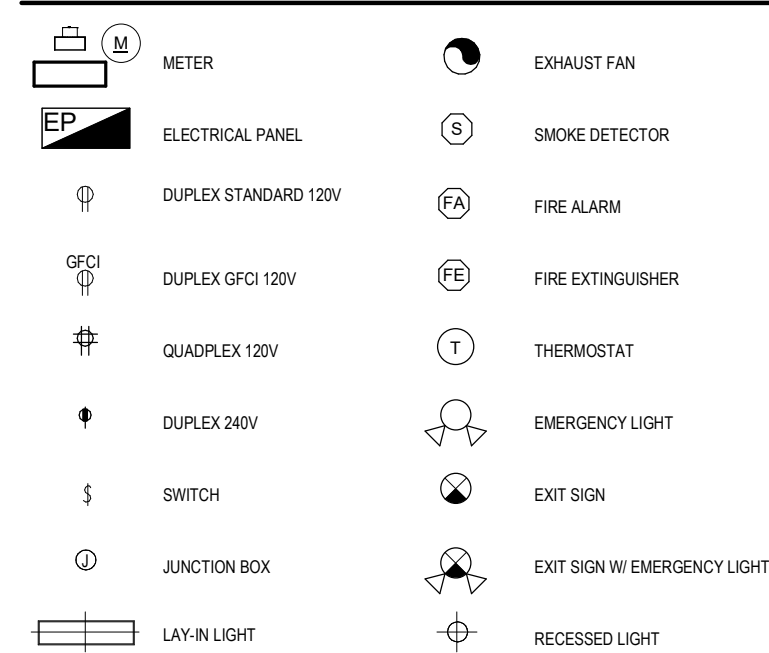

N=NEW

E=EXISTING

* NOTES:

- LIGHTING SYSTEM TO BE DESIGNED BY LUTRON SPECIALIST THROUGH CENTRAL LUTRON CONTROL PANEL LOCATED @ "STUDIO"

