




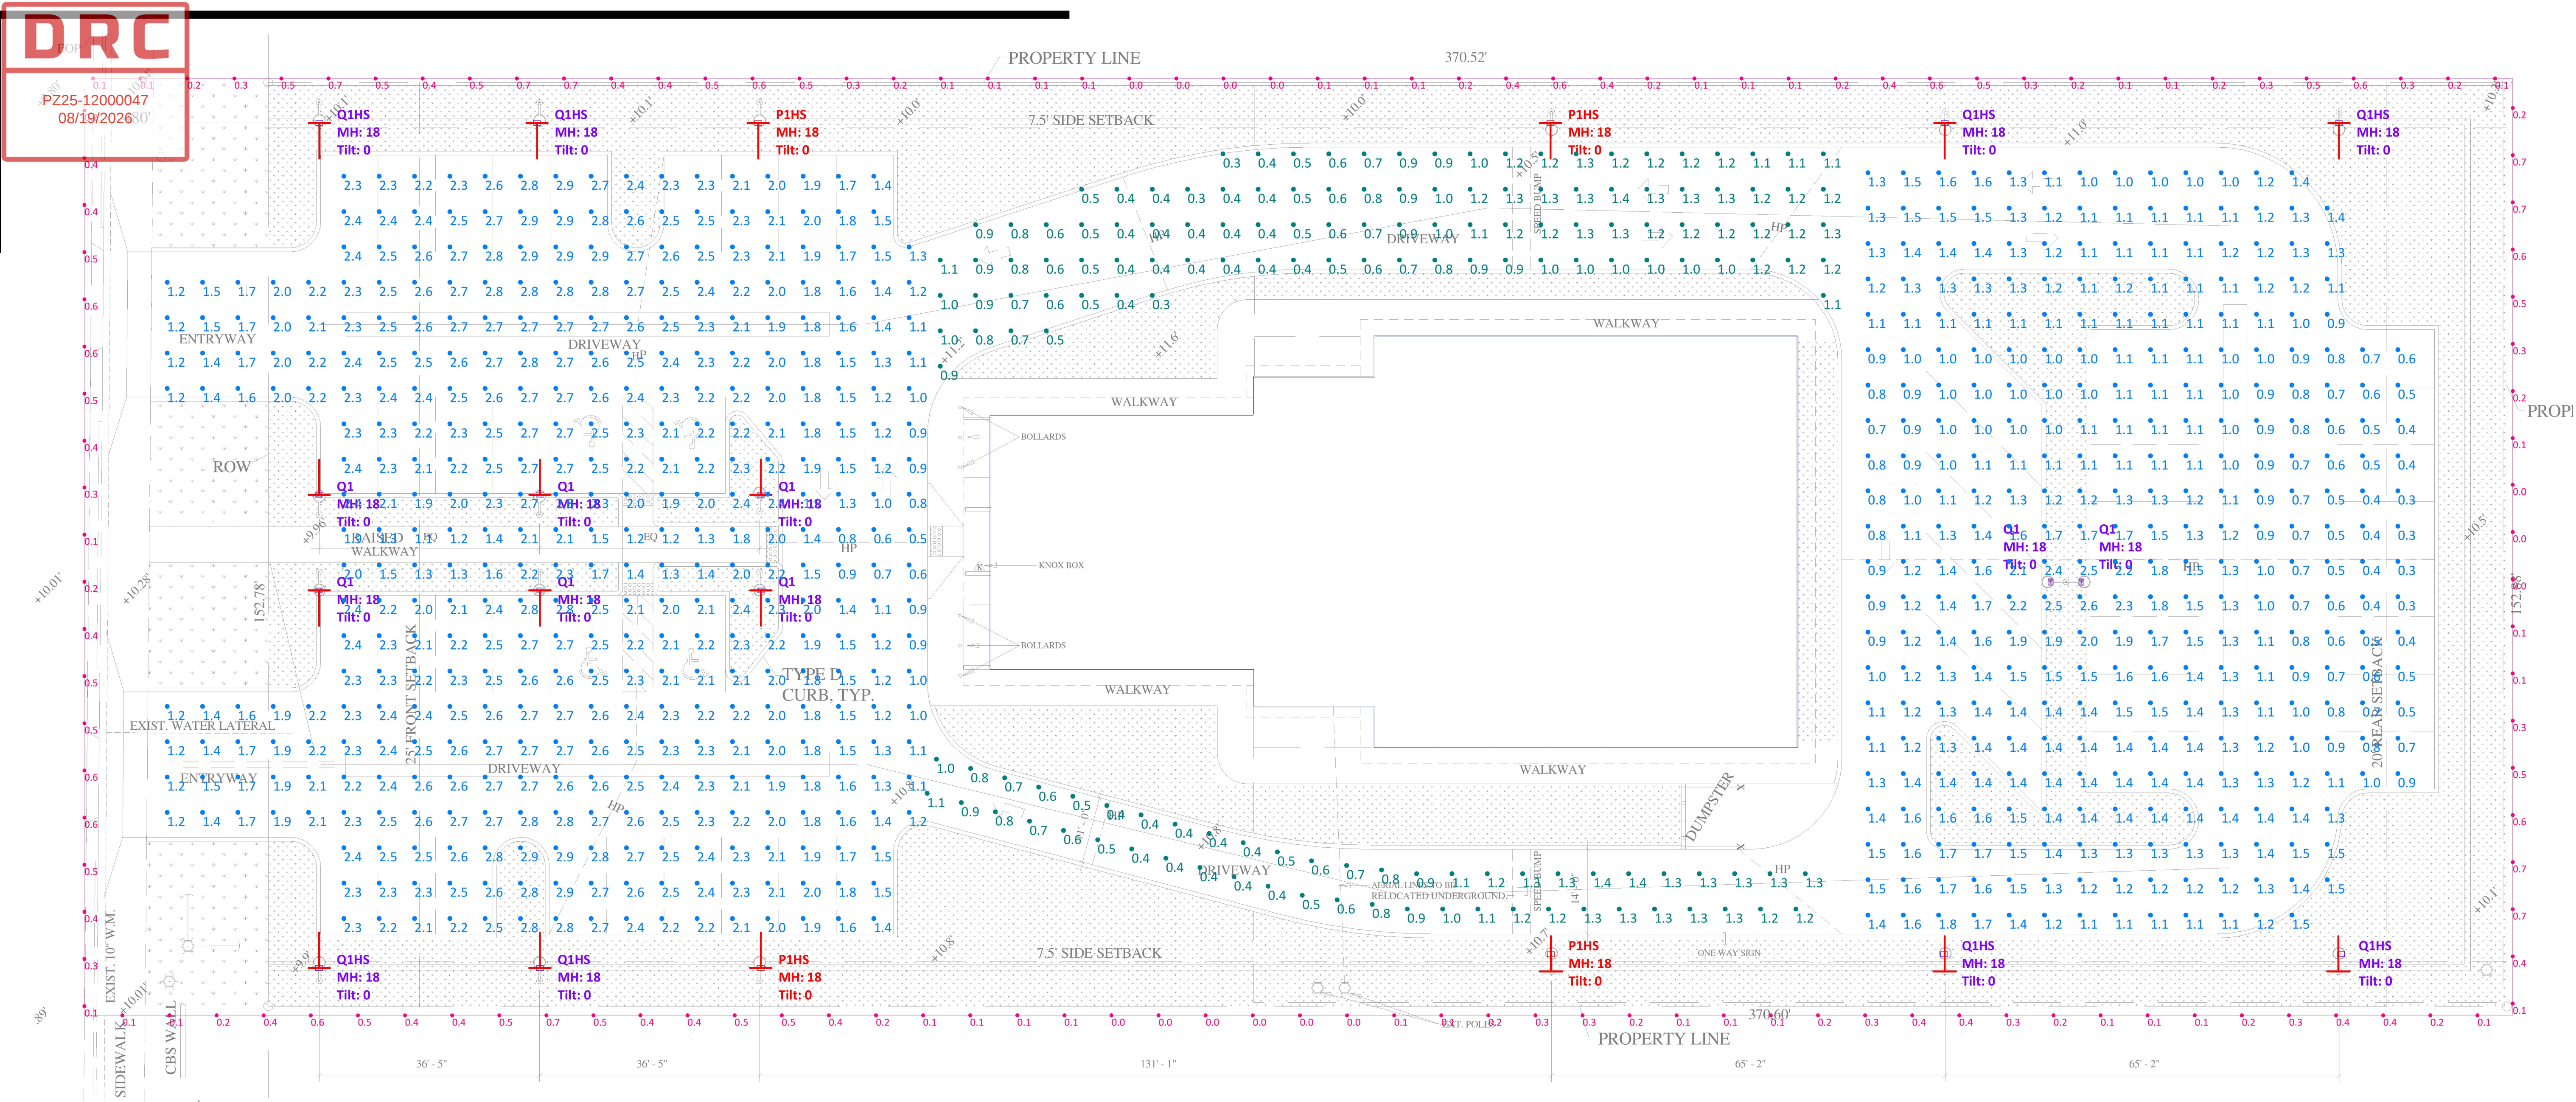


Calculation Summary

Label	Units	Avg	Max	Min	Max/Min	Avg/Min	Max/Avg
Driveway 1	Fc	0.9	1.4	0.3	4.67	2.83	1.65
Driveway 2	Fc	0.9	1.4	0.4	3.50	2.23	1.57
Parking lot - Front	Fc	2.1	2.9	0.5	5.80	4.20	1.38
Parking lot - Rear	Fc	1.2	2.6	0.3	8.67	3.97	2.18
Property boundary spill at 5ft AFL	Fc	N.A.	0.7	0.0	N.A.	N.A.	N.A.

Luminaire Schedule

Label	Symbol	Description	Lumens	Watts	LLF	Qty
P1HS		DSX0 LED P1 40K 70CRI T2M HS	4109	33.21	0.900	4
Q1HS		DSX0 LED P1 40K 70CRI T4M HS	4183	33.21	0.900	8
Q1		DSX0 LED P1 40K 70CRI T4M	4862	33.21	0.900	8

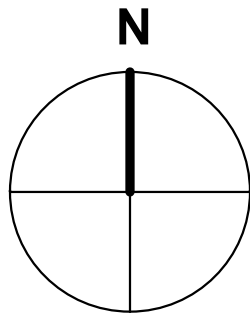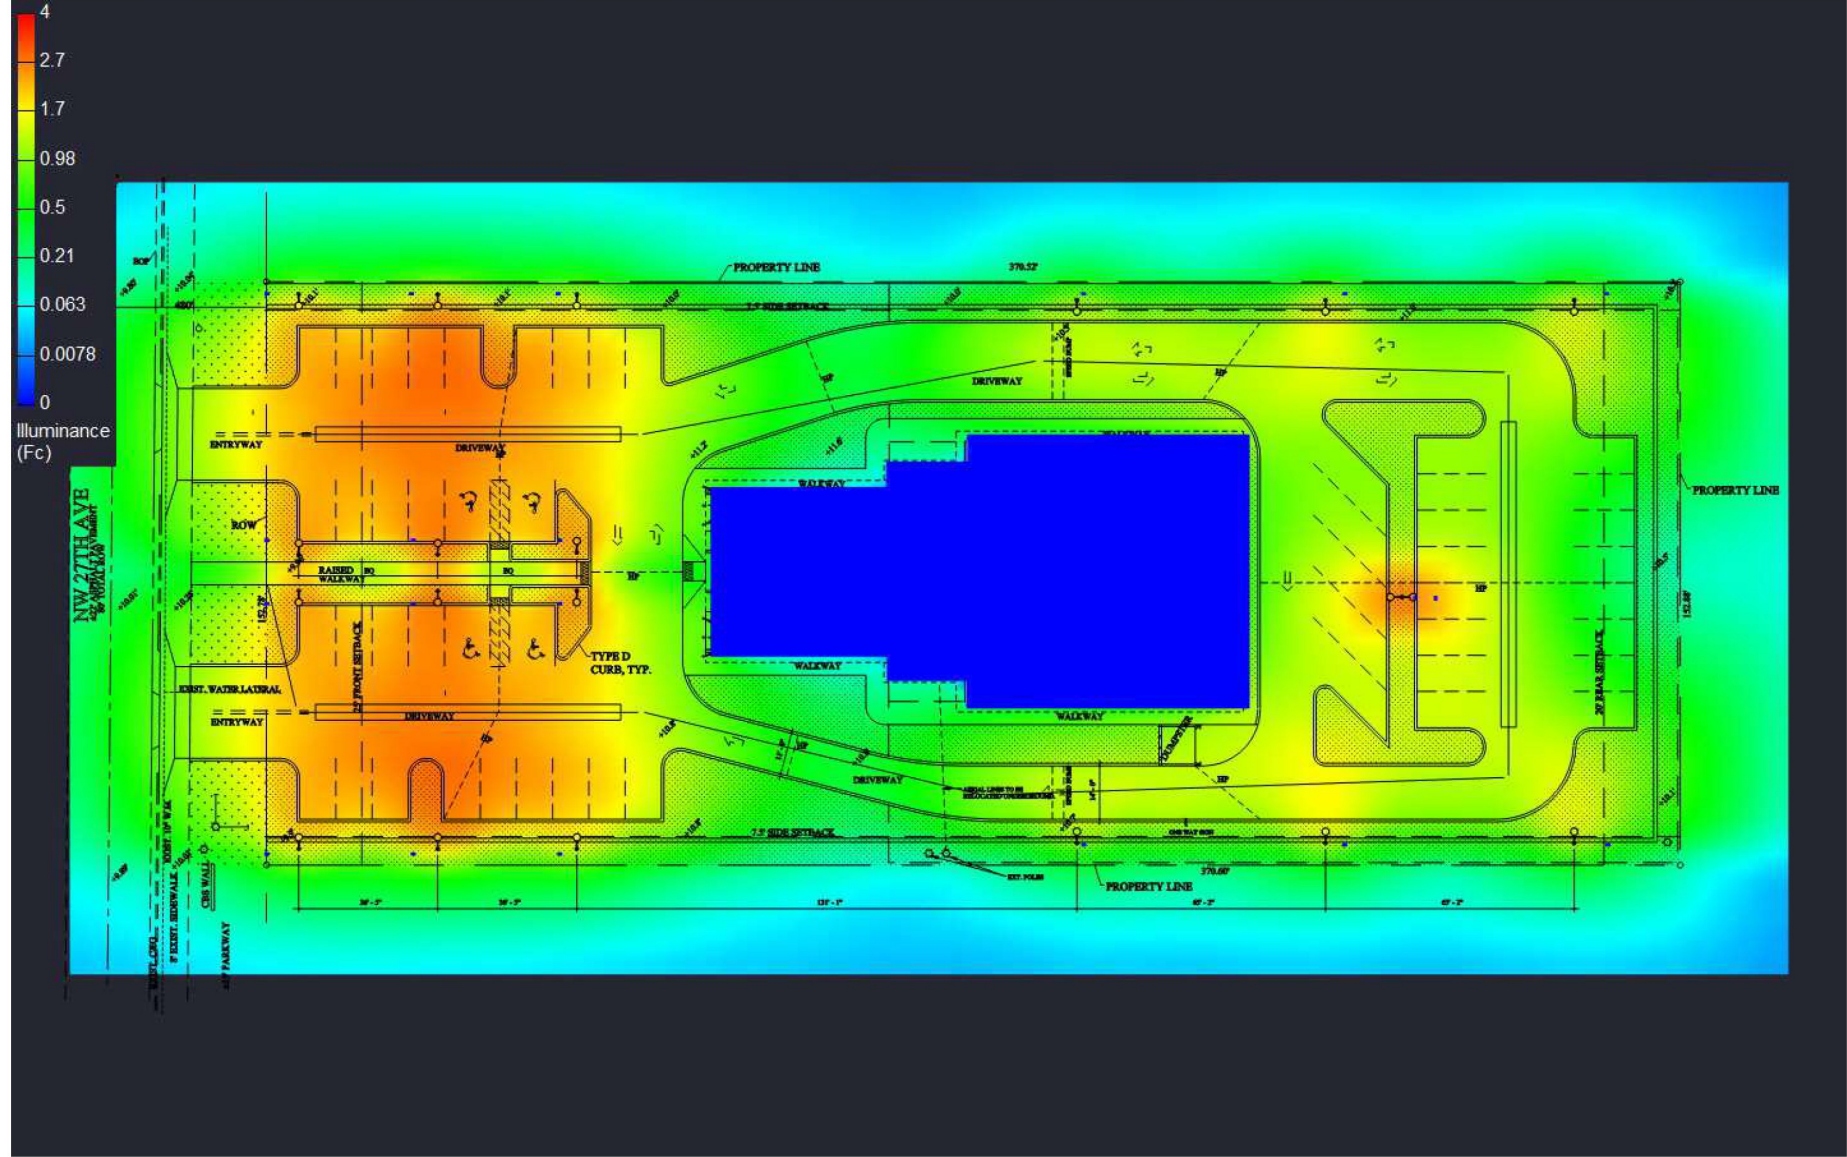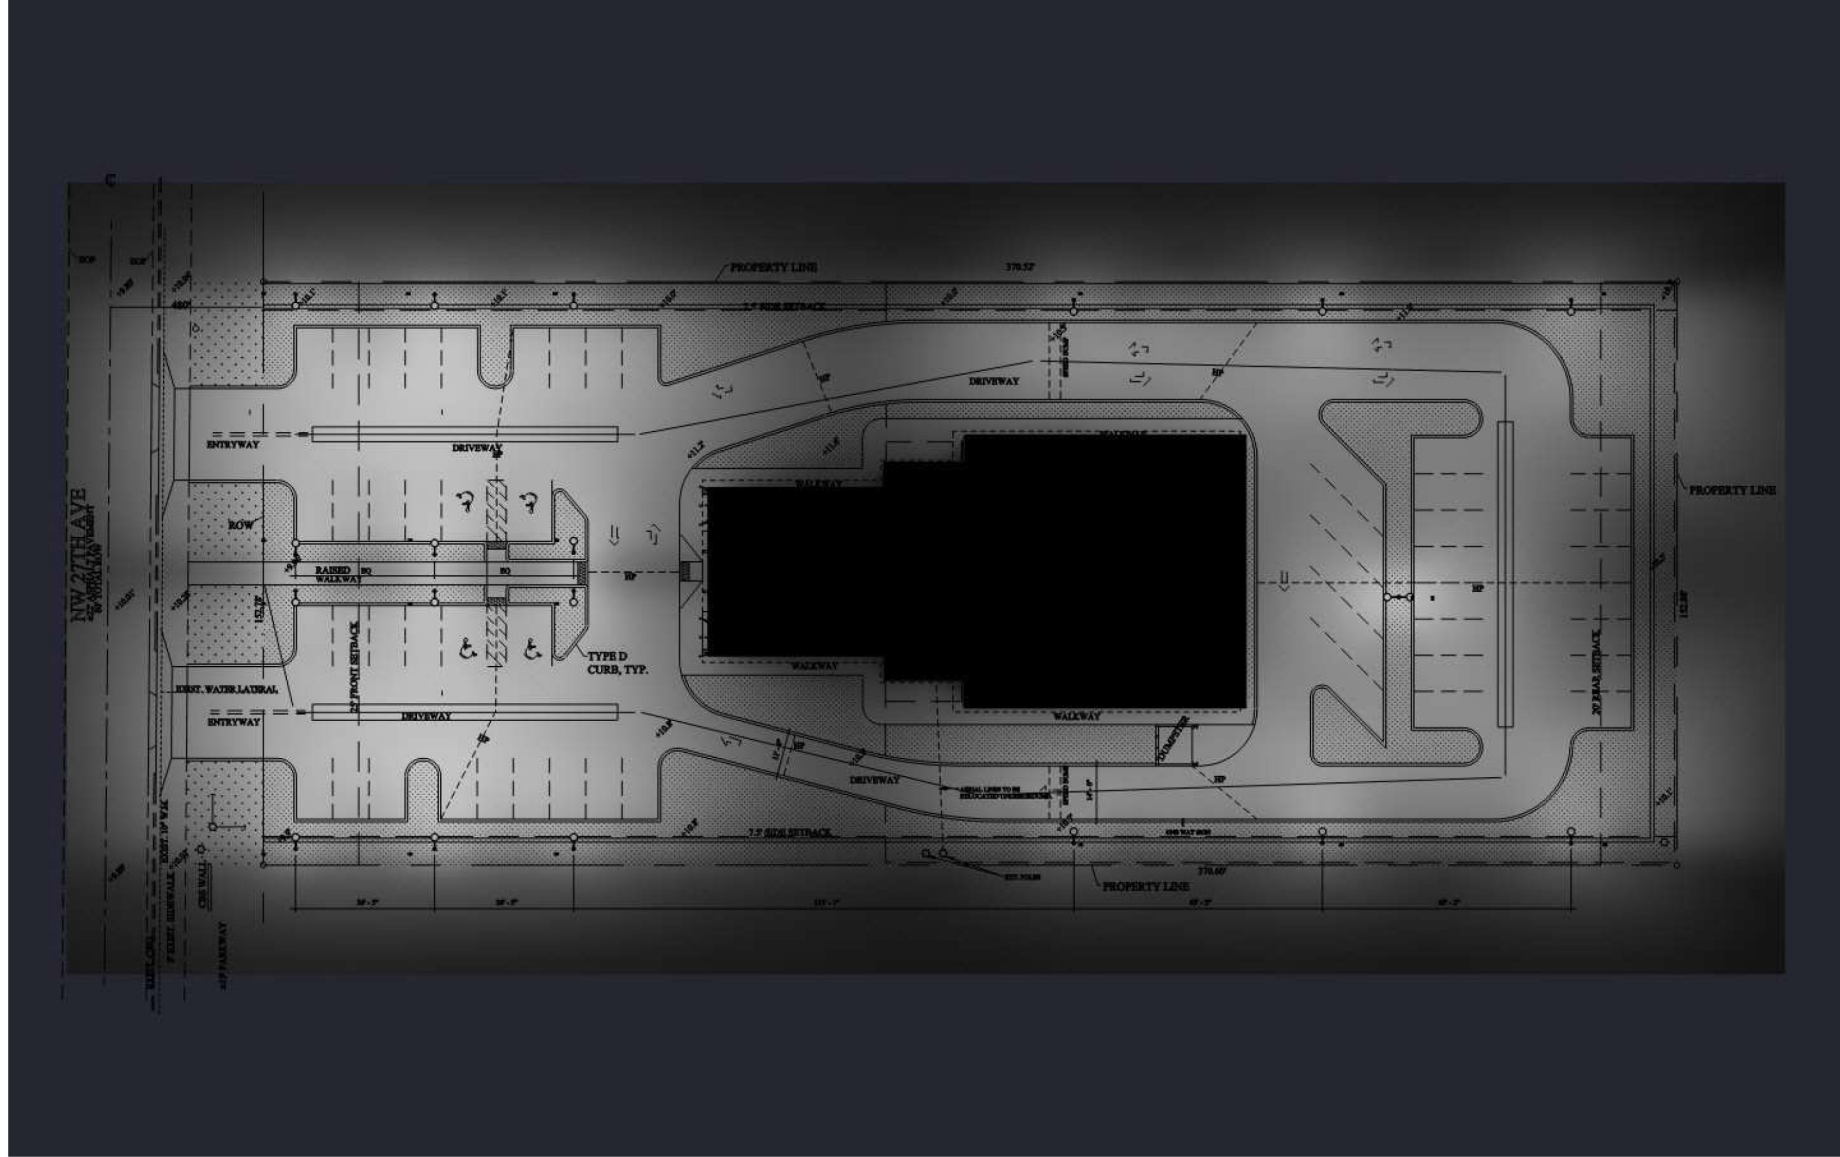

EBENZER SDA CHURCH, POMPANO BEACH

EXTERIOR LIGHTING

REF EZCHH-EXT-R01290626

DATE 06/28/2026

Page 1 of 1

EBENZER SDA
CHURCH
1210 NW 27TH AVE.
POMPANO BEACH, FL 33069

OWNER
SOUTHEASTERN ASSOC. OF
SEVENTH-DAY ADVANTISTS

TITLE
PHOTOMETRICS

E-4



STUDIOS
AJOKU STUDIOS
550 S RAINBOW DR.
HOLLYWOOD, FL 33021
INFO@AJOKUSTUDIOS.COM
(561) 384-3923

THIS ITEM HAS BEEN DIGITALLY SIGNED AND
SEALED BY RAFAEL BALLESTER ON THE DATE
ADJACENT TO THE SEAL SIGNATURE
MUST BE VERIFIED ON ANY ELECTRONIC COPIES.



DRAWING INFO

DATE: 11/25/2025
SCALE:
DRAWN BY: K.R.B.
CHECKED BY: I.A.A.
APPROVED BY: Approver
CONTRACT NO.: CD241610

IN MY PROFESSIONAL JUDGEMENT AND TO
THE BEST OF MY KNOWLEDGE AND BELIEF,
THESE PLANS AND SPECIFICATIONS COMPLY
WITH APPLICABLE BUILDING CODES AND
FIRE SAFETY CODES, AS MANDATE BY STATUTE,
FOR THE JURISDICTION IN WHICH THE
STRUCTURE CONTAINED IN THESE
DOCUMENTS SHALL BE CONSTRUCTED.

REVISIONS