


DRC

PZ25-12000047
08/19/2026

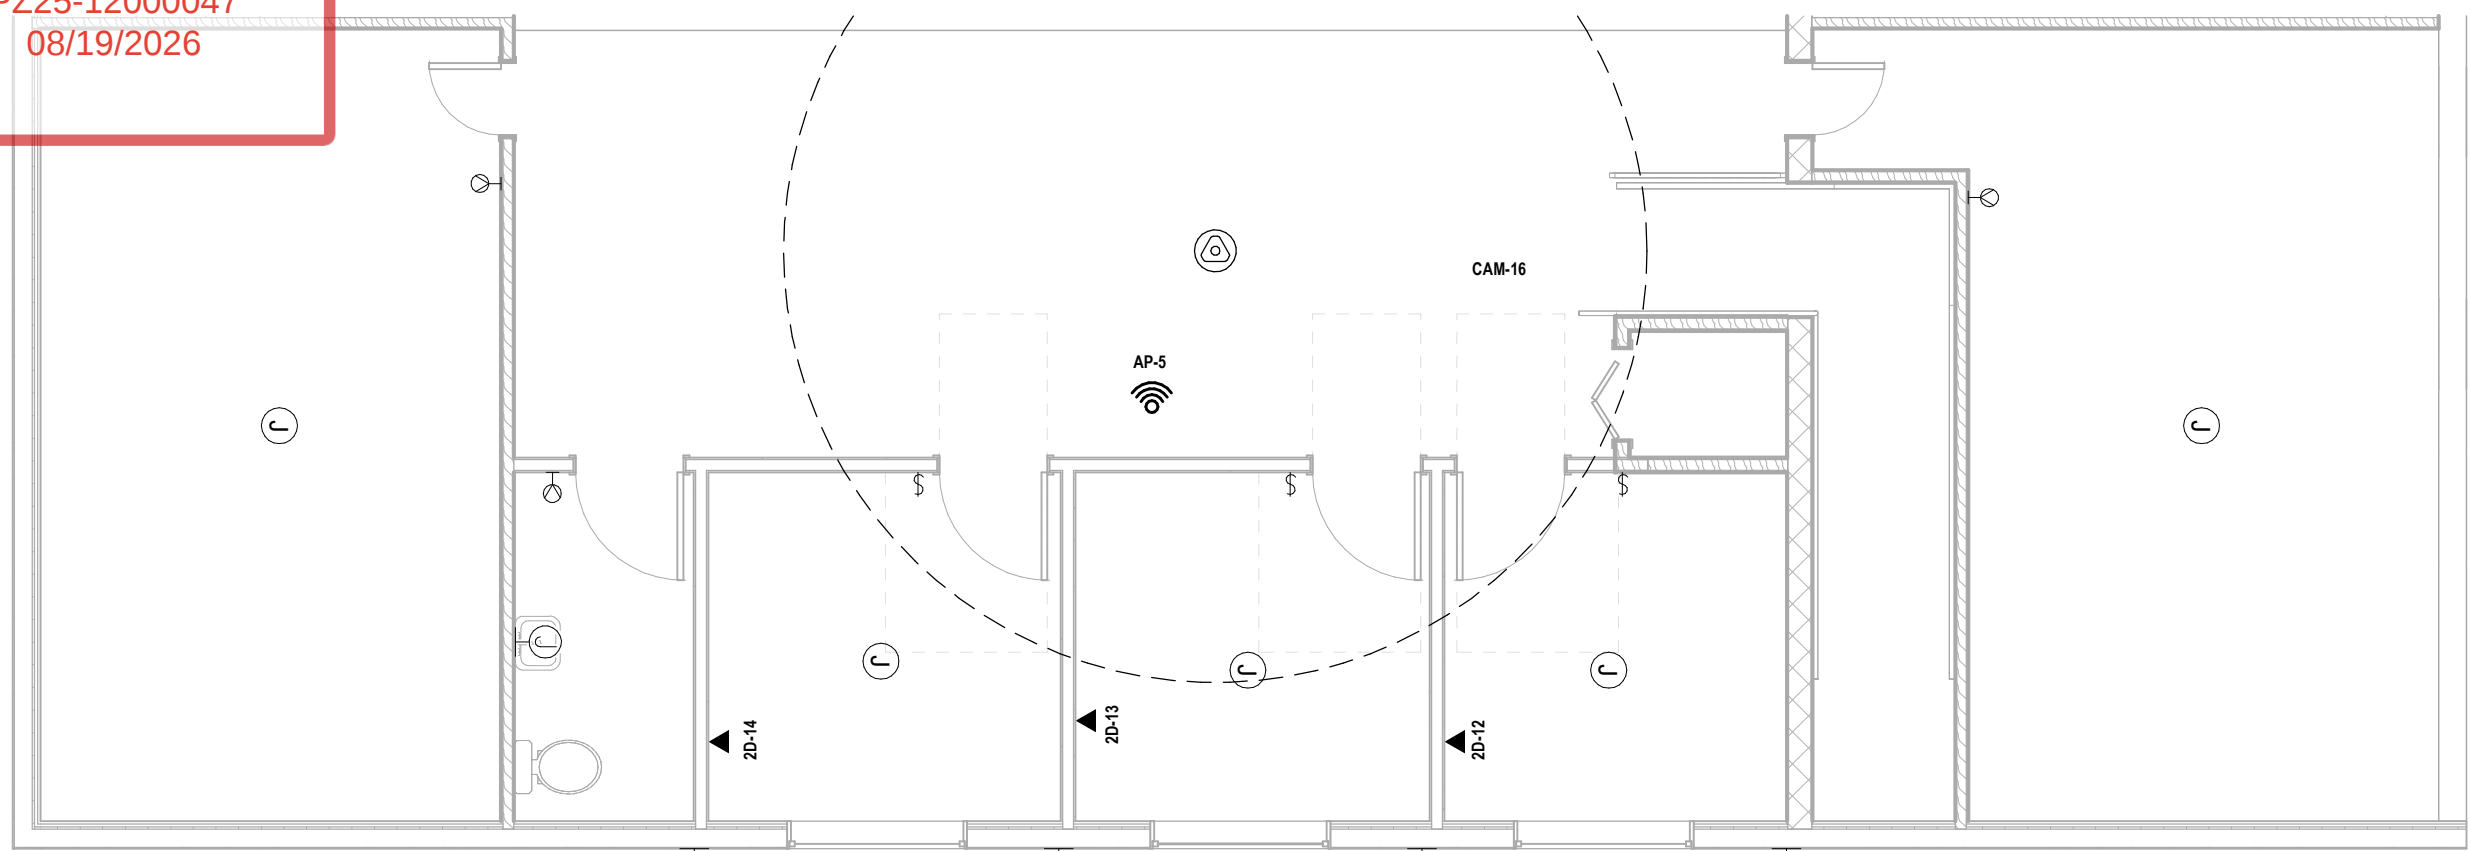


* NOTES:

- BUILDINGS WI-FI SYSTEM TO BE ENCRYPTED AND PASSWORD PROTECTED. -- NO COMPLIMENTARY SERVICE.
- SURVEILLANCE/INTRUSION SYSTEM TO BE INSTALLED BY LICENCES ADT SPECIALIST AS PER SCHEMATIC

LOW VOLTAGE LEGEND

	FISHEYE CAMERA		OCCUPANCY SENSOR - WALL
	SPEAKER		SILENT DURESS BUTTON
	WIFI ACCESS POINT		KNOX BOX
	SECURITY CAMERA		DOOR CONTACT
	DATA		SURVEILLANCE ALARM PANEL
	OCCUPANCY SENSOR - CEILING		ALARM PANEL

2 LOW VOLTAGE - MEZZANINE Copy 1
3/16" = 1'-0"

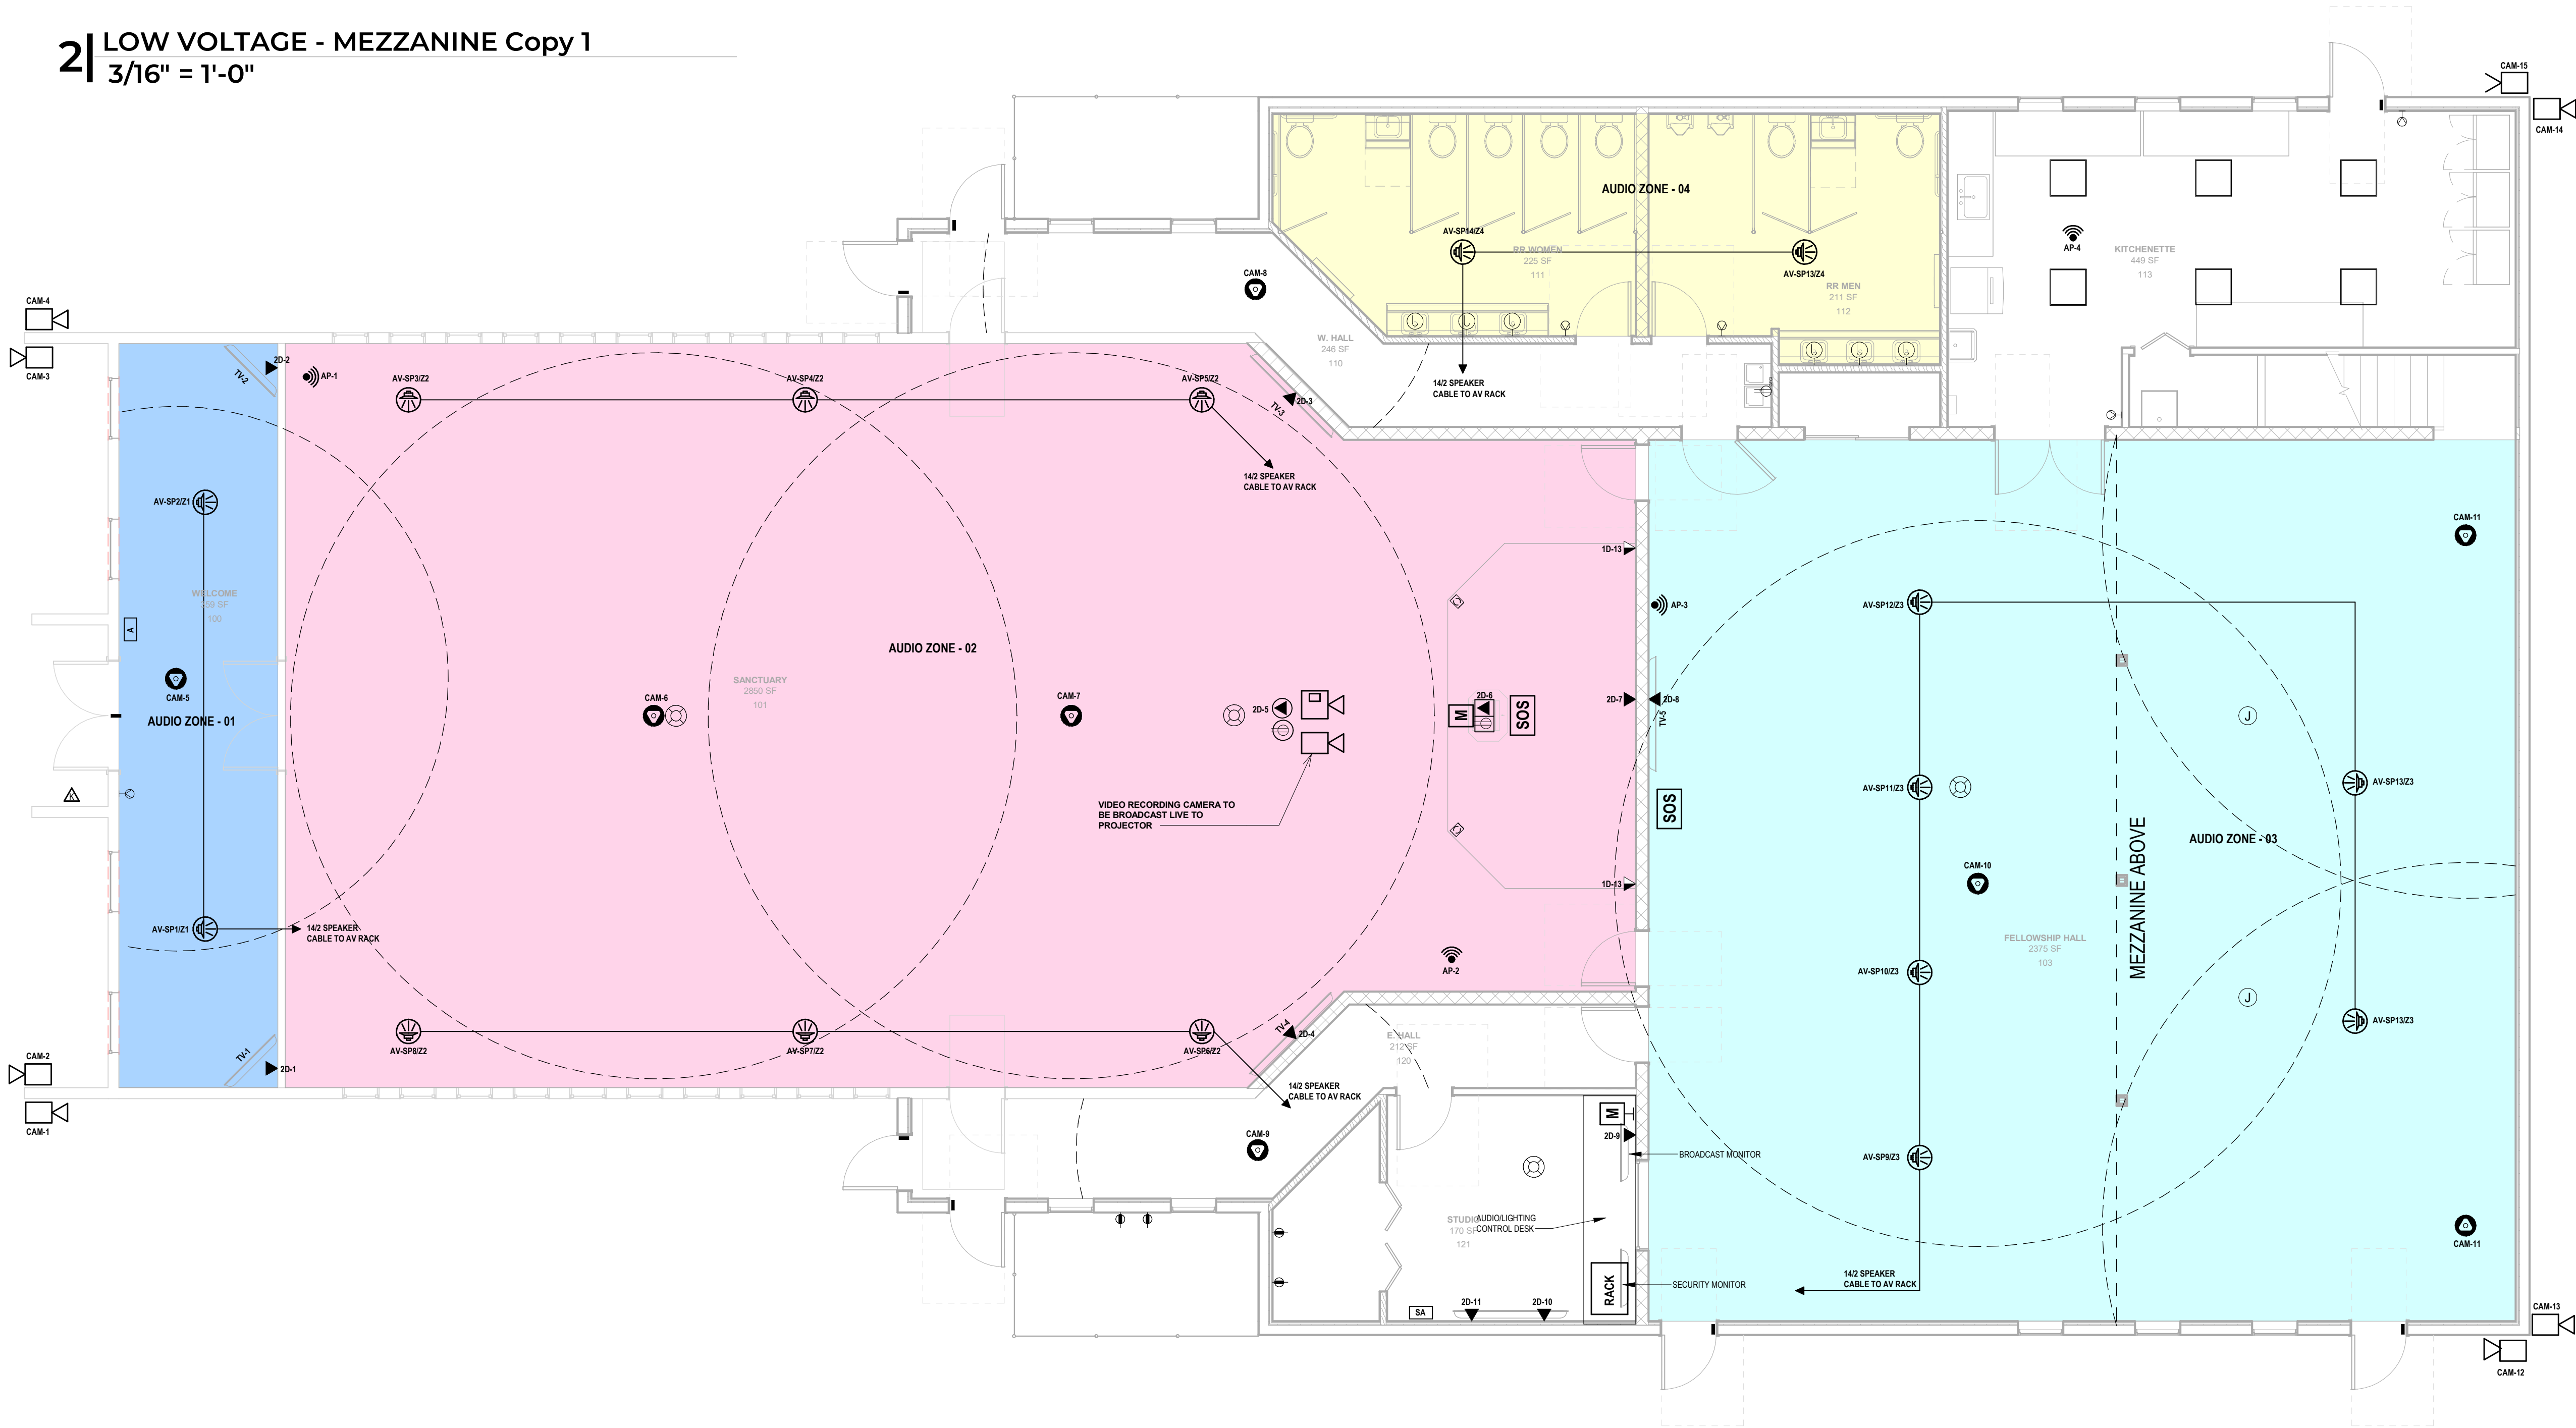

1 CPTED AUDIO/VISUAL
3/16" = 1'-0"



STUDIOS

AJOKU STUDIOS
550 S RAINBOW DR.
HOLLYWOOD, FL 33021
INFO@AJOKUSTUDIOS.COM
(561) 384-3923

THIS ITEM HAS BEEN DIGITALLY SIGNED AND SEALED BY RAFAEL BALLESTER ON THE DATE ADJACENT TO THE SEAL SIGNATURE. MUST BE VERIFIED ON ANY ELECTRONIC COPIES.



DRAWING INFO

DATE:	11/25/2025
SCALE:	As indicated
DRAWN BY:	K.R.B.
CHECKED BY:	I.A.A.
APPROVED BY:	Approver
CONTRACT NO.:	CD241610

IN MY PROFESSIONAL JUDGEMENT AND TO THE BEST OF MY KNOWLEDGE AND BELIEF, THESE PLANS AND SPECIFICATIONS COMPLY WITH APPLICABLE BUILDING CODES AND FIRESAFETY CODES, AS MANDATE BY STATUTE, FOR THE JURISDICTION IN WHICH THE STRUCTURE CONTAINED IN THESE DOCUMENTS SHALL BE CONSTRUCTED.

REVISIONS

EBENEZER SDA
CHURCH
1210 NW 27TH AVE.
POMPANO BEACH, FL 33069

OWNER
SOUTHEASTERN ASSOC. OF
SEVENTH-DAY ADVANTISTS

TITLE
SECURITY PLAN

CP-2