


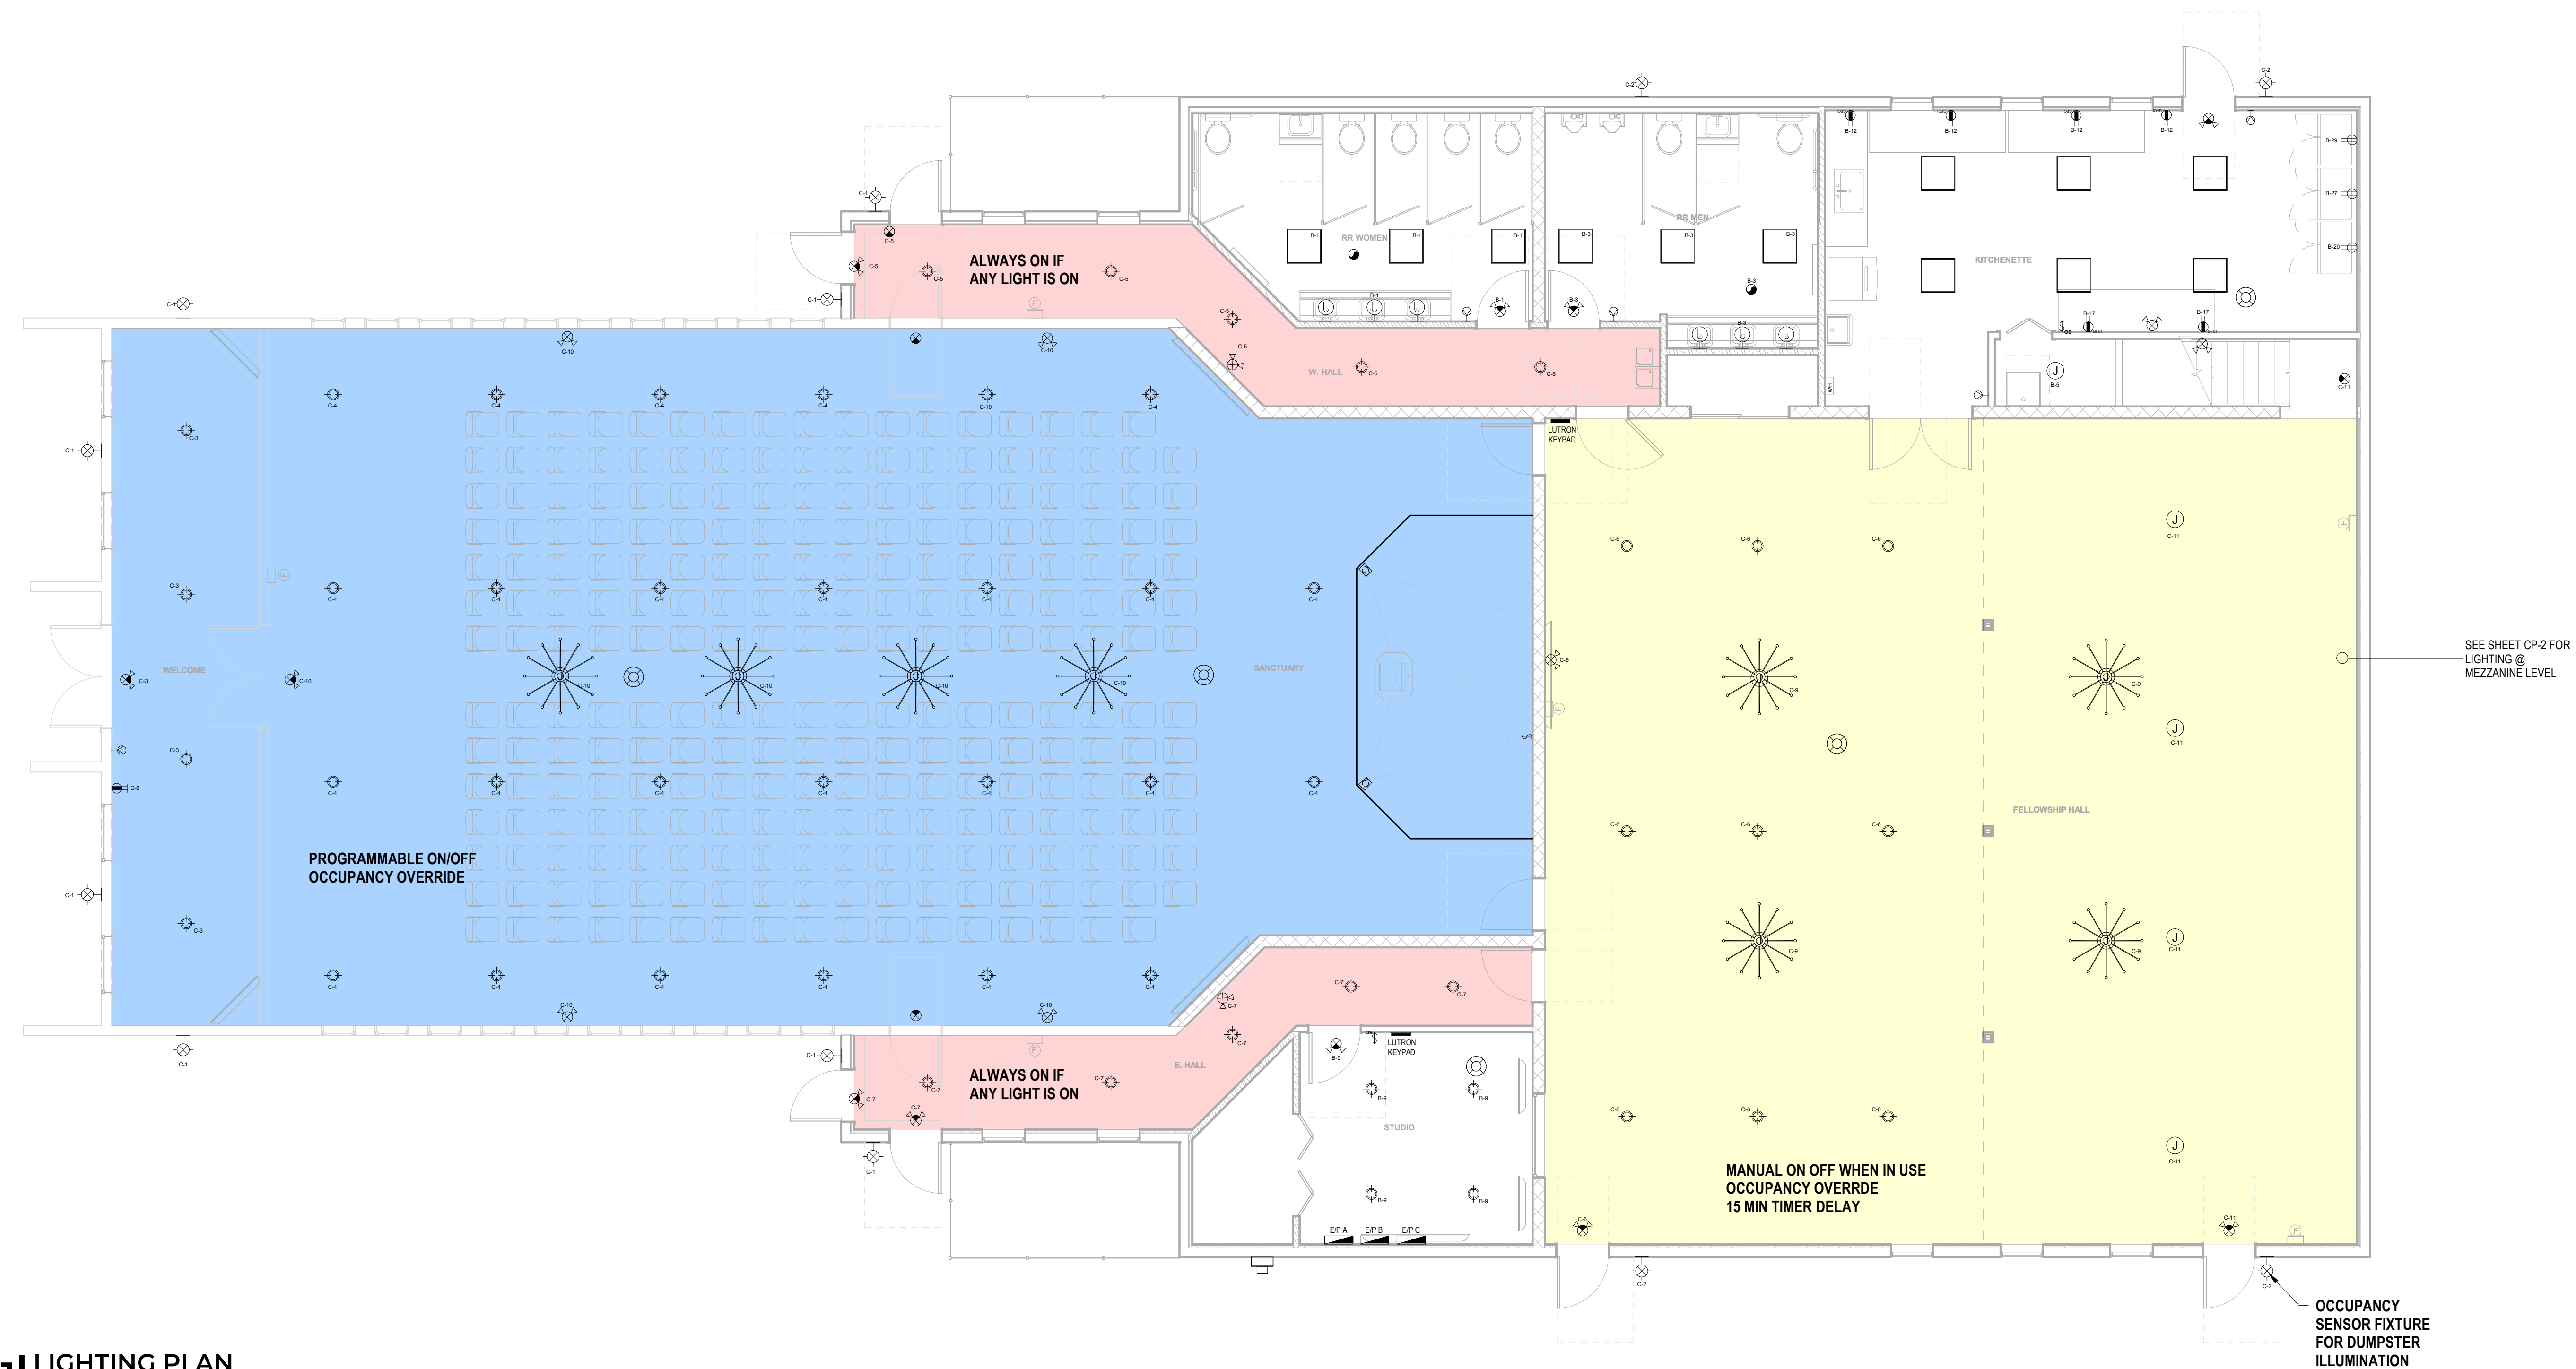

NOTE:
EXTERIOR LIGHTING
SIGNAGE
PARKING LOT LIGHTING
TO BE DUSK TO DAWN

SEE SHEET CP-2 FOR
— LIGHTING @
MEZZANINE LEVEL

— OCCUPANCY
SENSOR FIXTURE
FOR DUMPSTER
ILLUMINATION

1 | LIGHTING PLAN
3/16" = 1'-0"

ELECTRICAL LEGEND


	METER		EXHAUST FAN
	ELECTRICAL PANEL		SMOKE DETECTOR
	DUPLEX STANDARD 120V		FIRE ALARM
	DUPLEX GFCI 120V		FIRE EXTINGUISHER
	QUADPLEX 120V		THERMOSTAT
	DUPLEX 240V		EMERGENCY LIGHT
	SWITCH		EXIT SIGN
	JUNCTION BOX		EXIT SIGN W/ EMERGENCY LIGHT
	LAY-IN LIGHT		RECESSED LIGHT

 $N \equiv NFW$

F=EXISTING


* NOTES:

- LIGHTING SYSTEM TO BE DESIGNED BY LUTRON SPECIALIST THROUGH CENTRAL LUTRON CONTROL PANEL LOCATED @ "STUDIO"

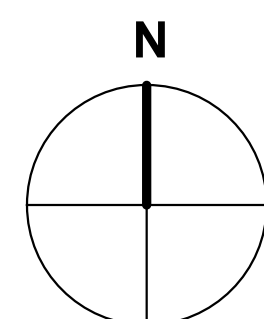

AJOKU STUDIOS
550 S RAINBOW DR.
HOLLYWOOD, FL 33021
INFO@AJOKUSTUDIOS.COM
(561) 384-3923

THIS ITEM HAS BEEN DIGITALLY SIGNED AND
SEALED BY RAFAEL BALLESTER ON THE DATE
ADJACENT TO THE SEAL SIGNATURE
MUST BE VERIFIED ON ANY ELECTRONIC COPIES.

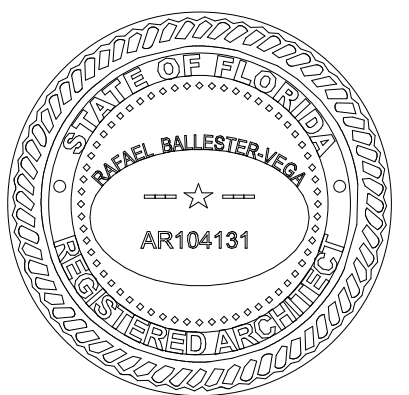

DRAWING INFO

DATE: 11/25/2025

SCALE: As indicated

DRAWN BY: I.A.A.

CHECKED BY: I.A.A.

APPROVED BY: R.B.V.

CONTRACT NO.: CD241610

IN MY PROFESSIONAL JUDGEMENT AND TO THE BEST OF MY KNOWLEDGE AND BELIEF, THESE PLANS AND SPECIFICATIONS COMPLY WITH APPLICABLE BUILDING CODES AND FIRESAFETY CODES, AS MANDATE BY STATUTE, FOR THE JURISDICTION IN WHICH THE STRUCTURE CONTAINED IN THESE DOCUMENTS SHALL BE CONSTRUCTED.

REVISIONS

**EBENEZER SDA
CHURCH**
1210 NW 27TH AVE.
POMPANO BEACH, FL 33069

OWNER
SOUTHEASTERN ASSOC. OF
SEVENTH-DAY ADVANTISTS

TITLE

LIGHTING PLAN

CP-3