

UNDER SEPARATE PERMIT

30'-0" PROPERTY LINE

DRC

ce

PZ24-12000008
09/18/2024

GANEM CONSULTING ENGINEERING
FL. C.A.#31187 FL. P.E.#74745
15805 BISCAYNE BLVD, SUITE 105
NORTH MIAMI BEACH, FL. 33160
TEL: (786) 916-6566
info@ganemce.com

KEYPLAN

Alioskar Ganem Osorio

Digitally signed
by Alioskar Ganem Osorio
Date: 2024.06.14 12:02:00 -04'00'

CONSULTING ENGINEER



ALIOSKAR GANEM P.E.
FL. LIC. No. 74745

ECO POMPAÑO TOWNHOME DEVELOPMENT

3231 NE 5TH ST, POMPAÑO BEACH, FL. 33062 UNIT 5


NOTES/COMMENTS	
1	06-07-24

REVISIONS / SUBMISSIONS

DRAWN BY: AG
CHECKED BY: AG
INITIAL DRAWING RELEASE DATE: ISSUE DATE

FIRST FLOOR PLAN

A-101

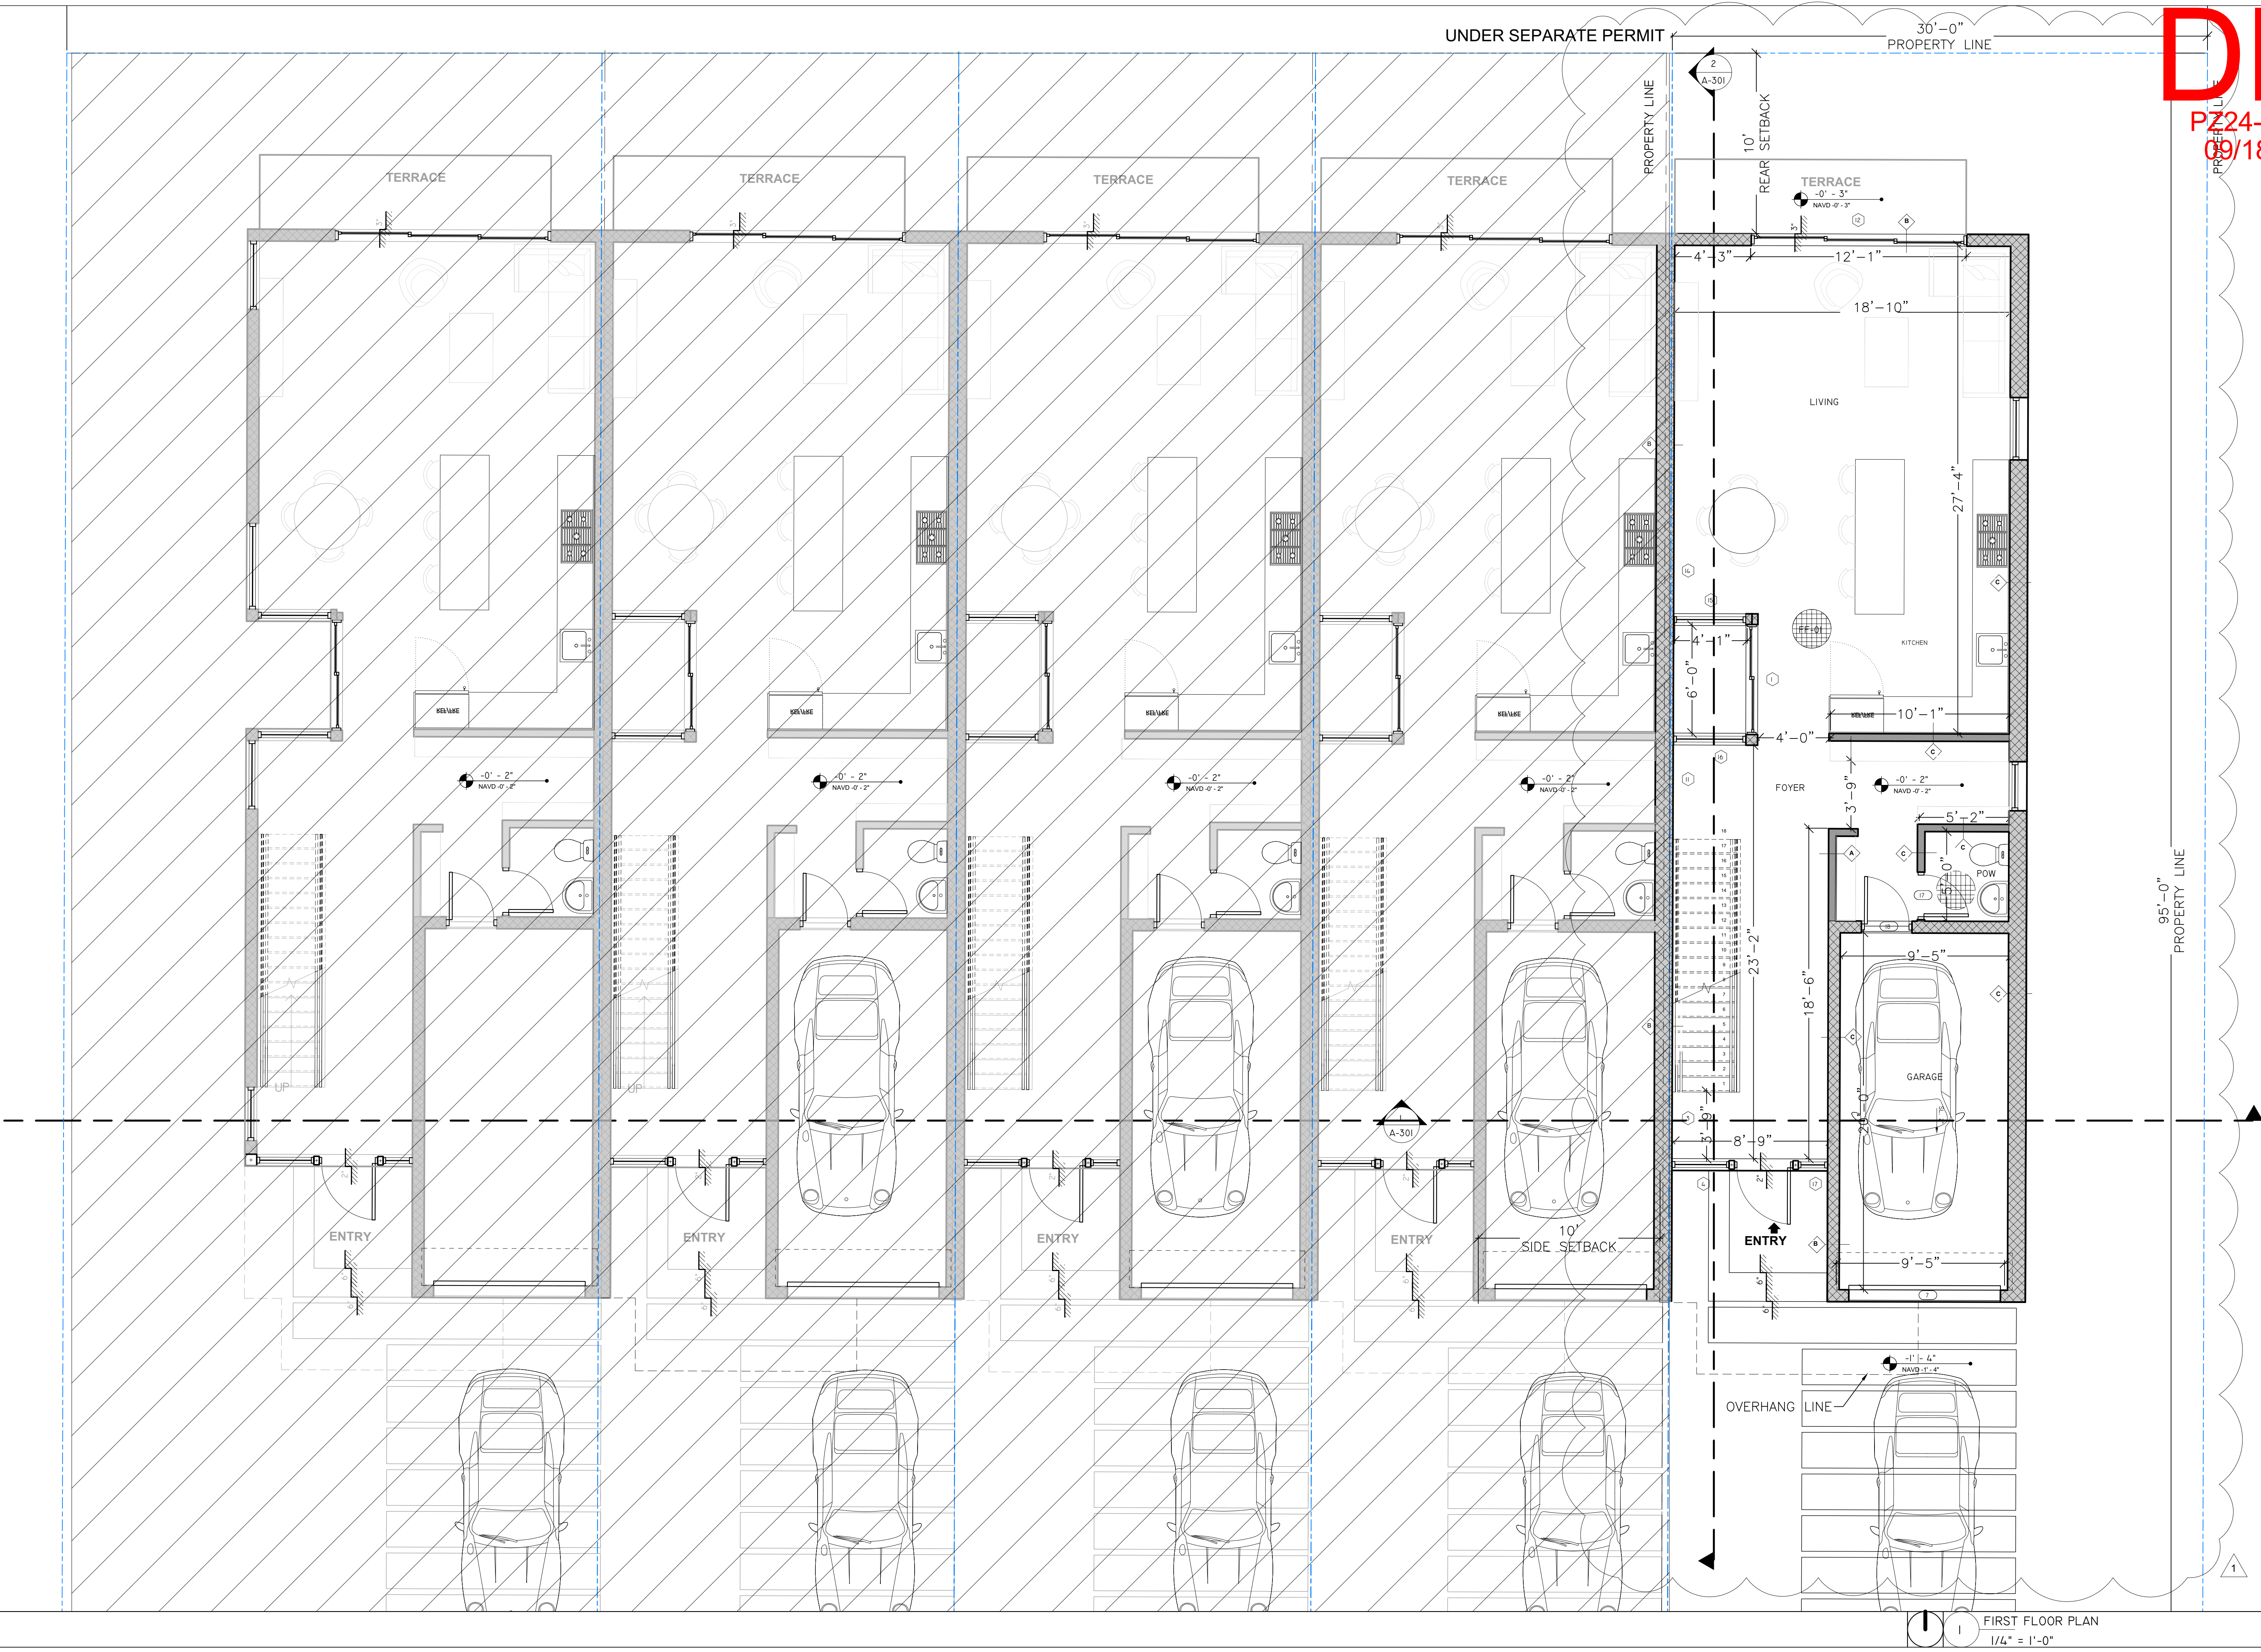

FIRST FLOOR PLAN
1/4" = 1'-0"