
[illegible]


MIA24-0051-00
PM: J. ZAPATA
DRAWN BY: C.B

ROOF PLAN

A201

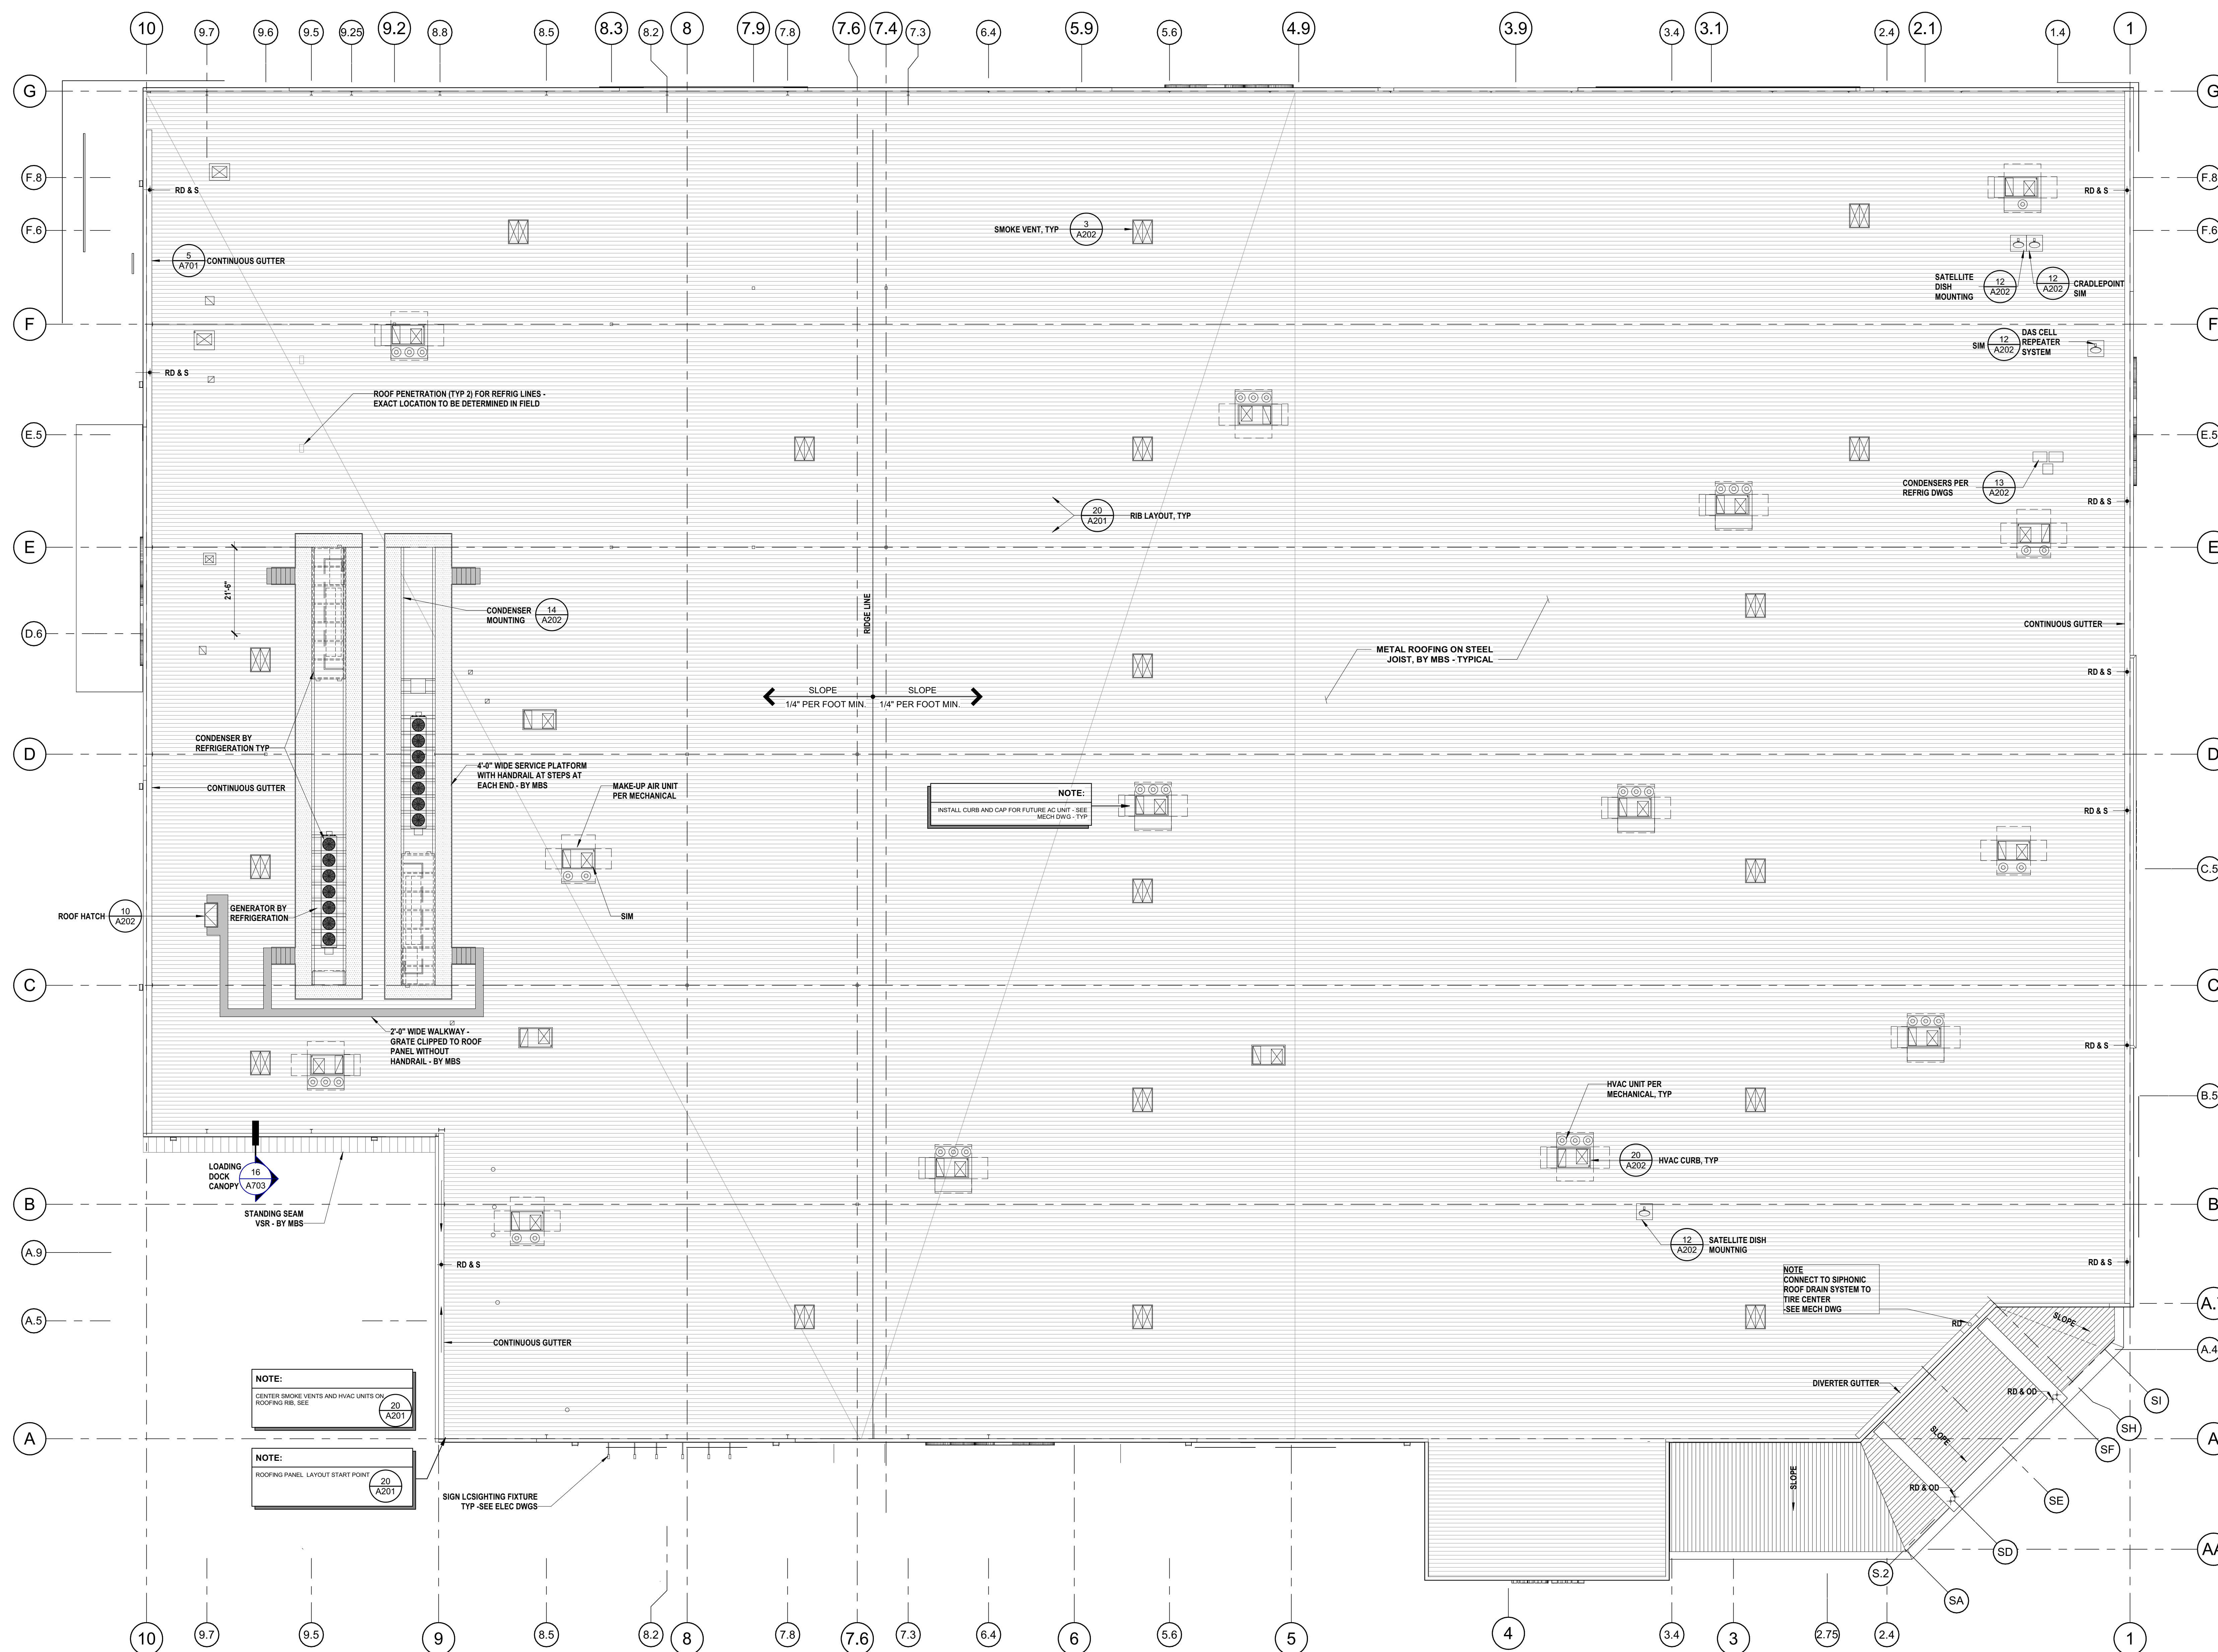

LEGENDS

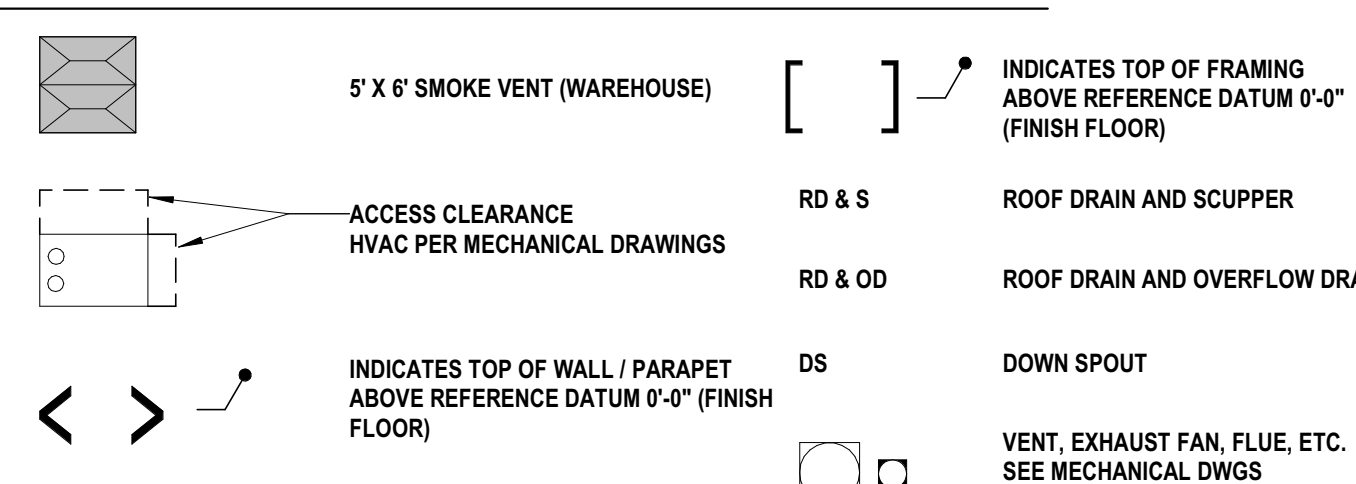

NOTES: ☐

- 1) SEE MECHANICAL FOR MECHANICAL UNIT LOCATIONS
- 2) SEE PLUMBING FOR CONTINUATION OF RAINLEADERS, (CONNECT TO TIGHT-LINED STORM DRAIN SYSTEM)
- 3) ALL MECHANICAL UNITS TO BE COORDINATED AND VERIFIED WITH METAL BUILDING SUPPLIER PRIOR TO CONSTRUCTION
- 4) PAINT ALL EXPOSED PIPING TO MATCH THE ROOF: ALUMINUM OR GALVALUME WITH THE EXCEPTION OF GAS PIPING WHICH IS TO BE PAINTED "SAFETY YELLOW", SEE SPECIFICATION
- 5) WHERE SCRAPPERS ARE NOTED, SEE A301 FOR LOCATIONS
- 6) SCUPPER SIZES - WAREHOUSE 20 X 8

NOTE



NOTE:



20 ROOFING PANEL RIB LAYOUT

SCALE: 1/4" = 1'