

1

2


3

4

5

6

EI NOT USED

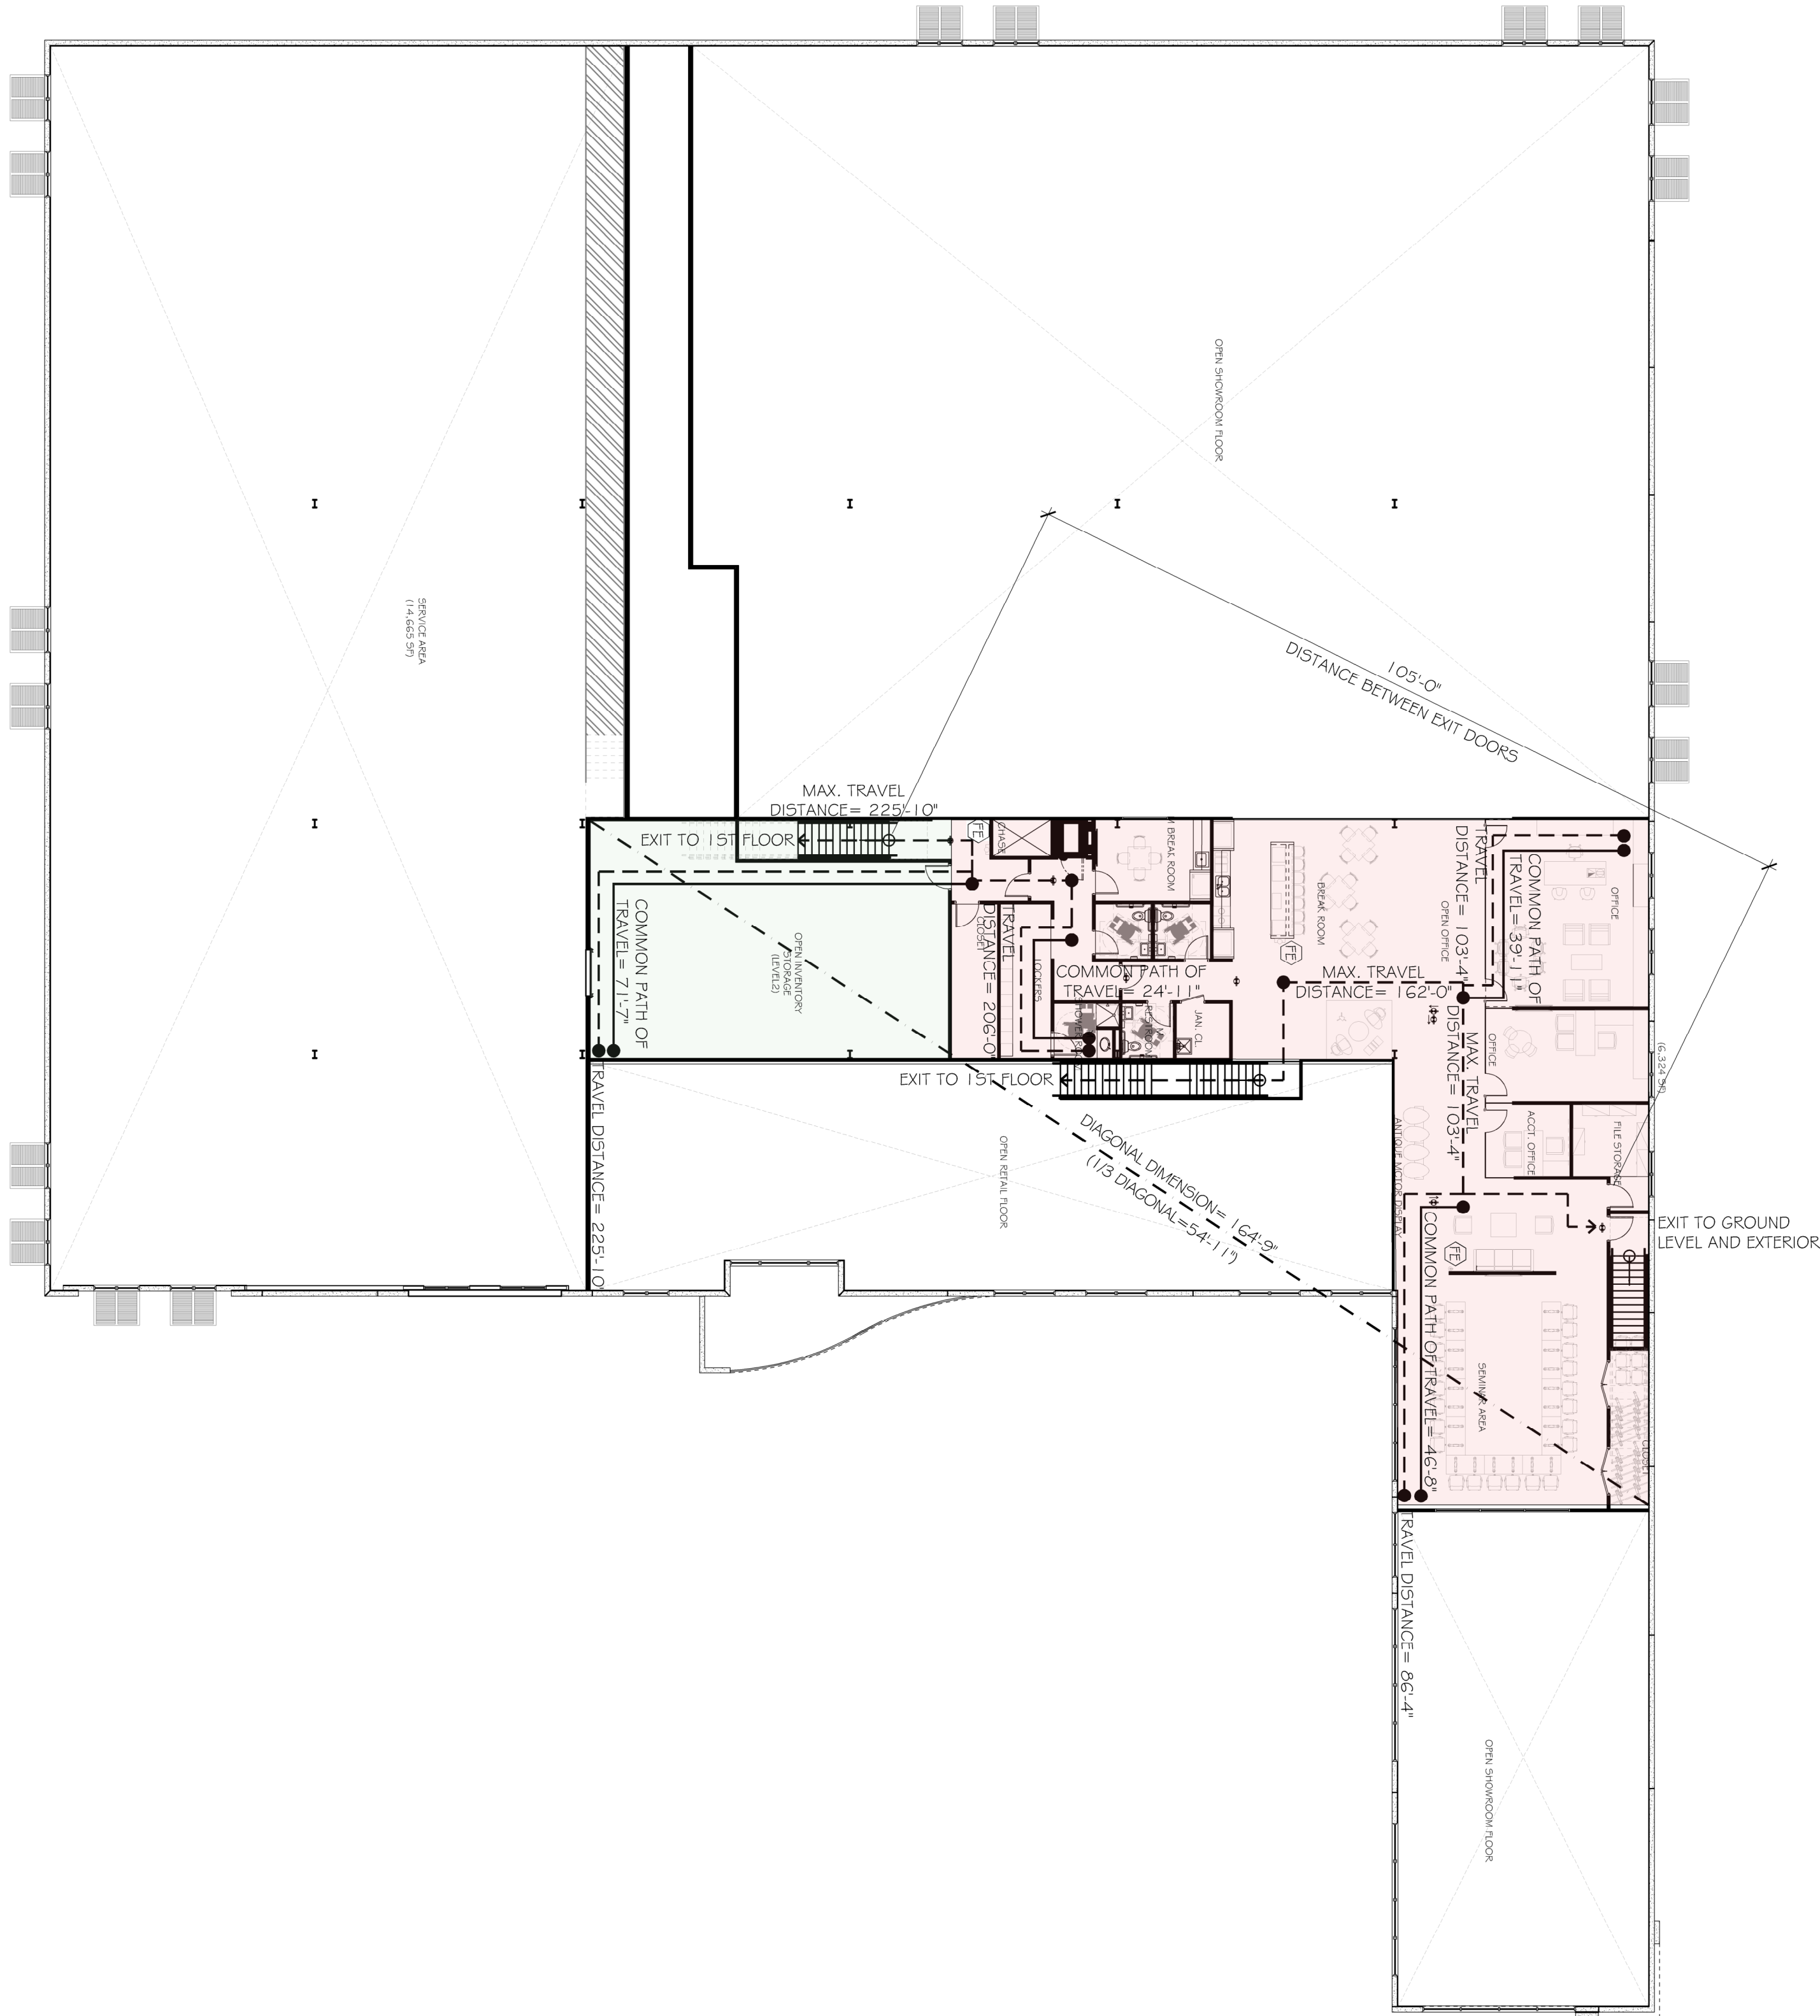

B6 CODE ANALYSIS

*REFER TO G-101

1 HR FIRE RATED WALL. REFER TO SHEET A-501.

(F) FIRE EXTINGUISHER.

--- TRAVEL DISTANCE.

→ COMMON PATH.

⊗ INDICATES EXIT SIGN.

⚡ LIGHTING FIXTURE WITH EMERGENCY BATTERY PACK. REFER TO ELECTRICAL DRAWINGS.

INDICATES KNOX BOX LOCATION


A6 LEGEND



R E V I S I O N S

DESIGNED	DRAWN	CHECKED
JPB	JO	JPB
DATE	COM-1	
05.13.2026		231120

this document or parts thereof may not be reproduced in any form without permission. copyrighted material. ©

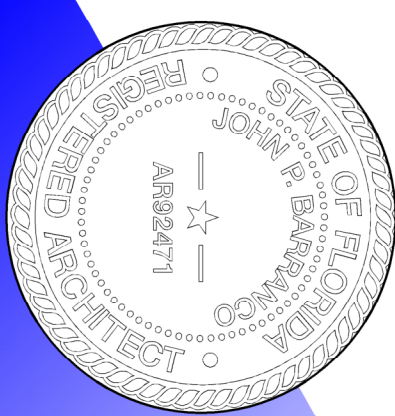

PROPOSED SITE IMPROVEMENTS FOR:
POMPANO BEACH MARINE CENTER

701 FEDERAL HIGHWAY POMPANO BEACH, FL 33062

barranco gonzalez • architecture • planning • interior design



ib # 26001020 aa # 26001030

1915 southeast 4th avenue fort lauderdale, fl 33316 phone: (954)961-7675 fax: (954) 961-7685 mail@bgarchitecture.com

consultant



 
A6

LEGEND

A1

LIFE SAFETY MEZZANINE FLOOR PLAN

1/8" = 1'-0"



THE ARCHITECT HEREBY EXPRESSLY RESERVES THE COPYRIGHT AND PROPERTY RIGHTS IN THESE PLANS. DRAWINGS ARE NOT TO BE REPRODUCED, CHANGED, OR COPIED IN ANY FORM OR MANNER WHATSOEVER WITHOUT FIRST OBTAINING WRITTEN PERMISSION AND CONSENT. NOR ARE THEY TO BE ASSIGNED TO ANY PARTY WITHOUT FIRST OBTAINING SAID WRITTEN PERMISSION AND CONSENT.