



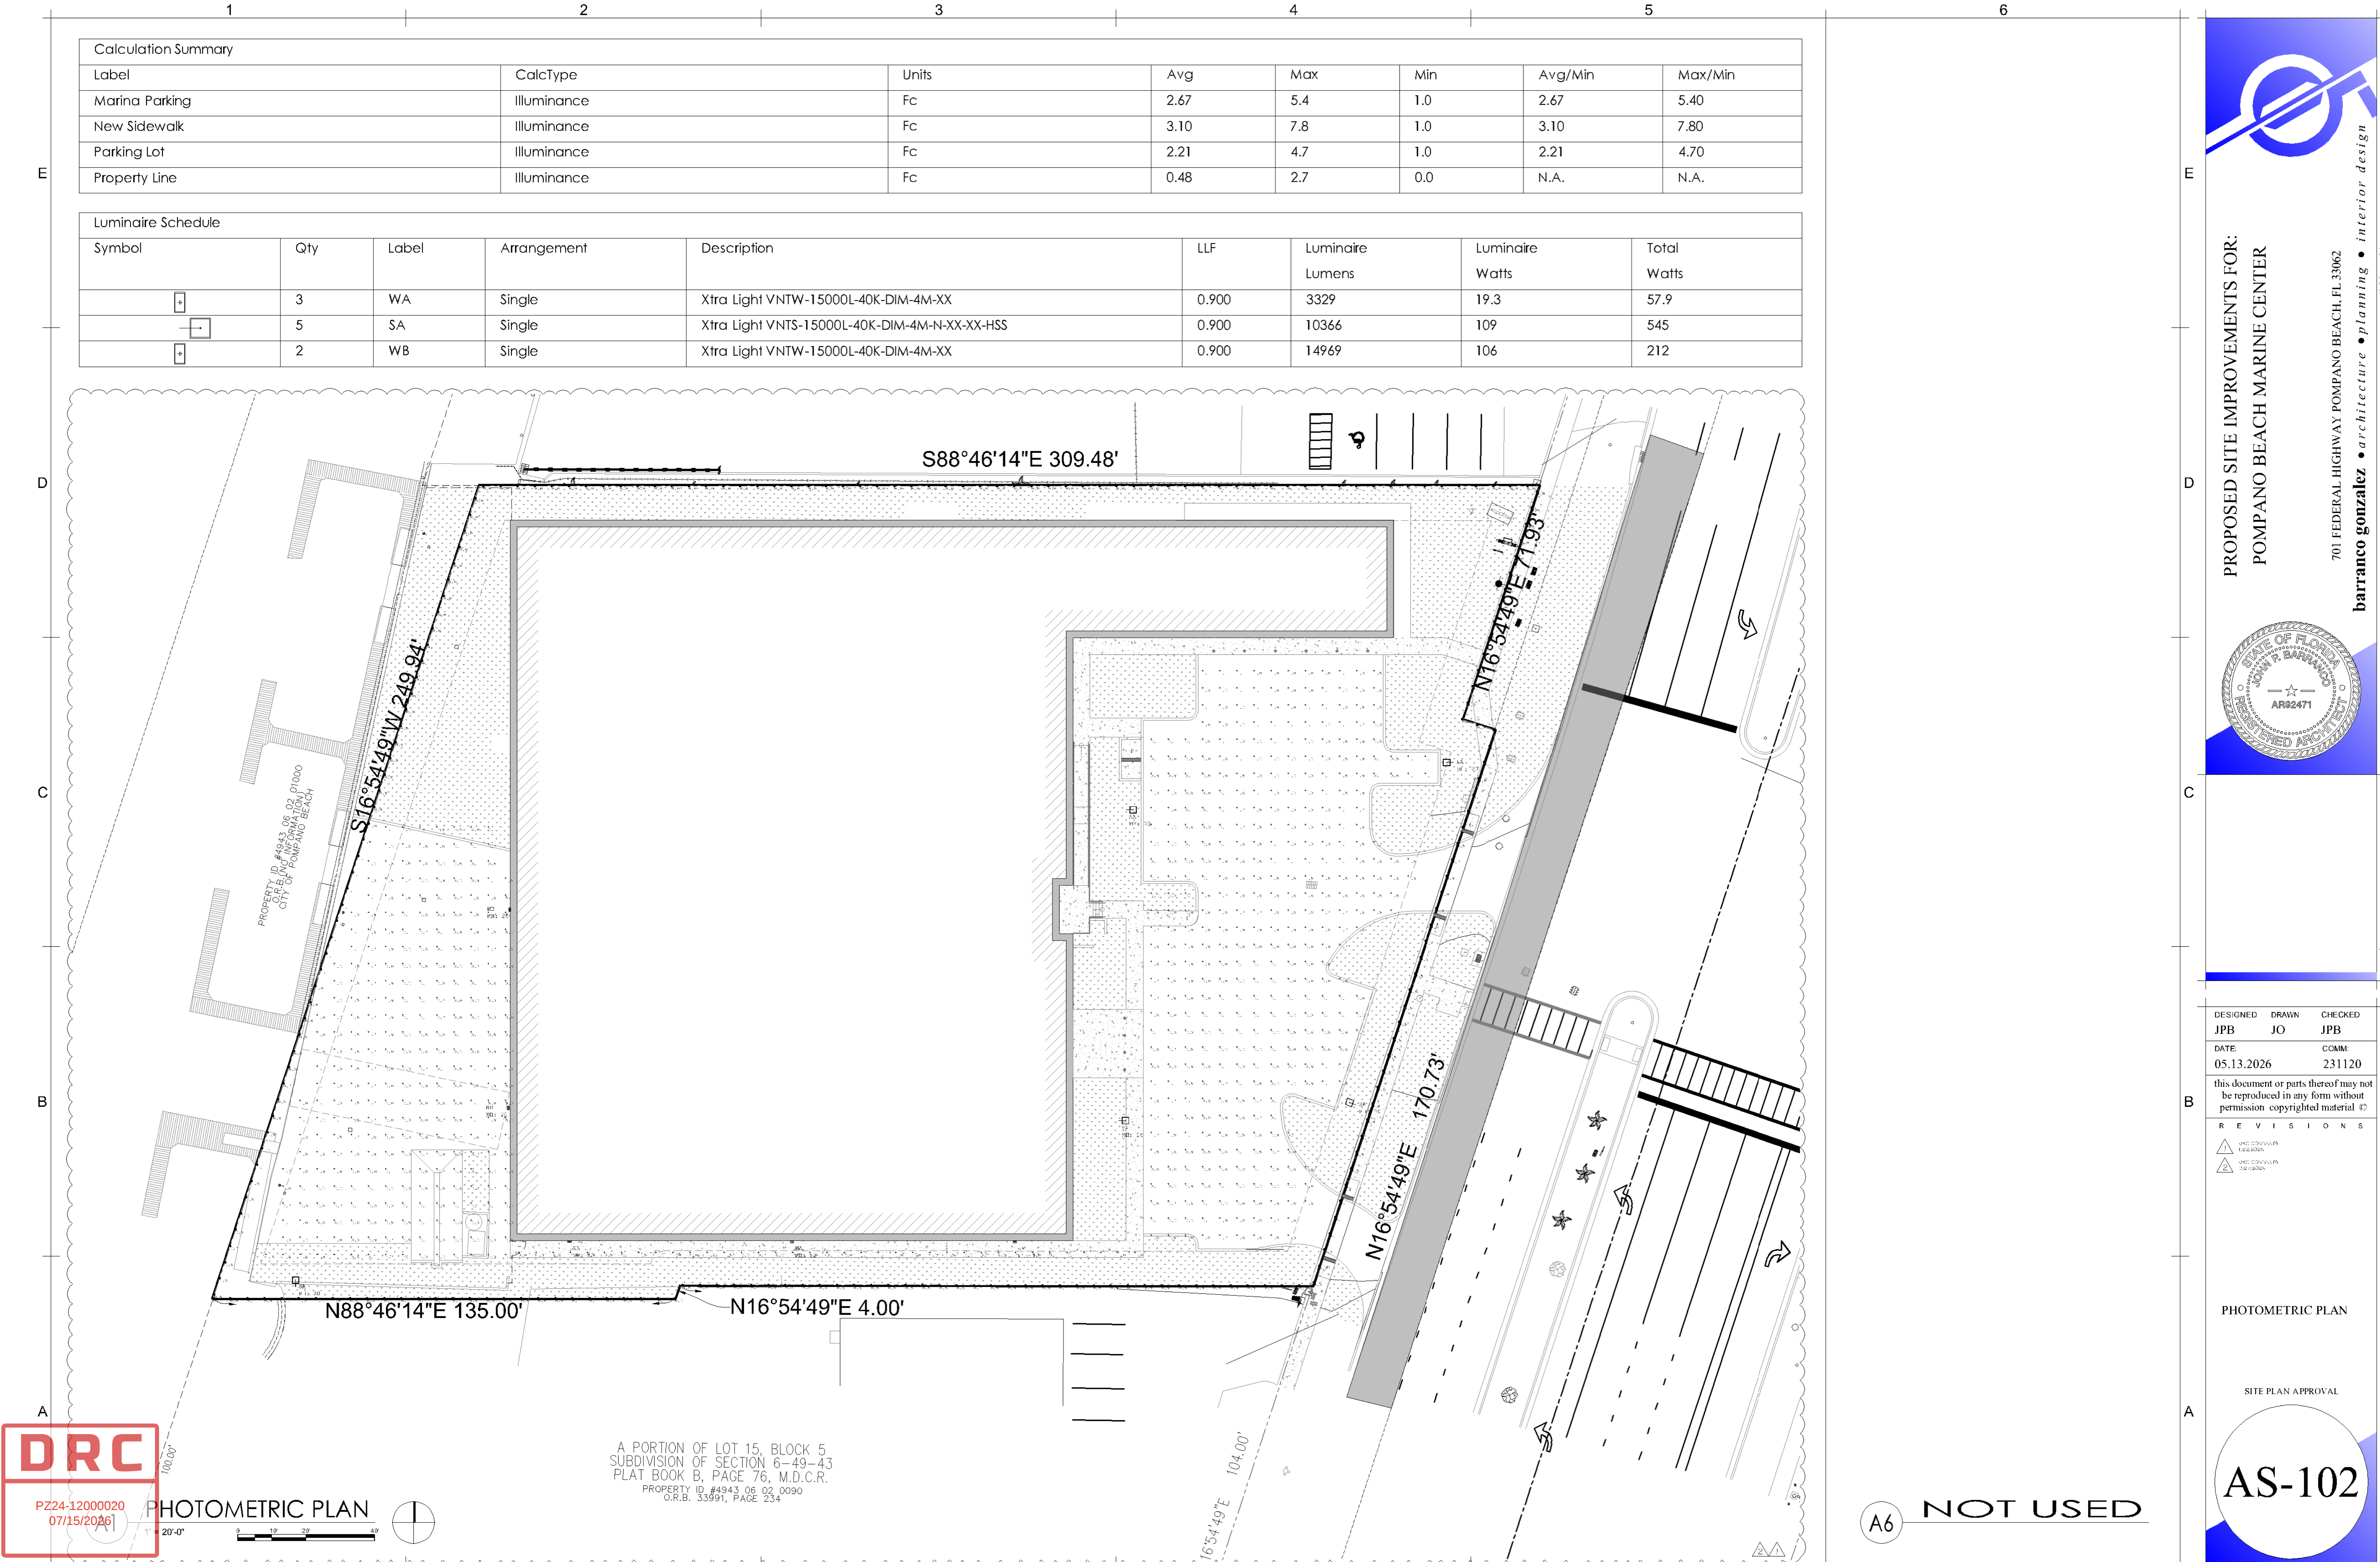

Calculation Summary							
Label	CalcType	Units	Avg	Max	Min	Avg/Min	Max/Min
Marina Parking	Illuminance	Fc	2.67	5.4	1.0	2.67	5.40
New Sidewalk	Illuminance	Fc	3.10	7.8	1.0	3.10	7.80
Parking Lot	Illuminance	Fc	2.21	4.7	1.0	2.21	4.70
Property Line	Illuminance	Fc	0.48	2.7	0.0	N.A.	N.A.

Luminaire Schedule								
Symbol	Qty	Label	Arrangement	Description	LLF	Luminaire Lumens	Luminaire Watts	Total Watts
☐	3	WA	Single	Xtra Light VNTW-15000L-40K-DIM-4M-XX	0.900	3329	19.3	57.9
☐	5	SA	Single	Xtra Light VNTS-15000L-40K-DIM-4M-N-XX-XX-HSS	0.900	10366	109	545
☐	2	WB	Single	Xtra Light VNTW-15000L-40K-DIM-4M-XX	0.900	14969	106	212

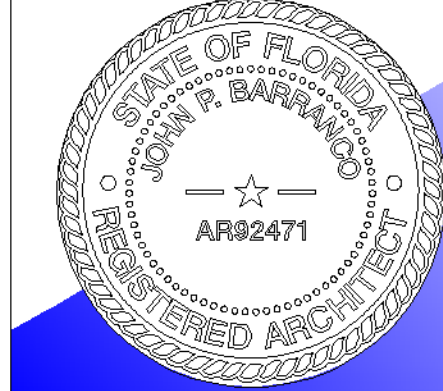

PROPOSED SITE IMPROVEMENTS FOR:
POMPANO BEACH MARINE CENTER

701 FEDERAL HIGHWAY POMPANO BEACH, FL 33062

barranco gonzalez • architecture • planning • interior design

fort lauderdale, fl 33316 phone: (954) 961-7675 fax: (954) 961-7685 mail: @bgarchitecture.com

1915 southeast 4th avenue


consultant

DESIGNED JPB	DRAWN JO	CHECKED JPB
DATE: 05.13.2026	COMM: 231120	
this document or parts thereof may not be reproduced in any form without permission copyrighted material ©		

REVISIONS	
1	AND CORRECTIONS FOR REVIEW
2	AND CORRECTIONS FOR REVIEW

PHOTOMETRIC PLAN

SITE PLAN APPROVAL

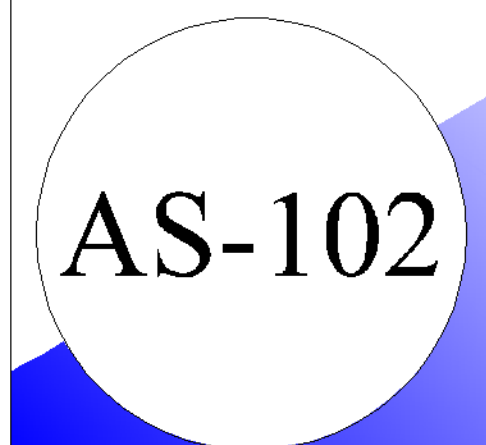

A6 NOT USED