


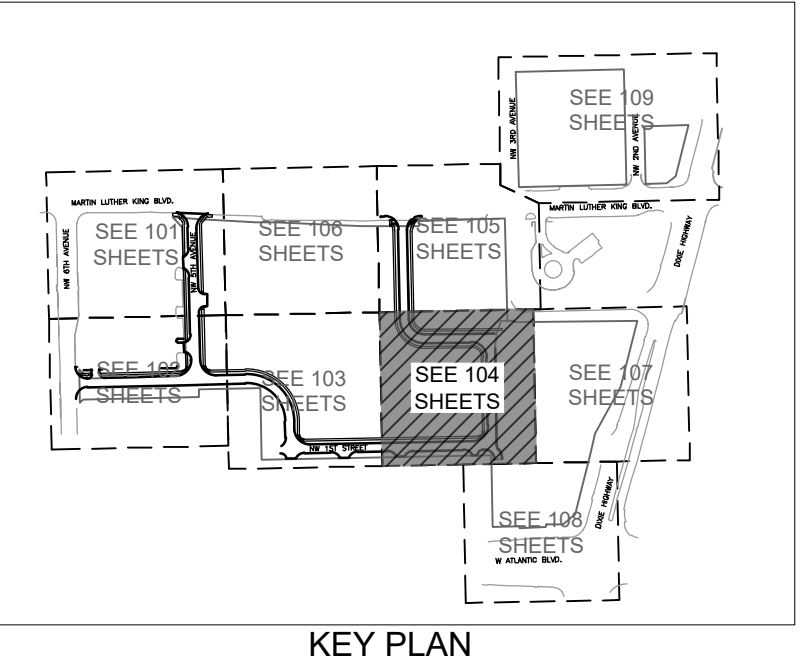

 **KEITH**  
301 East Atlantic Blvd.  
Pompano Beach, FL 33060  
PH: (954) 788-3400

---

Florida Engineering Business License: CA7928  
Florida Surveyor and Mapper Business License: LB6860  
Florida Landscape Architecture Business License: LC26000045

[illegible]

**PRELIMINARY PLAN**  
**NOT FOR CONSTRUCTION**  
THESE PLANS ARE NOT FULLY PERMITTED  
AND ARE SUBJECT TO REVISIONS MADE  
DURING THE PERMITTING PROCESS.  
RESPONSIBILITY FOR THE USE OF THESE  
PLANS PRIOR TO OBTAINING PERMITS FROM  
ALL AGENCIES HAVING JURISDICTION OVER  
THE PROJECT WILL FALL SOLELY UPON THE  
USER.

|               |            |
|---------------|------------|
| ISSUE DATE:   | 02/25/2026 |
| DESIGNED BY:  | SL, KU     |
| DRAWN BY:     | KU, EZ     |
| CHECKED BY:   | SL, KU     |
| BID-CONTRACT: |            |

**PAUL H. WEINBERG, PLA**  
**FLORIDA REG. NO. LA6666804**  
**(FOR THE FIRM)**

CLIENT

RP  
POMPANO  
LLC

PROJECT


**DOWNTOWN  
POMPANO**

**PHOTOMETRIC PLAN**

|                   |          |
|-------------------|----------|
| SHEET<br>NUMBER   | LL-104   |
| PROJECT<br>NUMBER | 15083.00 |

| Luminaire Schedule                                                                    |     |       |             |             |       |                 |             |                                                                 |
|---------------------------------------------------------------------------------------|-----|-------|-------------|-------------|-------|-----------------|-------------|-----------------------------------------------------------------|
| Symbol                                                                                | Qty | Label | Arrangement | Lum. Lumens | LLD   | Luminaire Watts | Total Watts | Description                                                     |
|  | 26  | L1    | Single      | 6172        | 1,000 | 54.4            | 1365.6      | LUMEC RK26-55W2LED-4K-G3-ACRO-L228-UVV-DMG (POLE MTD 3P A.F.G.) |

| Calculation Summary |             |       |      |     |     |         |         |        |
|---------------------|-------------|-------|------|-----|-----|---------|---------|--------|
| Label               | CalcType    | Units | Avg  | Max | Min | Avg/Min | Max/Min | Grid Z |
| ROADWAY             | Illuminance | Fc    | 1.09 | 2.1 | 0.5 | 2.18    | 4.20    | 0      |

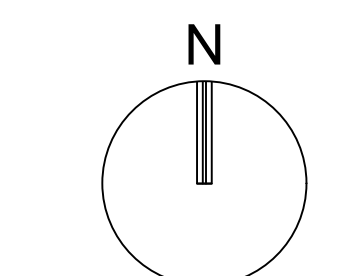

GRAPHIC SCALE

SCALE: 1" = 20'

NOTE: PRINTED DRAWING S  
MAY HAVE CHANGED FRC  
ORIGINAL. VERIFY SCALE US

ORIGINAL. VERIFY SCALE USING  
BAR SCALE ABOVE.

Drawing name: H:\15083.00 - Downtown Pompano - RP Development LLC\Landscape Architecture\CAD\15083.00-LL-1XX.dwg

**STATUS: PRELIMINARY**

DRC

PZ26-12000001  
08/05/2026