

PZ26-12000001
04/01/2026



05/20/2026
301 East Atlantic Blvd.
Pompano Beach, FL 33060
PH: (954) 788-3400

Florida Engineering Business License: CA7928
Florida Surveyor and Mapper Business License: LB8660
Florida Landscape Architecture Business License: LC26000

[illegible]

**PRELIMINARY PLAN
NOT FOR CONSTRUCTION**

THESE PLANS ARE NOT FULLY PERMITTED
AND ARE SUBJECT TO REVISIONS MADE
DURING THE PERMITTING PROCESS.

RESPONSIBILITY FOR THE USE OF THESE PLANS PRIOR TO OBTAINING PERMITS FROM ALL AGENCIES HAVING JURISDICTION OVER THE PROJECT WILL FALL SOLELY UPON THE USER.

ISSUE DATE: 02/25/202

DESIGNED BY: SL. K

DRAWN BY: KU, E

CHECKED BY: SL, K

BID-CONTRACT:	
----------------------	--

PAUL H. WEINBERG, PLA
FLORIDA REG. NO. LA6666804
(FOR THE FIRM)

CLIENT

RP
POMPANO
LLC

PROJECT


**DOWNTOWN
POMPANO**

SHEET TITLE


PHOTOMETRIC PLAN

SHEET
NUMBER **LL-108**

PROJECT NUMBER	15083.00
----------------	----------

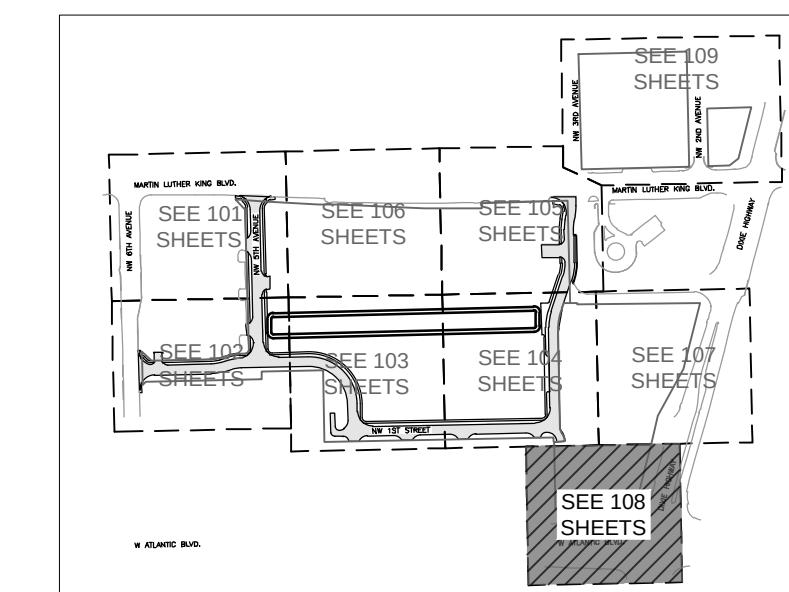


KEY PLAN

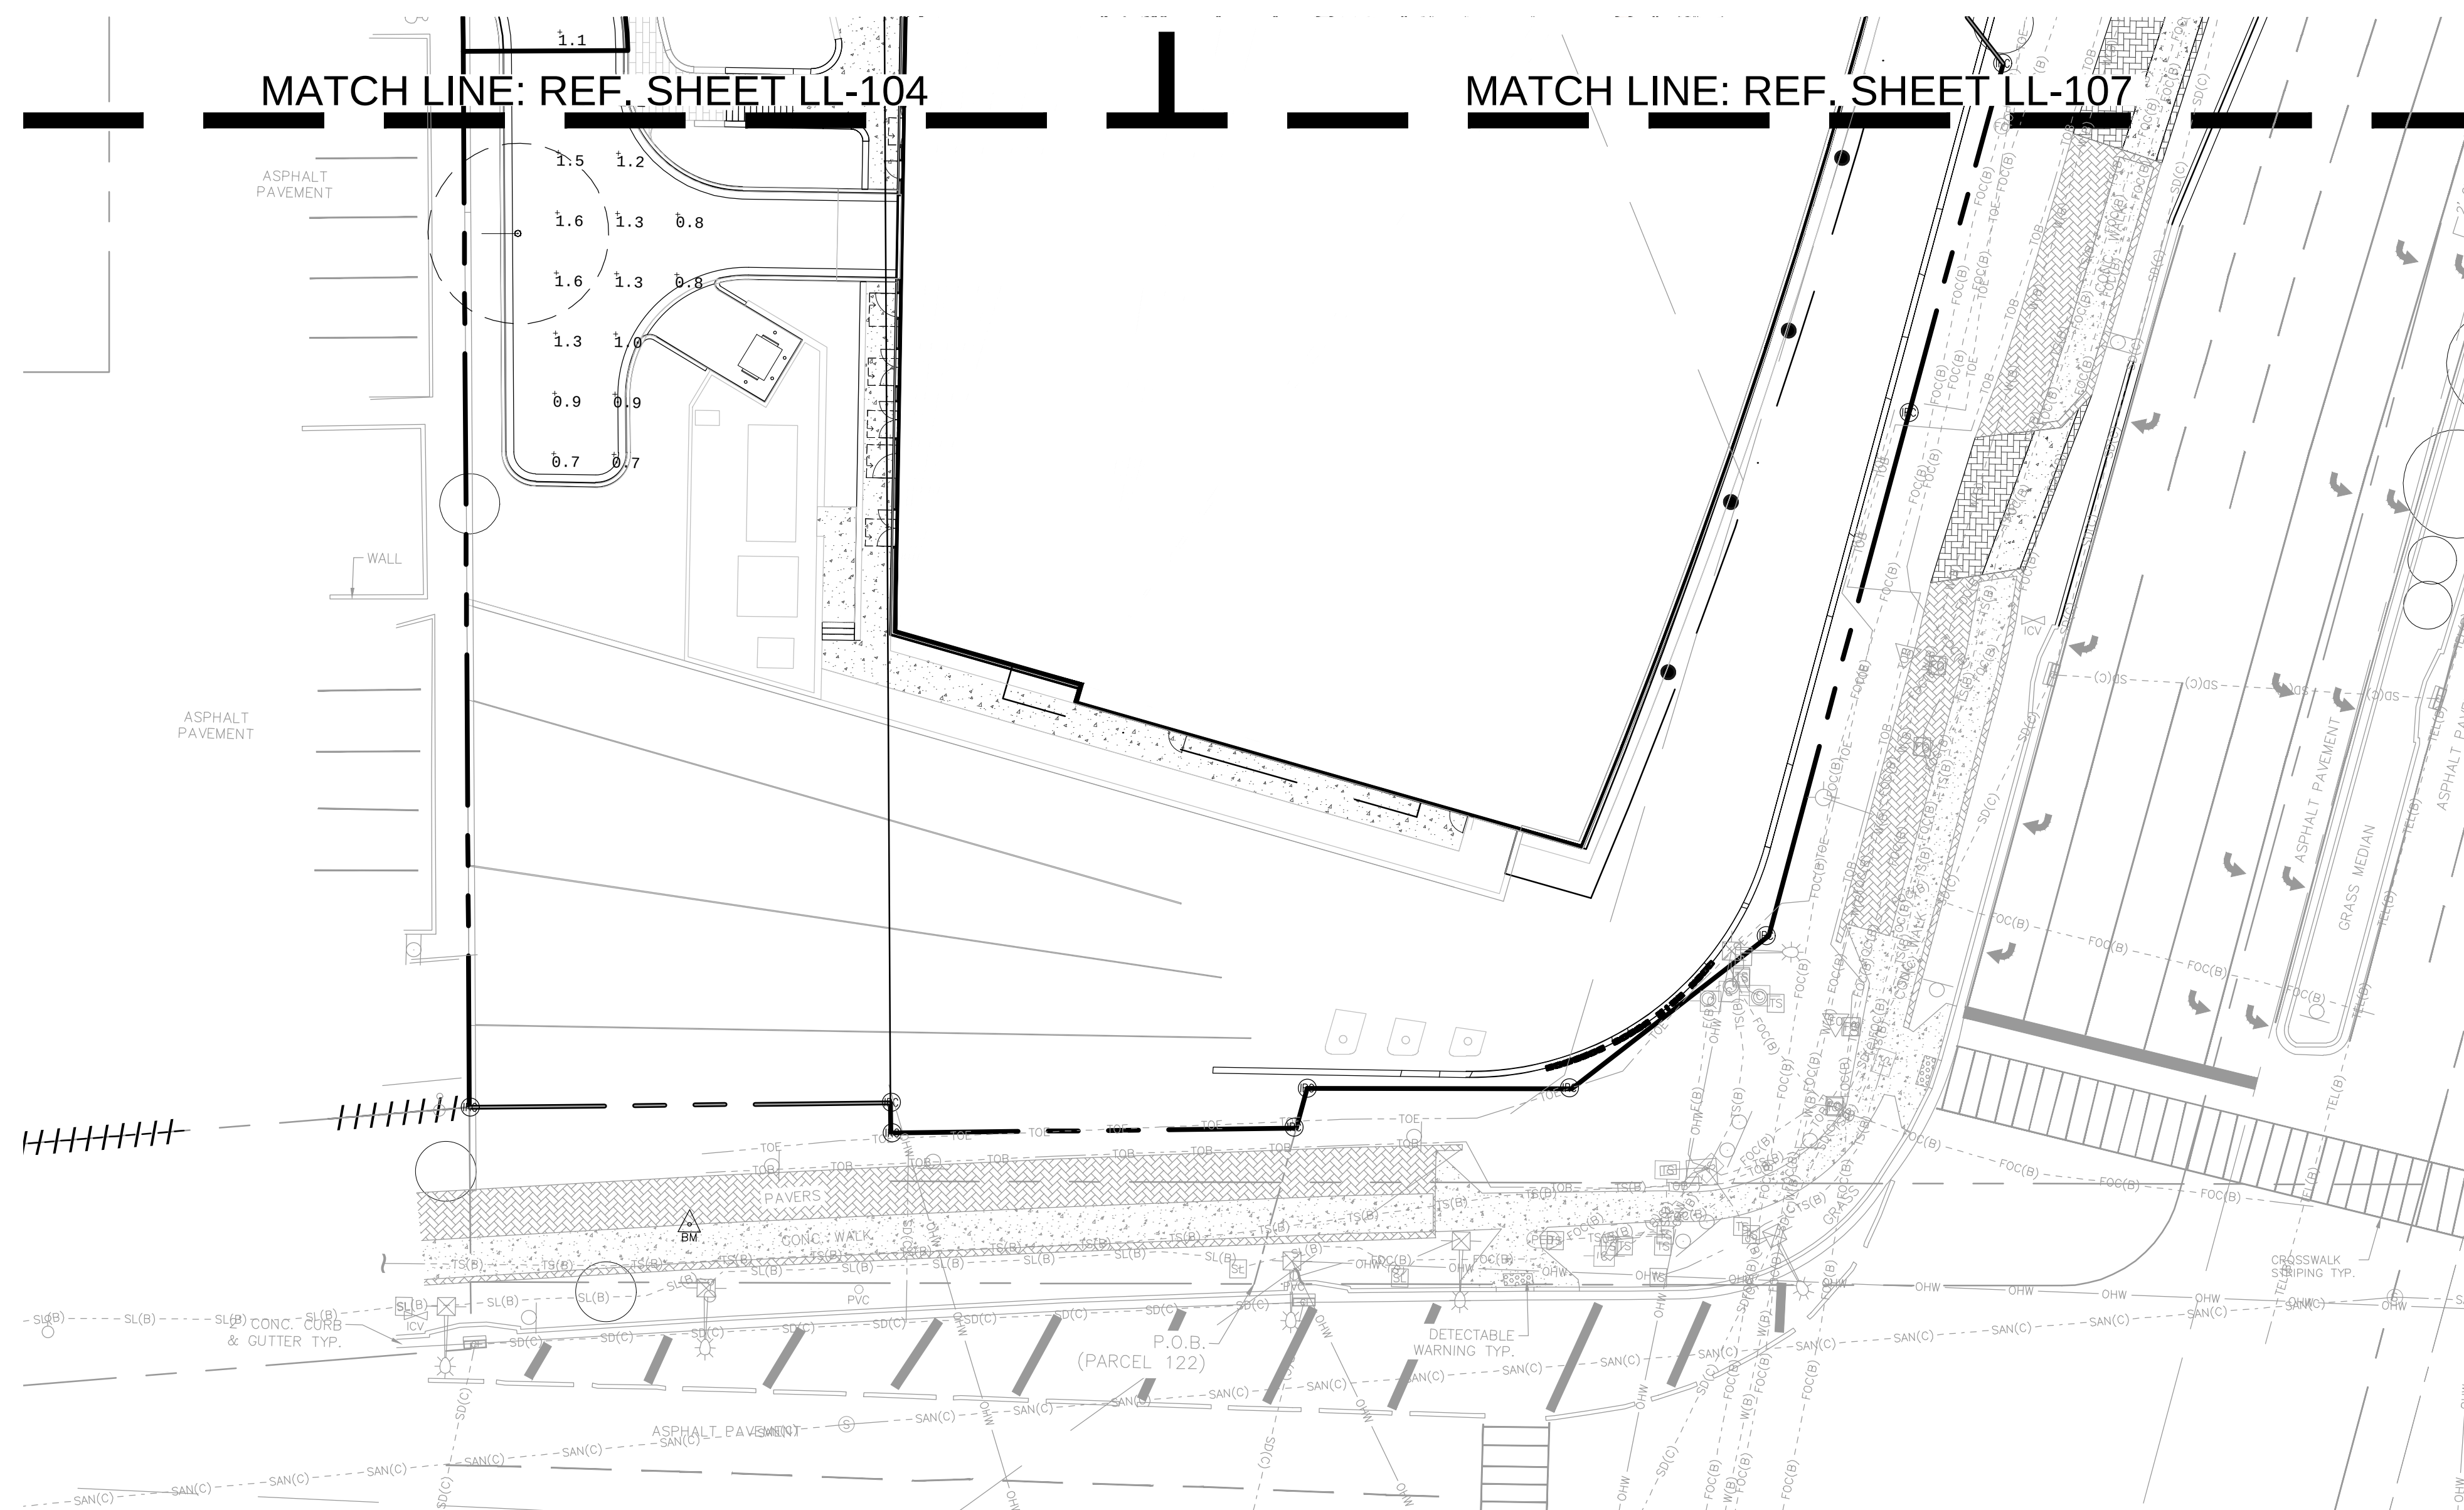

Luminaire Schedule								
Symbol	Qty	Label	Arrangement	Lum. Lumens	LLD	Luminaire Watts	Total Watts	Description
	24	L1	Single	6172	1.000	54.4	1305.6	LUMEC RN20-SW23LED-4K-C3-ACRD-E2R-UNV-DAG (POLE MTD 30' A

Calculation Summary								
Label	CalcType	Units	Avg	Max	Min	Avg/Min	Max/Min	Grid Z
ROADWAY	Illuminance	Fc	1.09	2.1	0.5	2.18	4.20	0

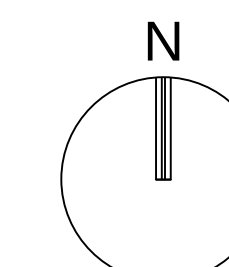


GRAPHIC SCALE

0 20



SCALE: 1" = 20'

 NOTE: PRINTED DRAWING SIZE
MAY HAVE CHANGED FROM
ORIGINAL. VERIFY SCALE USING
BAR SCALE ABOVE.



PZ26-12000001
08/05/2026

Drawing name: H:\15083.00 - DOWNTOWN POMPIANO - RP Development LLC\Landscare Architecture\CAD\15083.00-LL-1XX.dwg

STATISTICS: DBEI IMINABV
