

REV.	DATE	DESCRIPTION
01	05-13-2025	DRC SUBMITTAL

ALL MEASUREMENTS MUST BE VERIFIED BEFORE BEGINNING THE WORK. NO MEASUREMENTS ARE TO BE SCALED DIRECTLY FROM THIS DRAWING.

Key section

Client


**VERA FUND**  
**NICK POLYUSHKIN**  
**& YURI KHARITONENKOV**  
TEL: 305.833.3303

Project

**1600 S FEDERAL HIGHWAY**  
**(MIXED-USE PROJECT)**

1600 SOUTH FEDERAL HIGHWAY,  
POMPAÑO BEACH, FL 33062

Title	
GROUND FLOOR PHOTOMETRICS	
Drawn <b>J. WU</b>	Field <b>ARCHITECTURE</b>
Verified <b>N. TREMBLAY</b>	Scale <b>as shown</b>
Approved <b>S. L'ECUYER</b>	Date <b>01-19-2026</b>
Project Manager <b>J. WU</b>	Dwg. no. <b>P-004</b>
Project <b>24-838</b>	

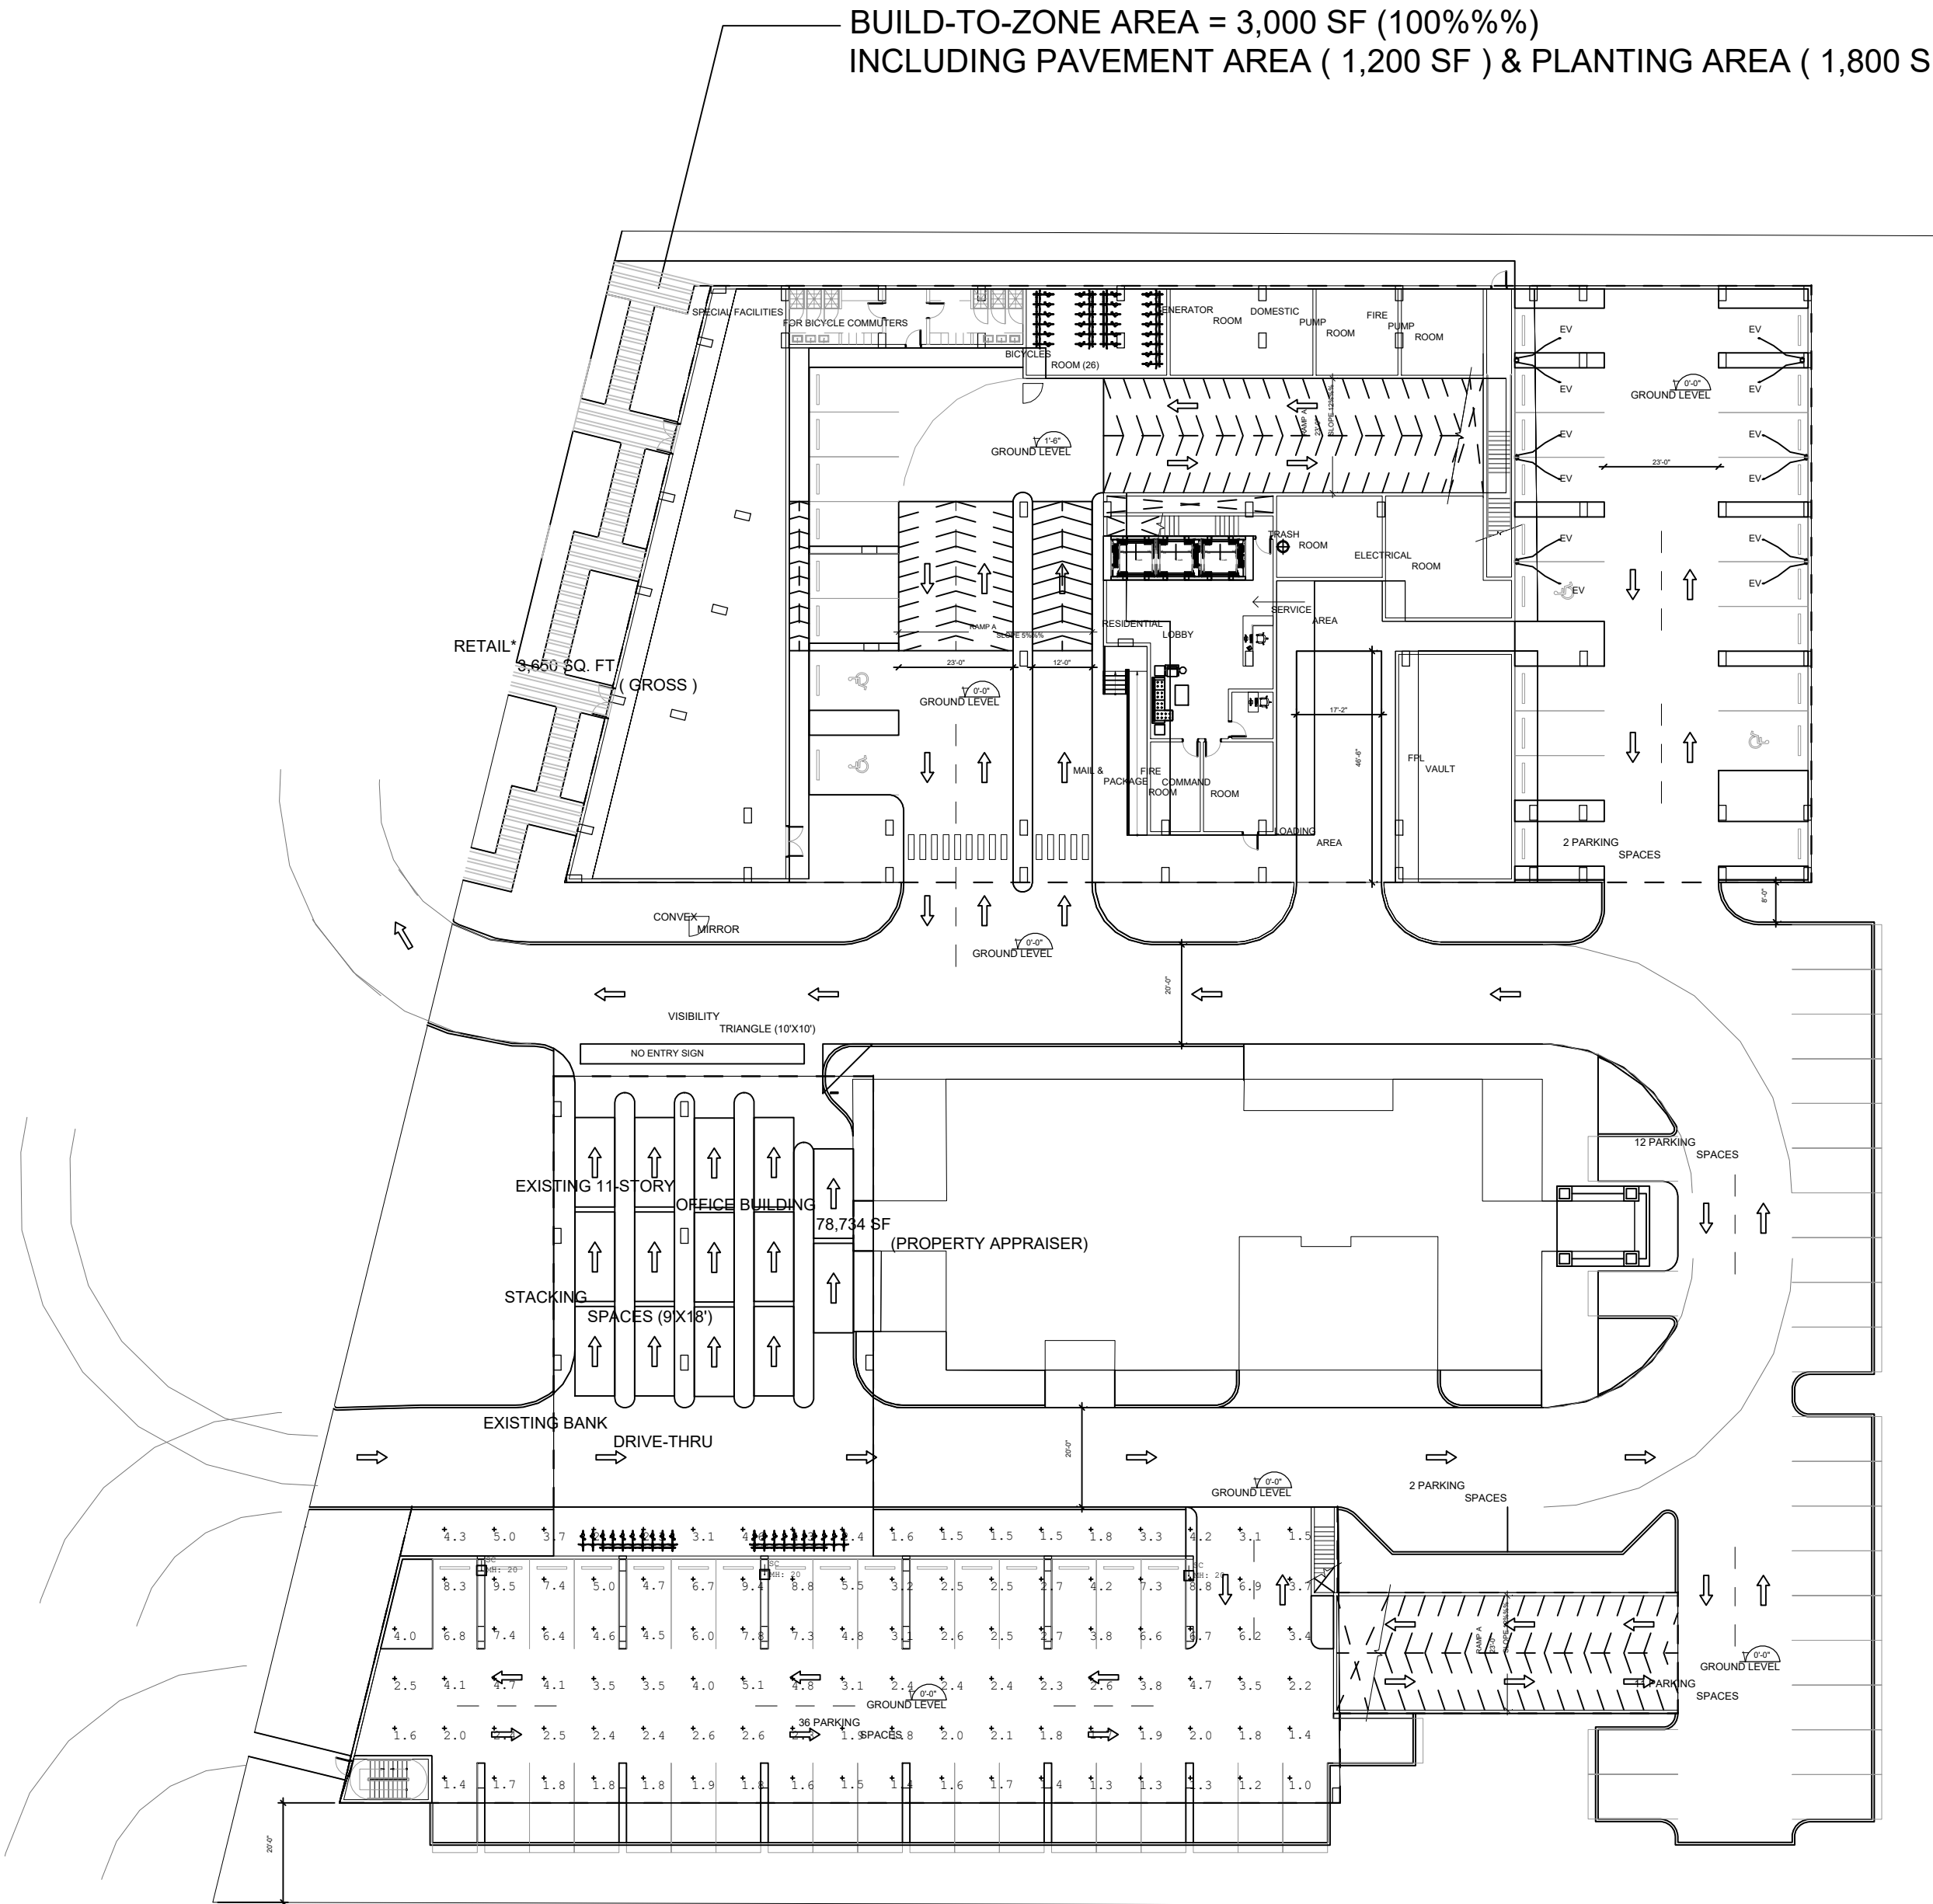

Luminaire Schedule						
Symbol	Qty	Label	Arrangement	Description	ILF	Luminaire Lumens
	3	SC	Single	VNTH-15000L-40R-4M	0.900	22428

Calculation Summary					
Label	CalcType	Units	Avg	Max	Min
Parking Garage Roof	Illuminance	Fc	3.50	9.5	1.0

Mounting height specified from finished grade of parking roof.