

DRC

PZ24-12000008
09/03/2025

DRC
PZ24- 12000008
12/17/2025

DRC

PZ24-12000008
01/15/2025

GCE
GANEM CONSULTING ENGINEERING
FL. CA. #31187 FL. PE. #74745
15805 BISCAYNE BLVD., SUITE 105
NORTH MIAMI BEACH, FL. 33160
TEL: (786) 916-6546
info@ganemos.com

KEYPLAN

Alioskar
Ganem
Osorio
Digitally signed by
Alioskar Ganem
Osorio
Date: 2024.12.02
12:14:38 -05'00'

CONSULTING ENGINEER



ALIOSKAR GANEM P.E.
FL. LIC. NO. 74745

ECO POMPAHO TOWNHOME
DEVELOPMENT

3223 NE 5TH ST, POMPAHO
BEACH, FL. 33062 UNIT 1

NOTES/COMMENTS

1	06-07-24
3	11-01-24


REVISIONS / SUBMISSIONS

DRAWN BY: AG
CHECKED BY: AG
INITIAL DRAWING
RELEASE DATE: ISSUE DATE

ROOF FLOOR PLAN

DRC

PZ24-12000008
01/15/2025

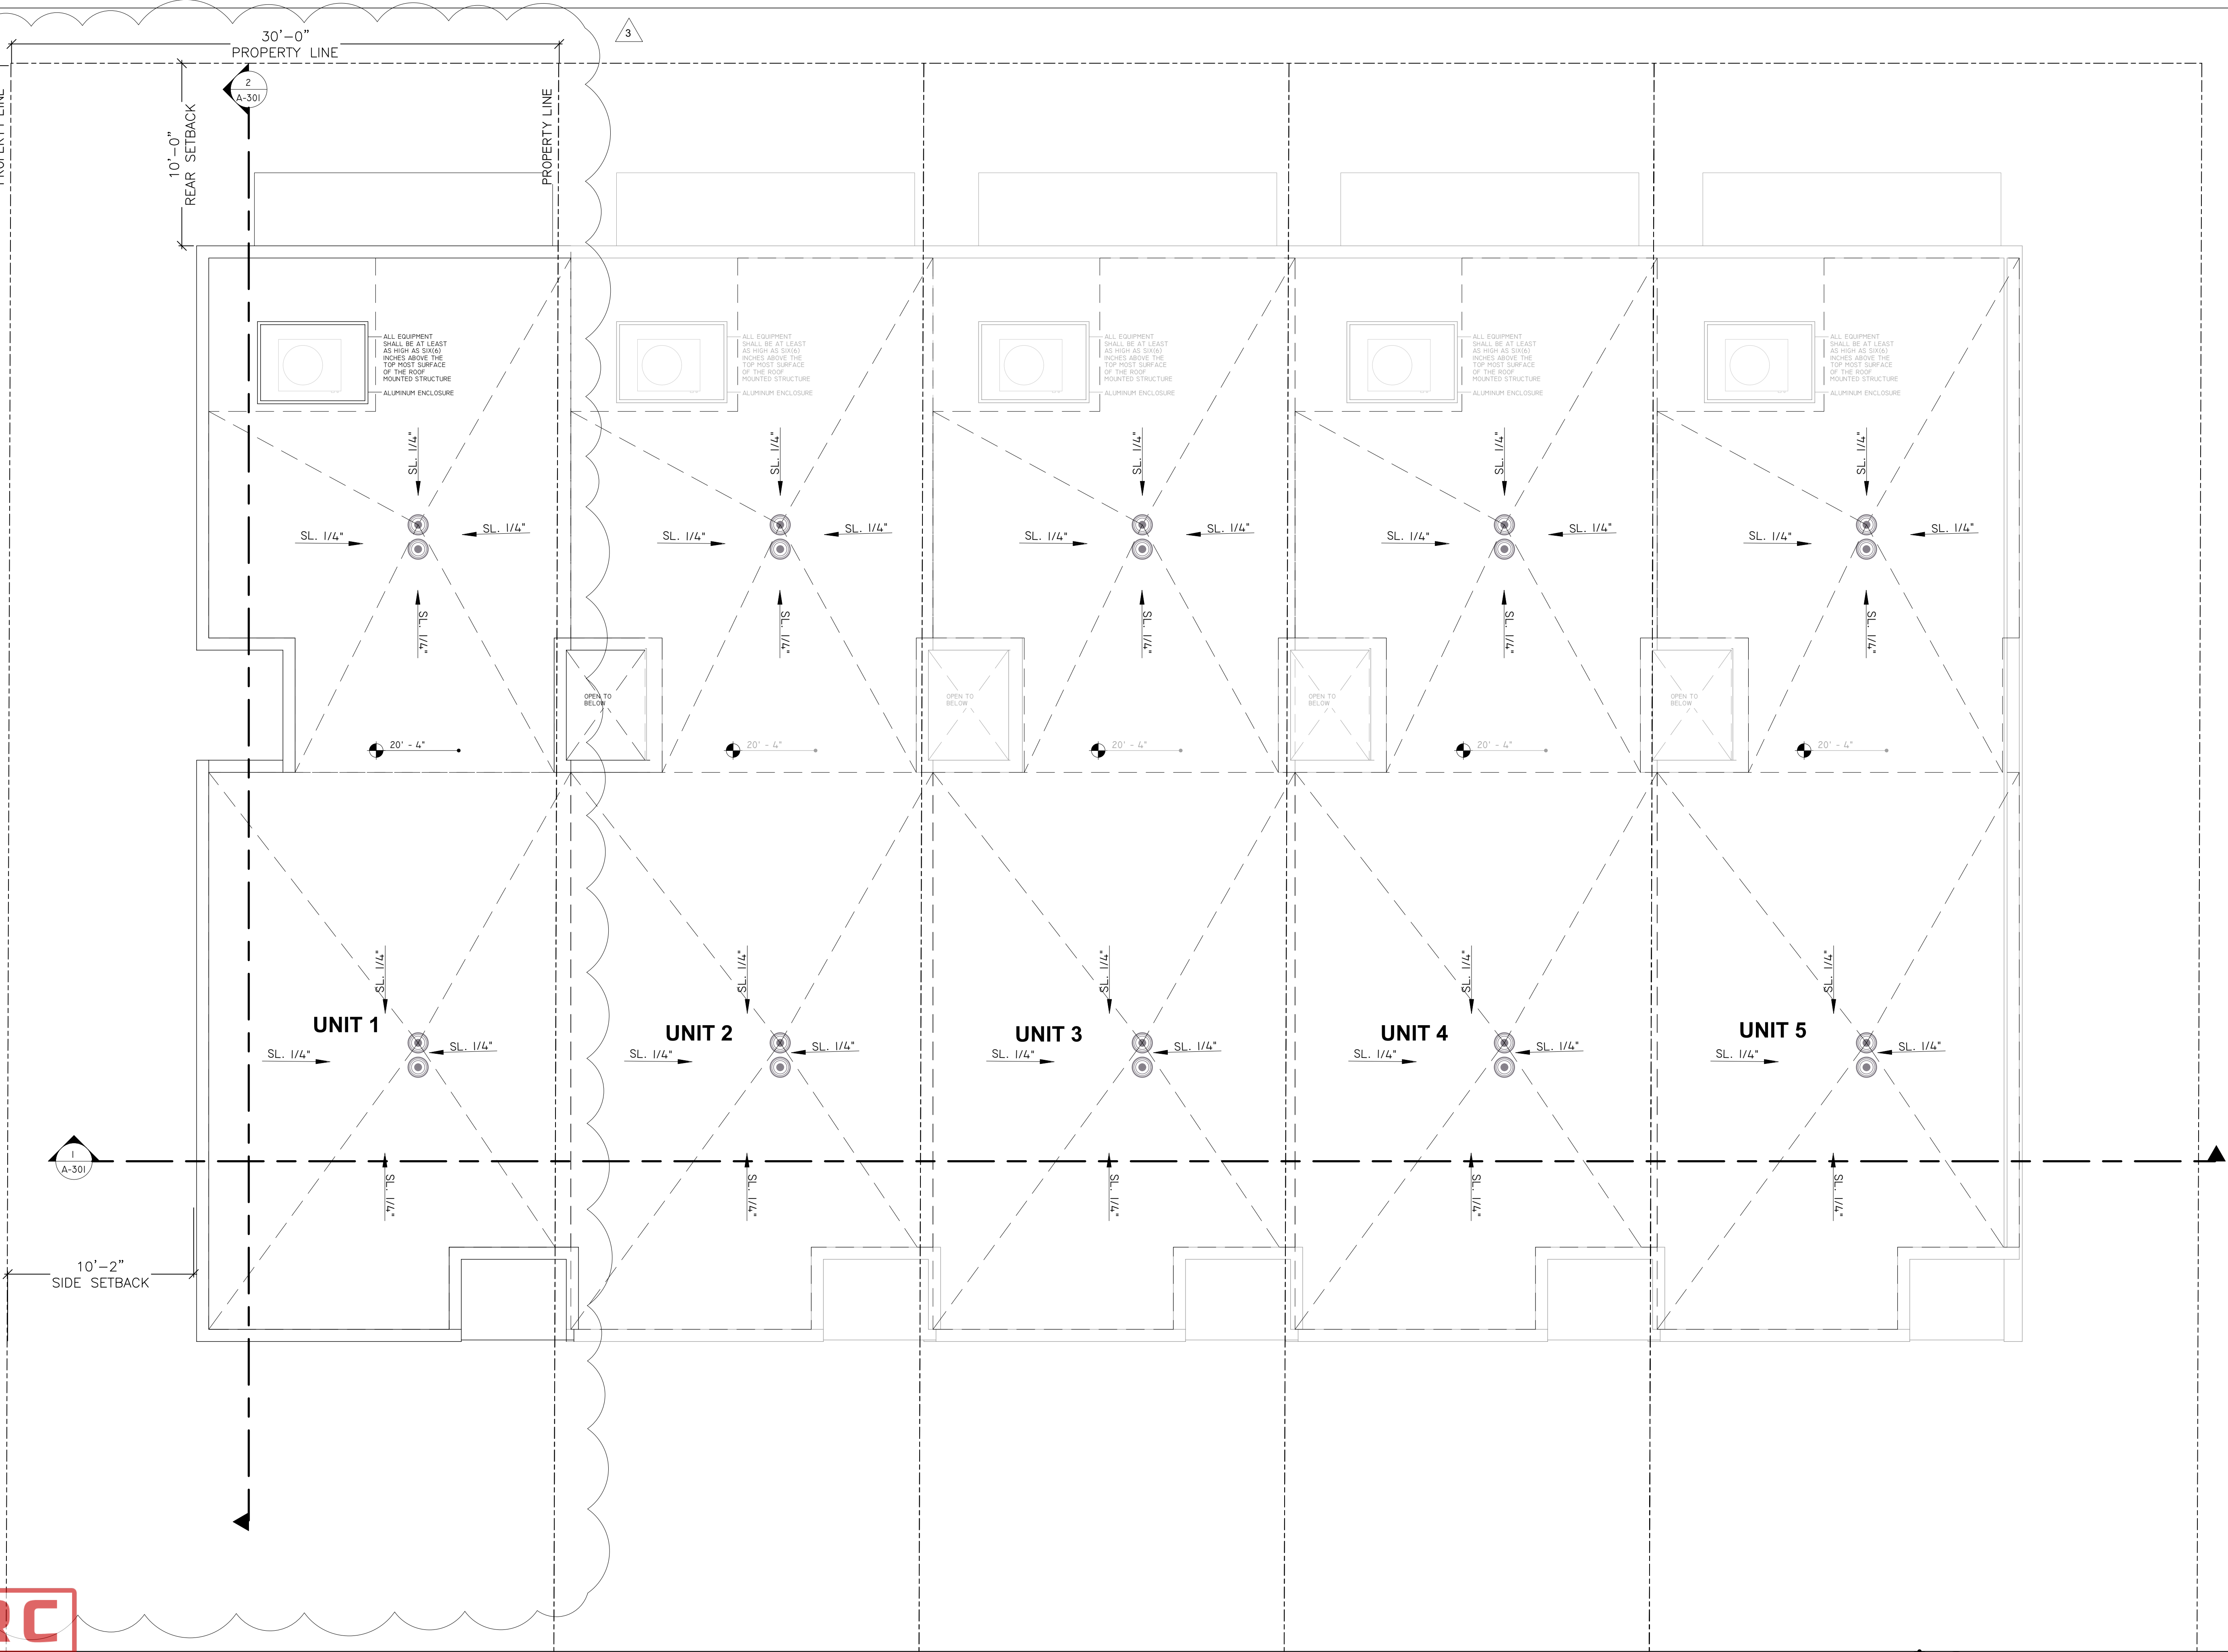

T.O. ROOF
1/4" = 1'-0"