

ABBREVIATIONS:
R= EXISTING TO BE RELOCATED
N= NEW CIRCUIT
UC= UNDER CABINET
C= COUNTER TOP LEVEL
BC= BELOW COUNTER
M= MOUNTED
GFI= GROUND FAULT INTERRUPTER
V= VERIFY PRIOR TO INSTALLATION
PB= PUSH BUTTON
VP= VAPOR PROOF
WP= WEATHER PROOF
EL= EXTERIOR LIGHTS
M= MOUNTED
PO= POP OUT OUTLET


R307.7 STAIRWAY ILLUMINATION:
ALL INTERIOR AND EXTERIOR STAIRWAY SHALL BE PROVIDED WITH MEANS TO ILLUMINATE THE STAIR, INCLUDING THE LANDING AND TREADS. INTERIOR STAIRWAYS SHALL BE PROVIDED WITH AN ARTIFICIAL LIGHT SOURCE LOCATED IN THE IMMEDIATE VICINITY OF EACH LANDING OR STAIR WAY. ALL LIGHTS MUST PROVIDE MIN 1 FOOT CANDLE AT INTERIOR OR EXTERIOR STAIRS

DETERIORATING AGENTS, (NEC 110.11): ALL DISCONNECTS, SERVICE DISCONNECTS, RECEPTACLES, LUMINAIRES, APPLIANCES SHALL BE LISTED FOR THE ENVIRONMENT AND SHALL BE LABELED WP OR NEMA 3-R

LIGHTING IN THE THERMAL ENVELOPE SHALL BE IC RATED AND MEETING ASTM E 283 FOR LEAKAGE LABELED AIR TIGHT AND HOUSING SHALL BE SEALED WITH A GASKET OR CAULK TO CEILING OR WALL, R402.4

FOR EXACT TV OUTLETS REFER TO ARCHITECTURAL ID PLANS.

ELECTRICAL LEGEND	
SYMBOL	DESCRIPTION
	CEILING MOUNTED LIGHTS
	VAPOR PROOF MOUNTED LIGHTS
	CEILING MOUNTED LIGHTS
	DUPLEX RECEPTACLE- UNDER CABINET GFI
	DUPLEX RECEPTACLE
	RECEPTACLE GROUND FAULT INTERRUPTER
	FLOOR RECEPTACLE
	DUPLEX RECEPTACLE- UNDER CABINET
	240 VOLT RECEPTACLE
	LIGHTS TRANSFORMER
	THERMOSTAT
	WALL SWITCH (3-WAY)
	WALL SWITCH (SINGLE, DOUBLE)
	WALL MOUNTED LIGHTS FIXTURE
	JUNCTION BOX
	EXHAUST FAN
	DISPOSAL
	CEILING MOUNTED SMOKE DETECTOR
	MOTION SENSOR LIGHTS-WATER PROOF
	EXTERIOR CEILING LIGHTS
	EXTERIOR WALL MOUNTED LIGHTS-WATER PROOF
	WALL MOUNTED LIGHTS-WATER PROOF
	TELEPHONE/CABLE OUTLET
	TV OUTLET
	DISCONNECT SWITCH
	ELECTRICAL METER
	ELECTRICAL PANEL
	INSTANT WATER HEATER
	SMOKE DETECTOR + MONOXIDE COMBO

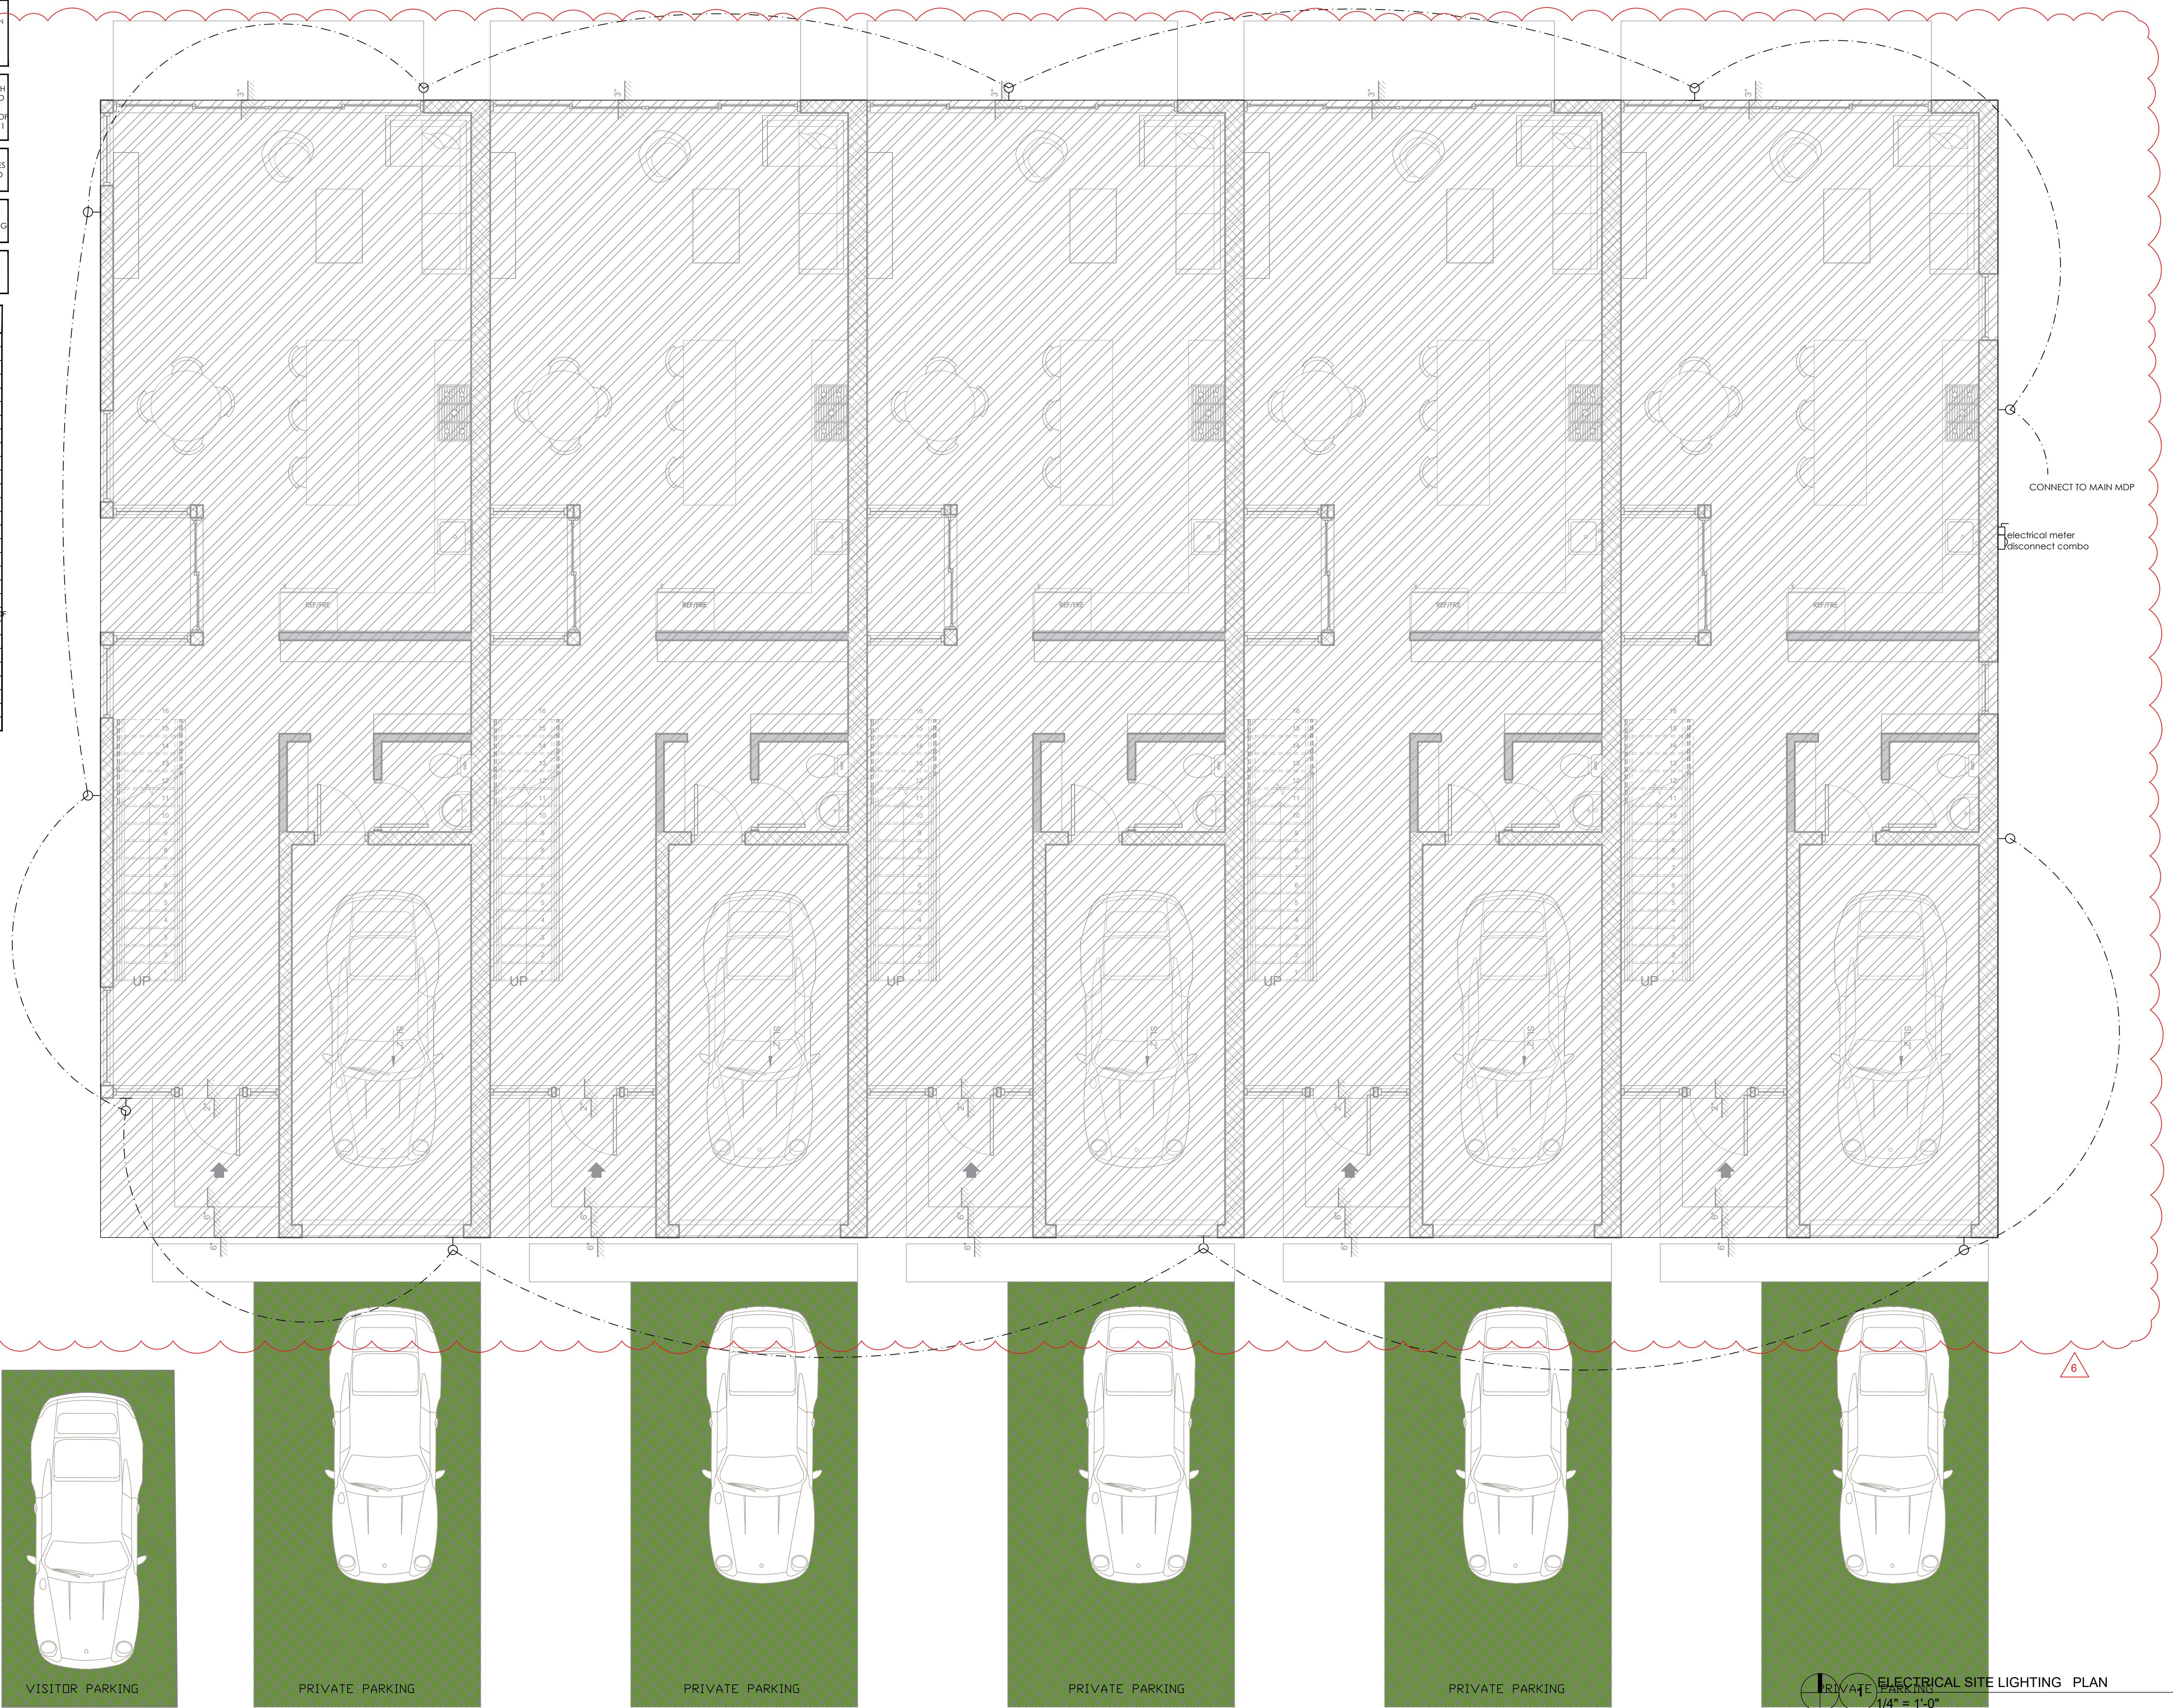

GCE
GANEM CONSULTING ENGINEERING
FL. CA. K31187 • FL. PE. #74745
18200 NE 19th Ave, SUITE 105
NORTH MIAMI BEACH, FL. 33162
TEL: (786) 916-6546
fax: (305) 848-9318
alioskar@ganemco.com

KEY PLAN

CONSULTING ENGINEER

ALIOSKAR GANEM
P.E. FL. LIC. No. 74745

PROJECT NAME:
NEW RESIDENCE

PROJECT ADDRESS:
3223 NE 5TH ST, POMPANO BEACH, FL. 33062 UNIT 1
3225 NE 5TH ST, POMPANO BEACH, FL. 33062 UNIT 2
3227 NE 5TH ST, POMPANO BEACH, FL. 33062 UNIT 3
3229 NE 5TH ST, POMPANO BEACH, FL. 33062 UNIT 4
3231 NE 5TH ST, POMPANO BEACH, FL. 33062 UNIT 5

REVISIONS	DATE
5	06-06-25
6	10-14-2025

Project No:
Scale:
Date:
Drawn:
Checked:
CAD File:

Drawing Title:

E-2