

DRC

PZ24-12000008  
09/03/2025

DRC

PZ24-12000008  
01/15/2025

GANEM CONSULTING ENGINEERING  
FL. C.A. #31187 FL. PE. #74745  
15805 BISCAYNE BLVD. SUITE 105  
NORTH MIAMI BEACH, FL. 33160  
TEL: (786) 916-6546  
info@ganemce.com

KEYPLAN

Alioskar  
Ganem  
Osorio

Digitally signed by  
Alioskar Ganem  
Osorio  
Date: 2024.12.02  
13:08:34 -05'00'

CONSULTING ENGINEER



ALIOSKAR GANEM P.E.  
FL. LIC. No. 74745

ECO POMPANO TOWNHOME  
DEVELOPMENT

3231 NE 5TH ST, POMPANO  
BEACH, FL. 33062 UNIT 5

NOTES/COMMENTS

1 06-07-24

3 11-01-2024

REVISIONS / SUBMISSIONS


DRAWN BY: AG  
CHECKED BY: AG  
INITIAL DRAWING  
RELEASE DATE: ISSUE DATE

ROOF FLOOR PLAN

A-107.5

DRC

PZ24-12000008  
01/15/2025

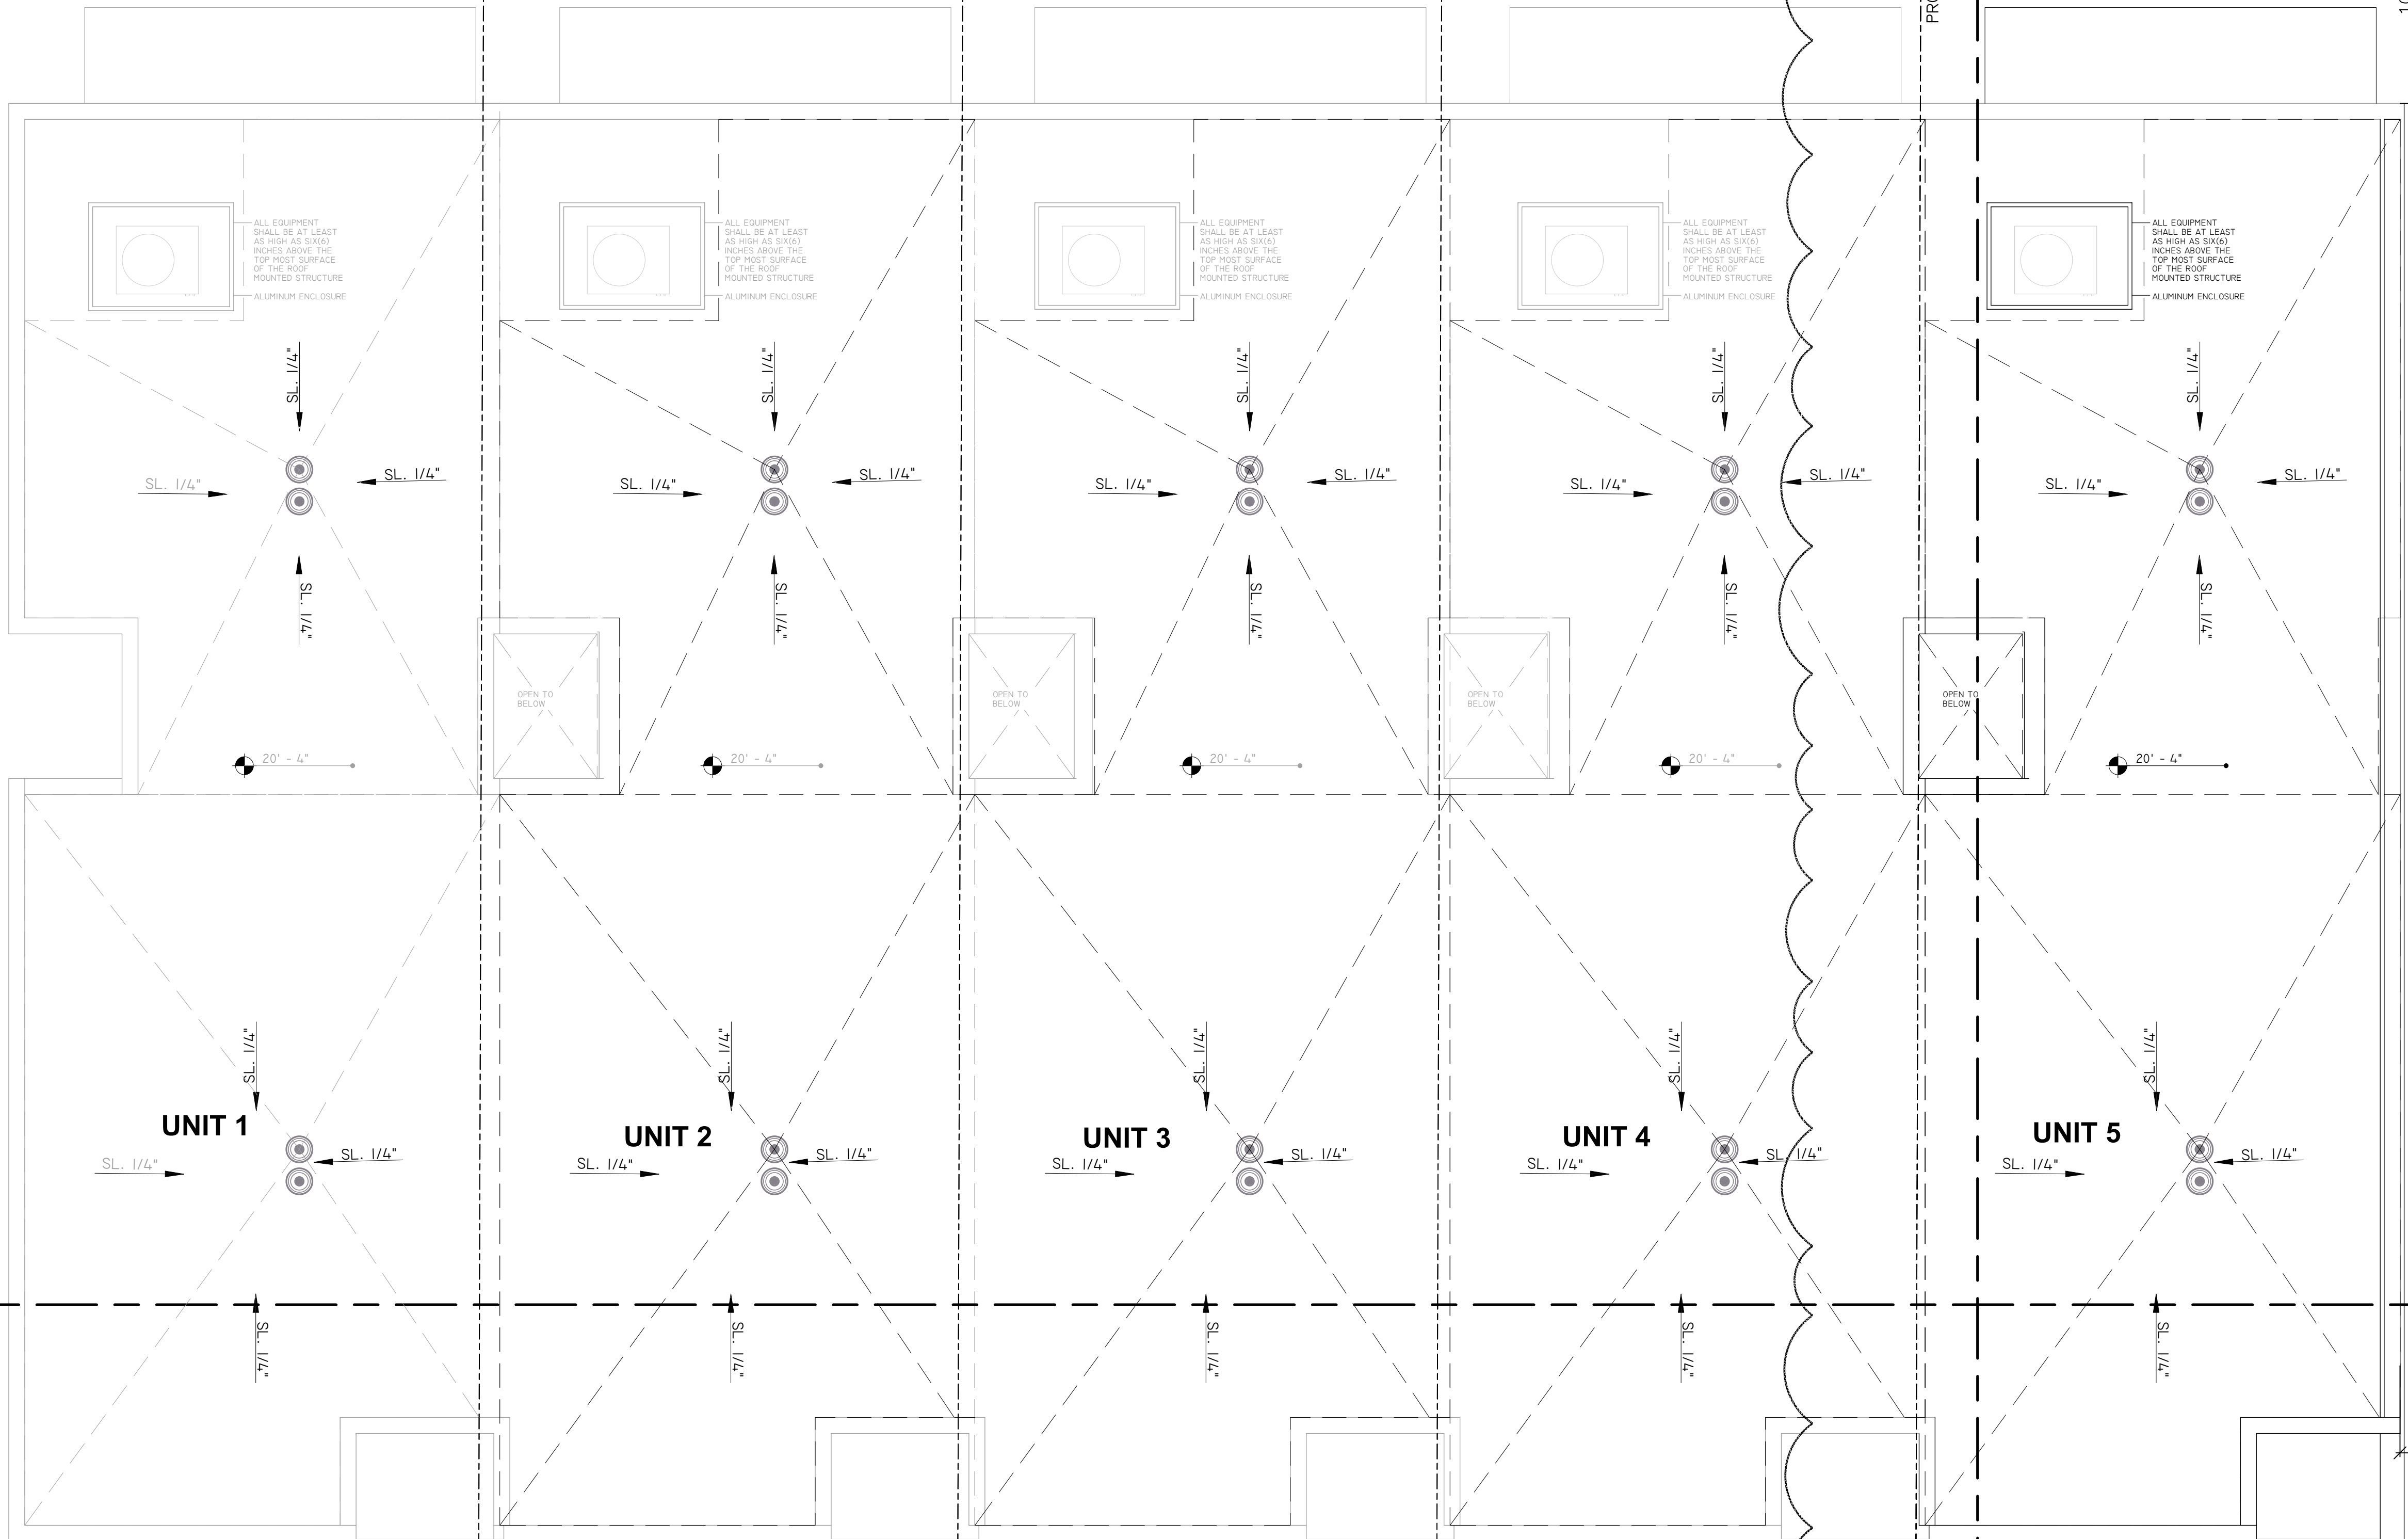

1 T.O. ROOF  
1/4" = 1'-0"

DRC

PZ24-12000008  
12/17/2025