
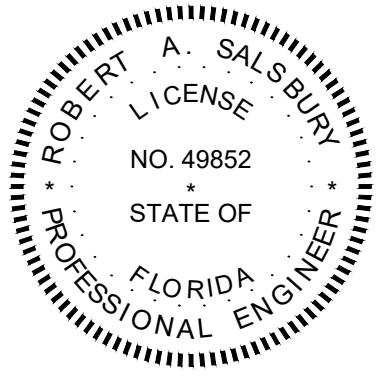


Calculation Summary							
Label	CalcType	Units	Avg	Max	Min	Avg/Min	Max/Min
New Parking	Illuminance	Fc	4.47	10.3	1.0	4.47	10.30
Property Line	Illuminance	Fc	0.20	0.5	0.0	N.A.	N.A.


Luminaire Schedule

Symbol	Qty	Label	Arrangement	Description	LLF	Luminaire Lumens	Luminaire Watts	Total Watts
	1	P-5-1	Single	Cree # OSQL-C-40L-40K7-5M-XX-NM-XX	0.900	40000	236	1180
	3	P-5-2	Back-Back	Cree # OSQL-C-40L-40K7-5M-XX-NM-XX	0.900	40000	236	472
	3	P-4-HSS	SINGLE	Cree # OSQX-C-50L-40K7-4M-UL-w-OSQ-BLSXF	0.900	40500	383	1149
	3	P-4-10 HSS	SINGLE	Cree # OSQX-C-50L-40K7-4M-UL-w-OSQ-BLSXF / 10 Degree Tilt	0.900	40500	383	1149

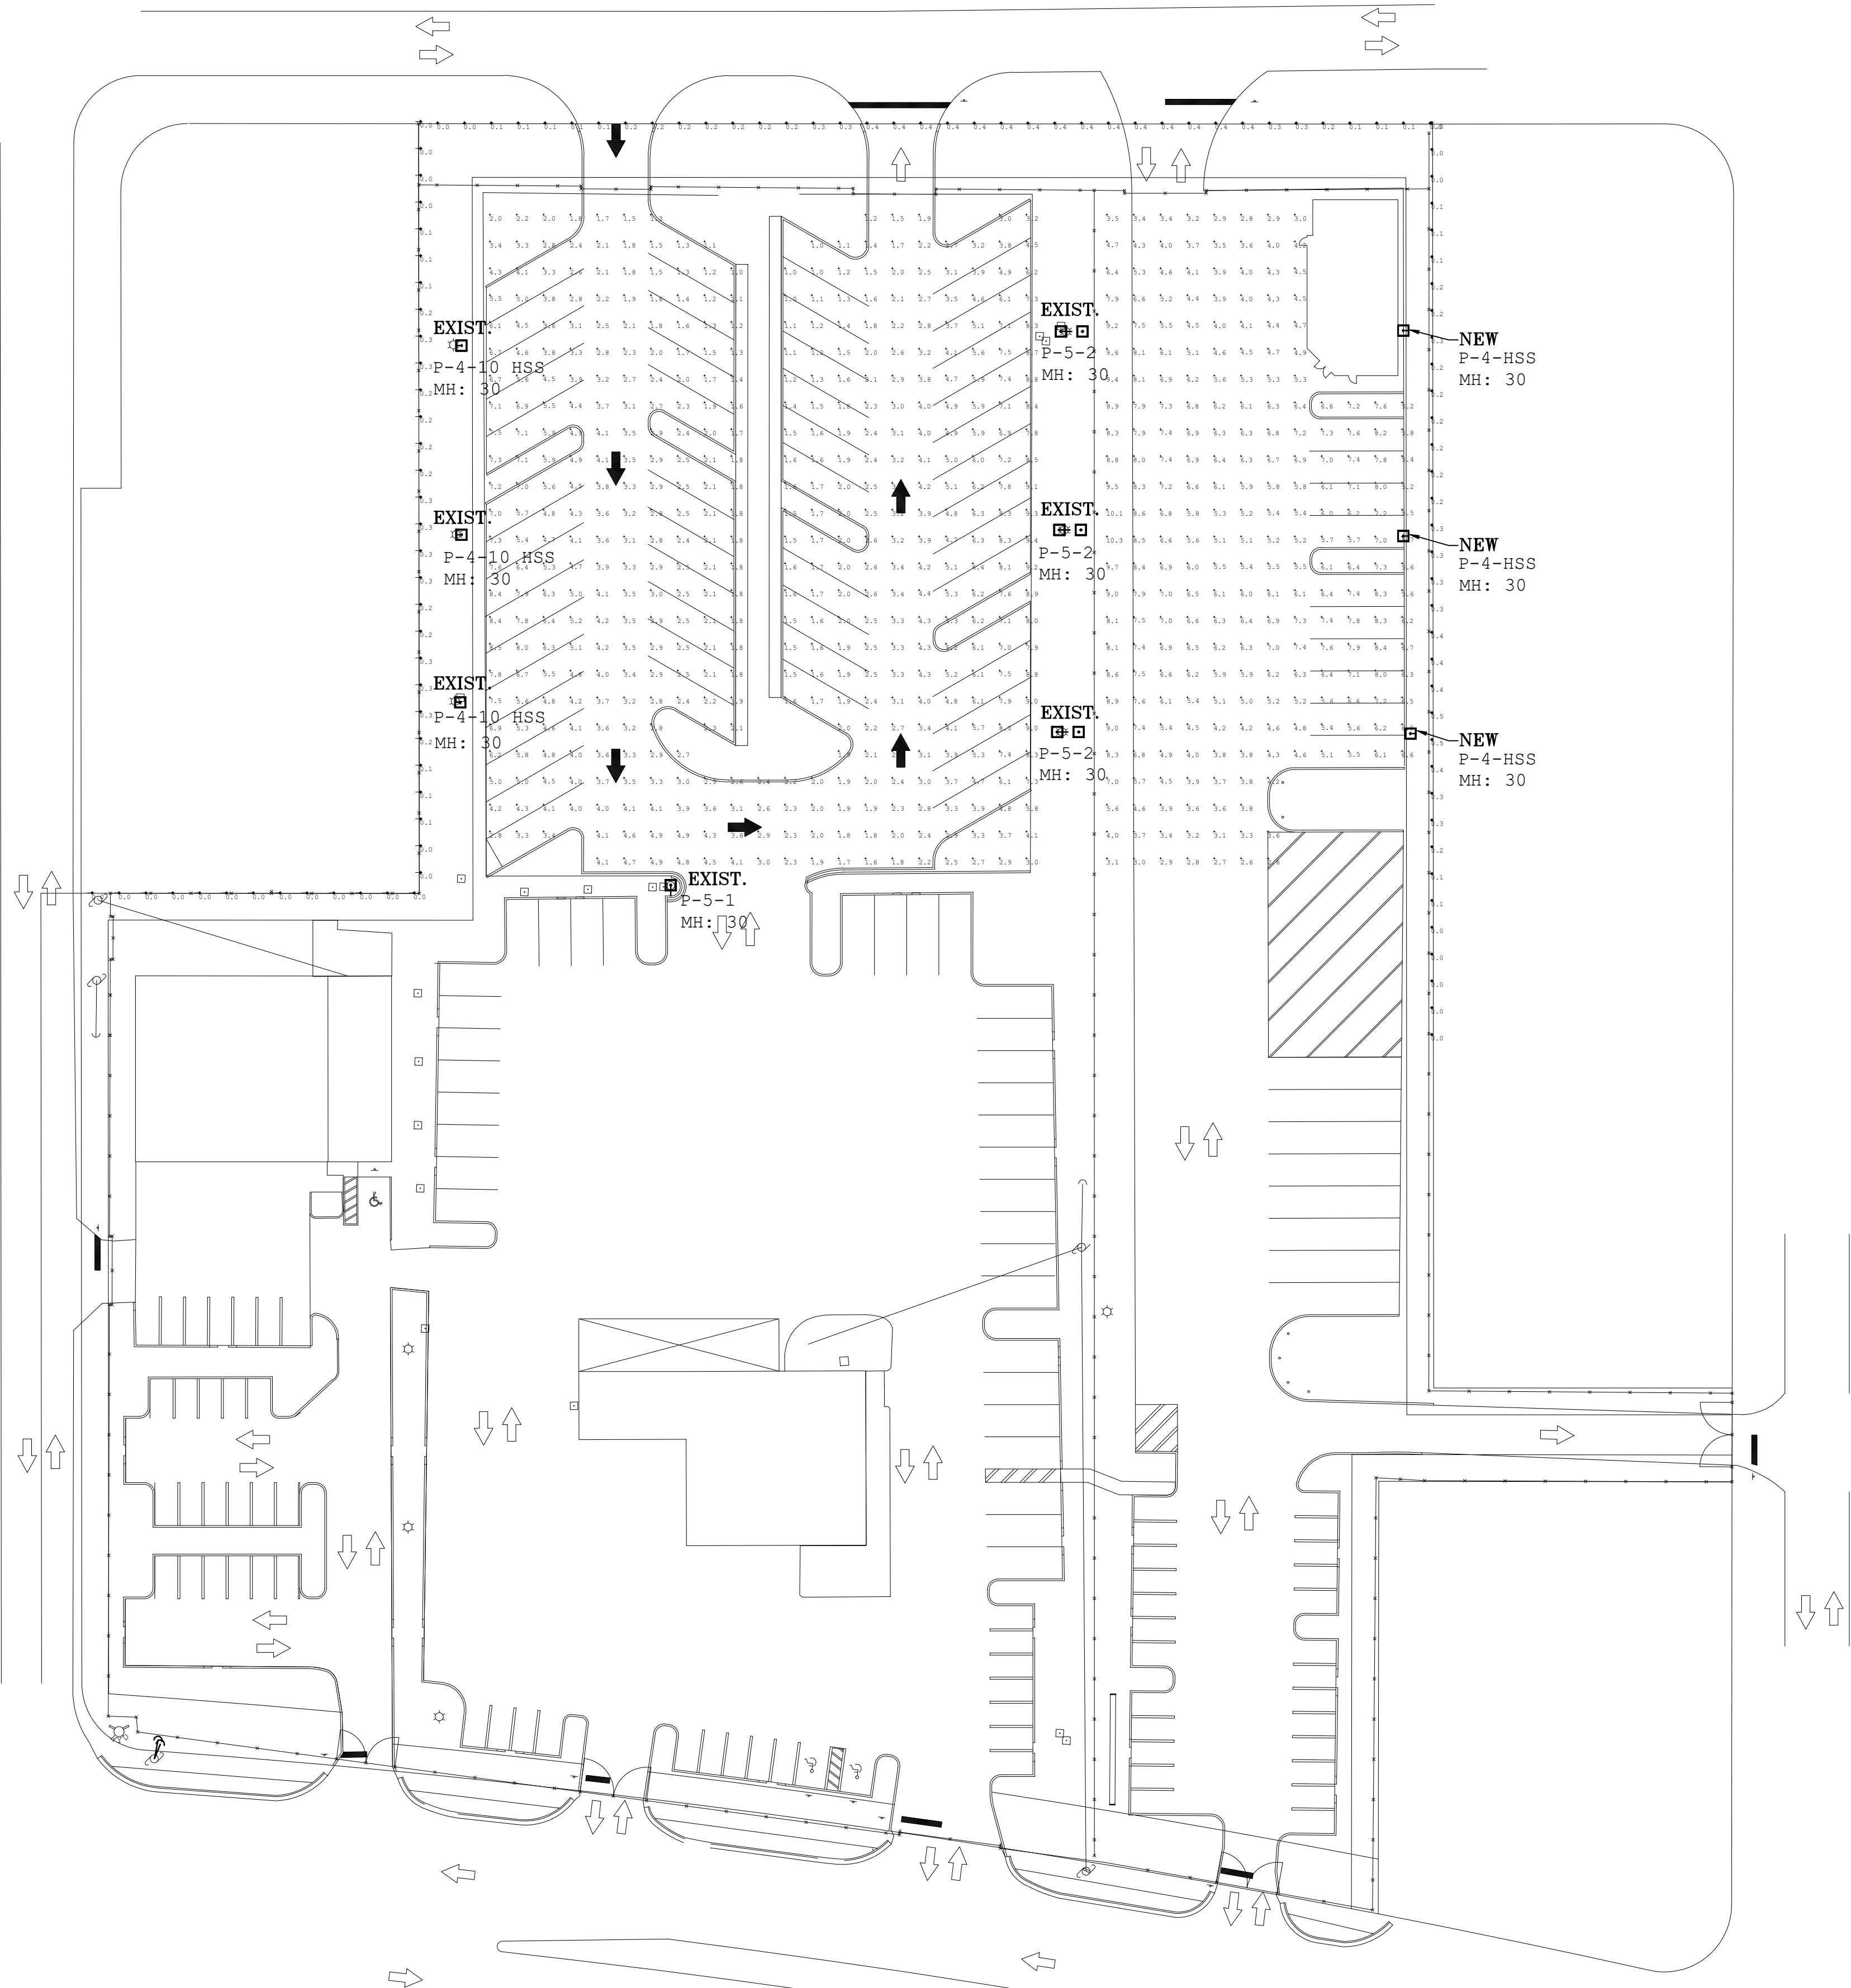

This item has been electronically signed and sealed by Robert A. Salisbury, P.E. 49852 on the date adjacent to the seal using a Digital signature.

Printed copies of this document are not considered signed and sealed and the signature must be verified on any electronic copies.

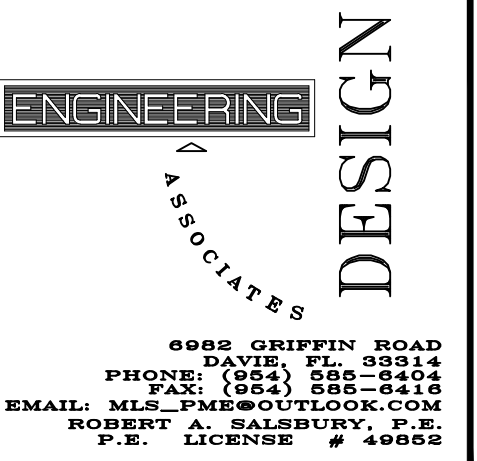

SEAL:

PROJECT TITLE

COASTAL RECYCLING OF
POMPANO COASTAL 16-CNG
2407 HAMMONVILLE ROAD PB
POMPANO BEACH, FLORIDA 33069

DATE ISSUED
05.19.26

REVISIONS - DATE



SHEET TITLE

PHOTOMETRIC
SITE PLAN

PROJECT NO: E-497	CHECKED BY: M.L.S.
SCALE: AS NOTED	DRAWN BY: EDA

SHEET NO.

E-1

Photometric Site Plan

Scale: 1" = 40'-0"

