



Luminaire Schedule								
Symbol	Qty	Label	Arrangement	Description	LLF	Luminaire	Luminaire Watts	Total Watts
	1	P-5-1	Single	Cree # OSQL-C-40L-40K7-5M-XX-NM-XX	0.900	40000	236	1180
	3	P-5-2	Back-Back	Cree # OSQL-C-40L-40K7-5M-XX-NM-XX	0.900	40000	236	472
	3	P-4-HSS	SINGLE	Cree # OSQX-C-50L-40K7-4M-UL-w-OSQ-BLSXF	0.900	40500	383	1149
	3	P-4-10 HSS	SINGLE	Cree # OSQX-C-50L-40K7-4M-UL-w-OSQ-BLSXF / 10 Degree Tilt	0.900	40500	383	1149

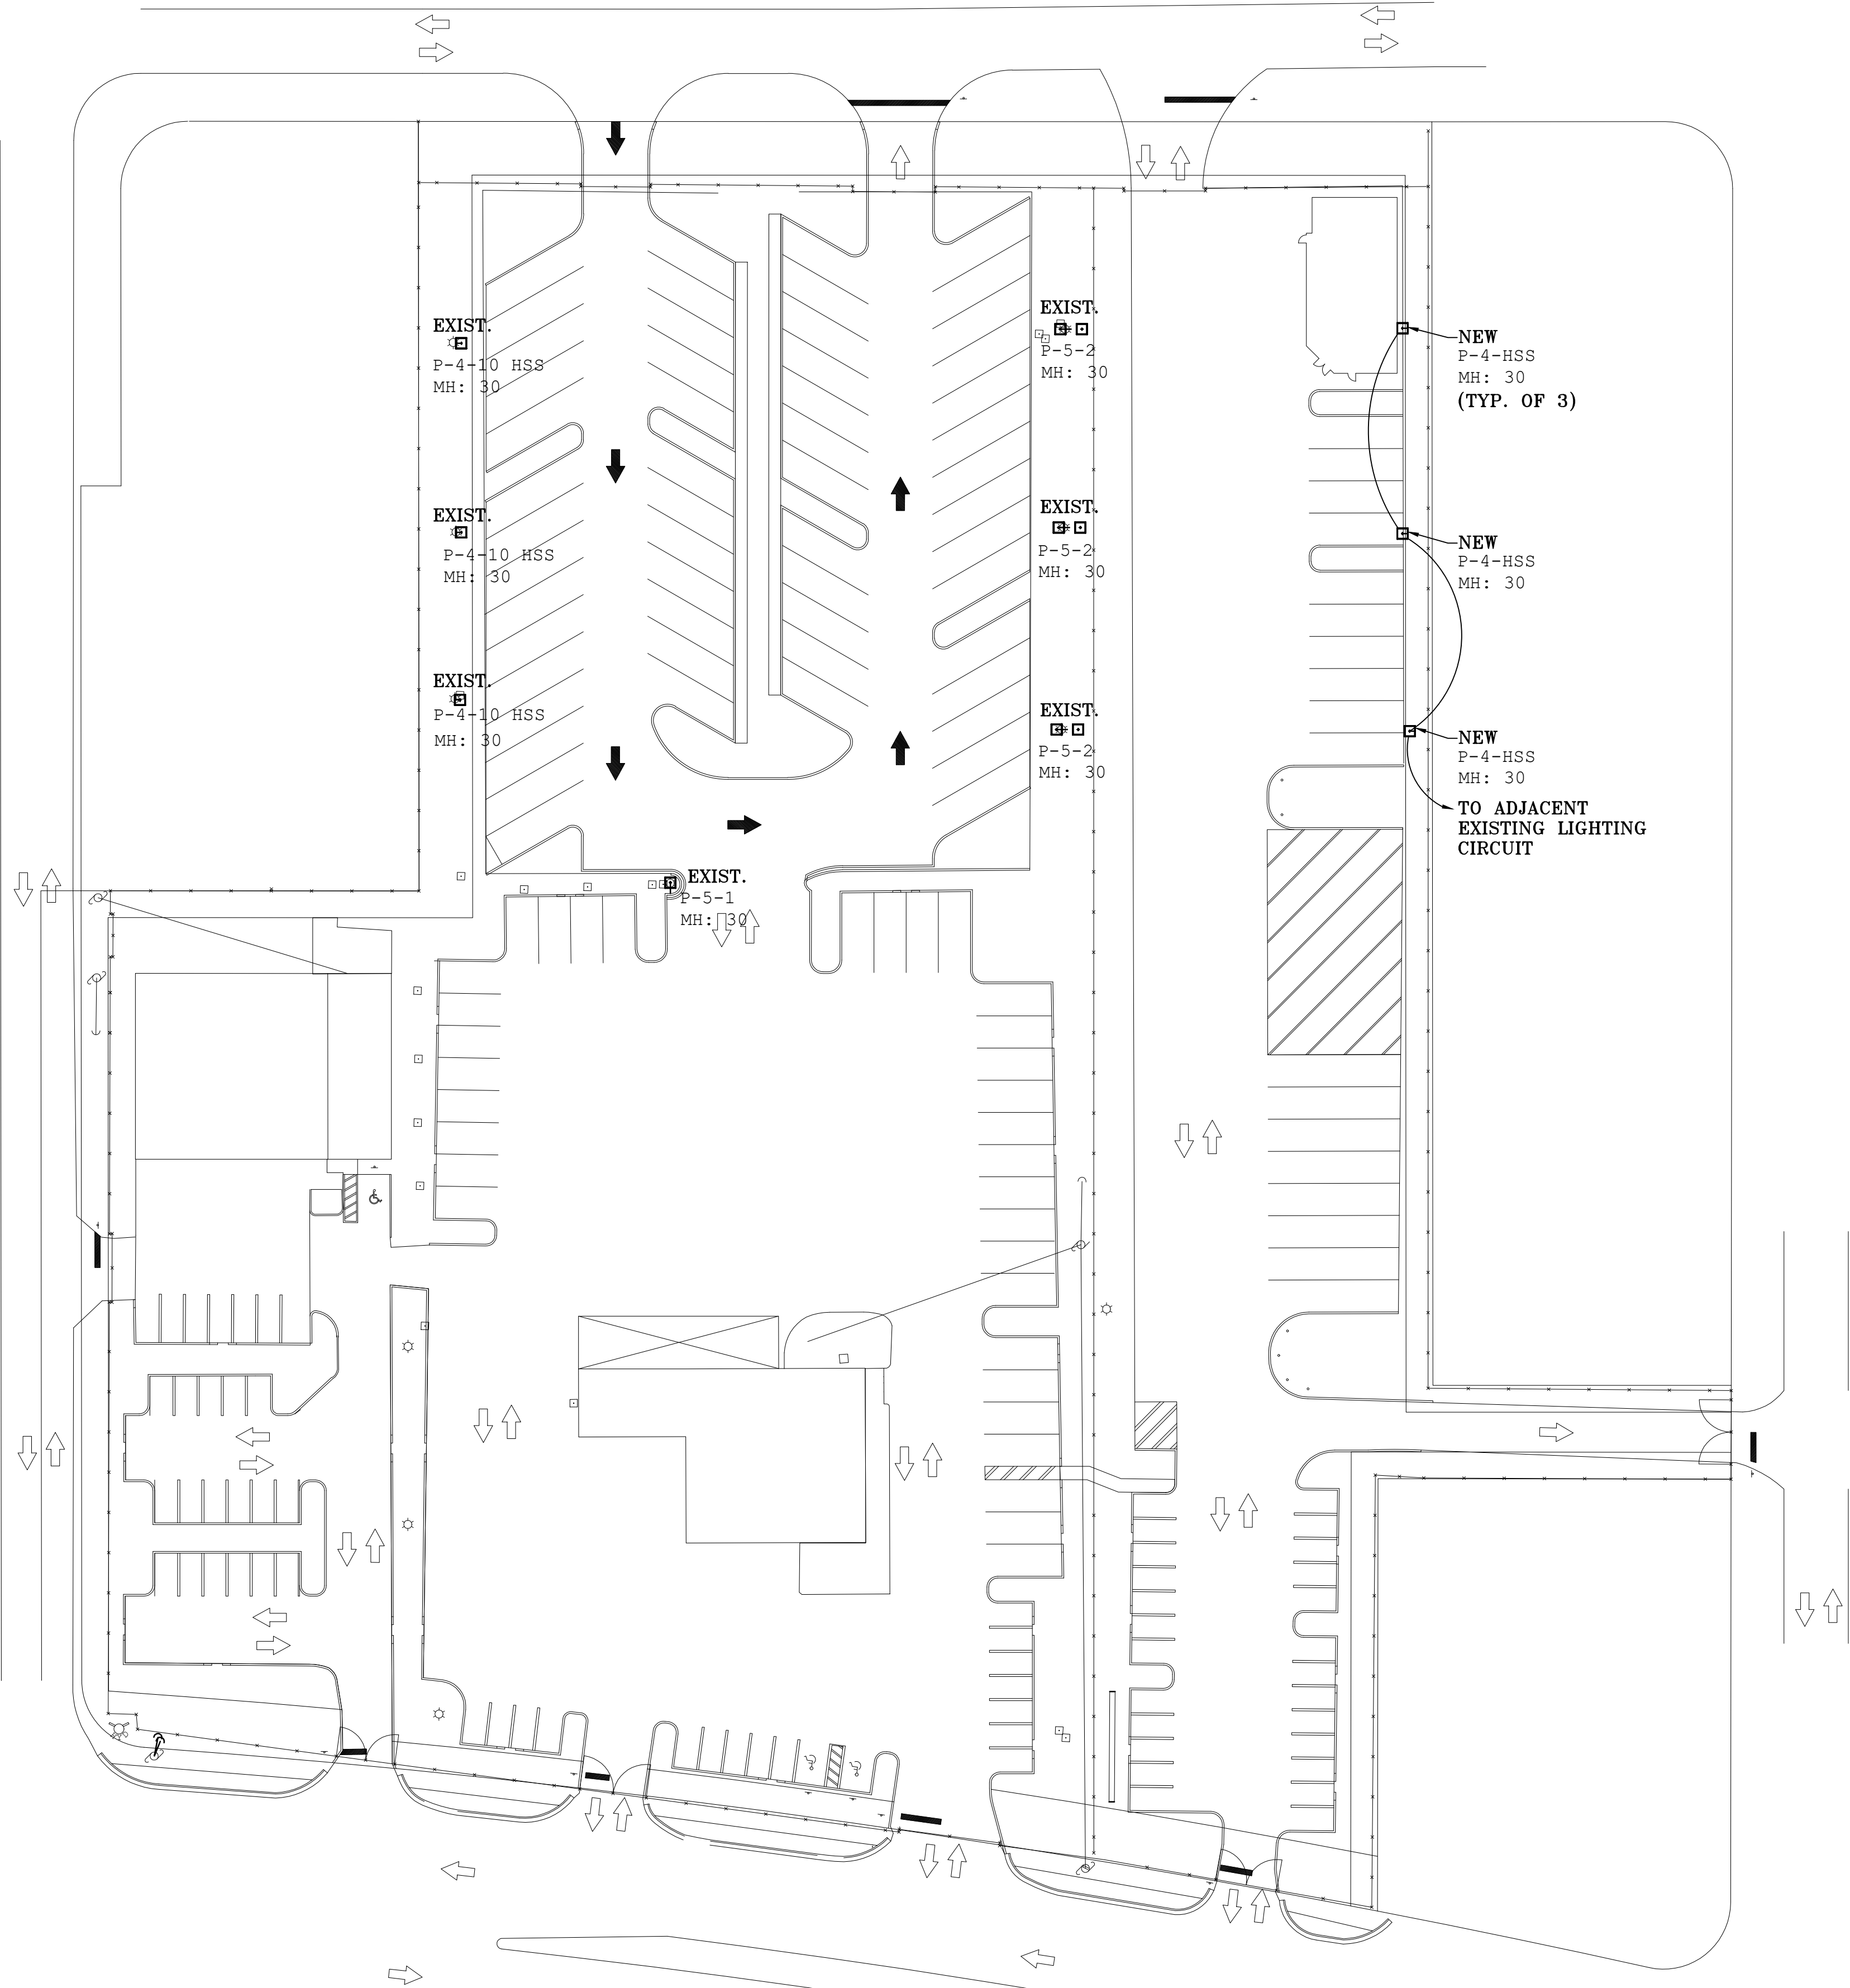

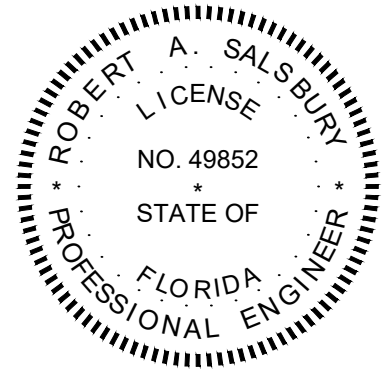

This item has been electronically signed and sealed by Robert A. Salisbury, PE 49852 on the date adjacent to the seal using a Digital signature.

Printed copies of this document are not considered signed and sealed and the signature must be verified on any electronic copies.

SEAL:

PROJECT TITLE

COASTAL RECYCLING OF
POMPANO COASTAL 16-CNG
2407 HAMMONVILLE ROAD PB
POMPANO BEACH, FLORIDA 33069

DATE ISSUED	
05.19.26	
REVISIONS - DATE	
△	
△	
△	
△	
△	
△	
△	

SHEET TITLE

SITE POWER PLAN

PROJECT NO.
E-497

CHECKED BY:
M.L.S.

SCALE:
AS NOTED

DRAWN BY:
EDA

SHEET NO.

E-2