
 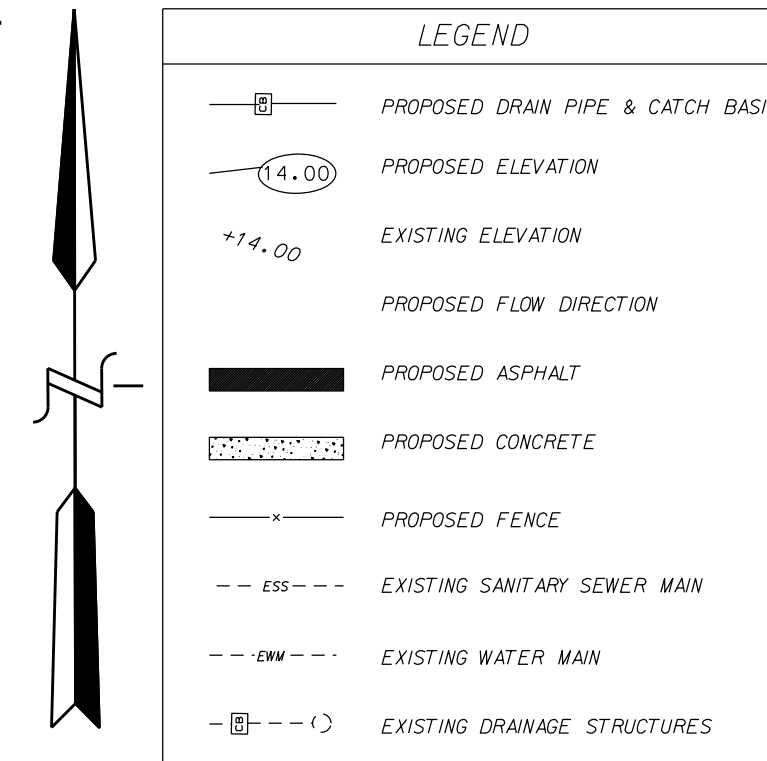




ABBREVIATIONS

BGR	BROWARD COUNTY RECORDS
BSE	BASE FLOOD ELEVATION
BFP	BACKFLOW PREVENTOR
C & G	CURB & GUTTER
C	CATCH BASIN
CBS	CONCRETE BLOCK STUCCO
CLF	CHAIN LINK FENCE
CPP	CONCRETE POWER POLE
DE	DRAINAGE EASEMENT
EQ	EQUIPMENT CONCRETE PAD
EX.	EXISTING
FF FL	FINISHED FLOOR ELEVATION
FH	FIRE HYDRANT
HH	GATE VALVE
INV	HAND HOLE
INV	INVERT
PB, PG	PLAT BOOK & PAGE
P	PROPERTY LINE
R	RIGHT OF WAY
SDMH	STORM DRAIN MANHOLE
TPY.	TYPICAL
UE	UTILITY EASEMENT
W	WATER MAIN
WPP	WOOD POWER POLE
YD	YARD DRAIN

FLOOD_ZONE_DATA:

```

FLOOD_ZONE : X
BASE_FLOOD_ELEVATION : NA
HIGHEST_ADJACENT_GRADE : NA
COMMUNITY_PANEL # : 120055 (POMPANO BEACH)
FLOOD_PANEL # : 12011C0356J (WEST HALF)
                : 12011C0357J (EAST HALF)
EFFECTIVE_DATE : 07/31/24

```


ELEVATION NOTES

1. ALL ELEVATIONS SHOWN ON THIS PLAN ARE BASED ON THE NAVD 88 DATUM.



Call 811 or www.sunshine811.com two full business days before digging to have utilities located and marked.

Check positive response codes before you dig!

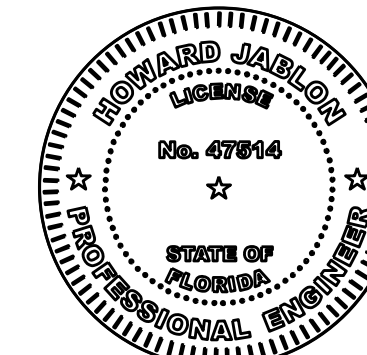

THIS ITEM HAS BEEN DIGITALLY SIGNED AND SEALED
BY HOWARD E JABLON ON THE DATE ADJACENT TO THE
SEAL.

PRINTED COPIES OF THIS DOCUMENT ARE NOT
CONSIDERED SIGNED AND SEALED AND THE SIGNATURE
MUST BE VERIFIED ON ANY ELECTRONIC COPIES.

SEAL:

HOWARD JABLON, PE
#47514

DATE:


06/15/26

DRAWING NO.

22-0111

SHEET NO.

E | PD2 OF 7

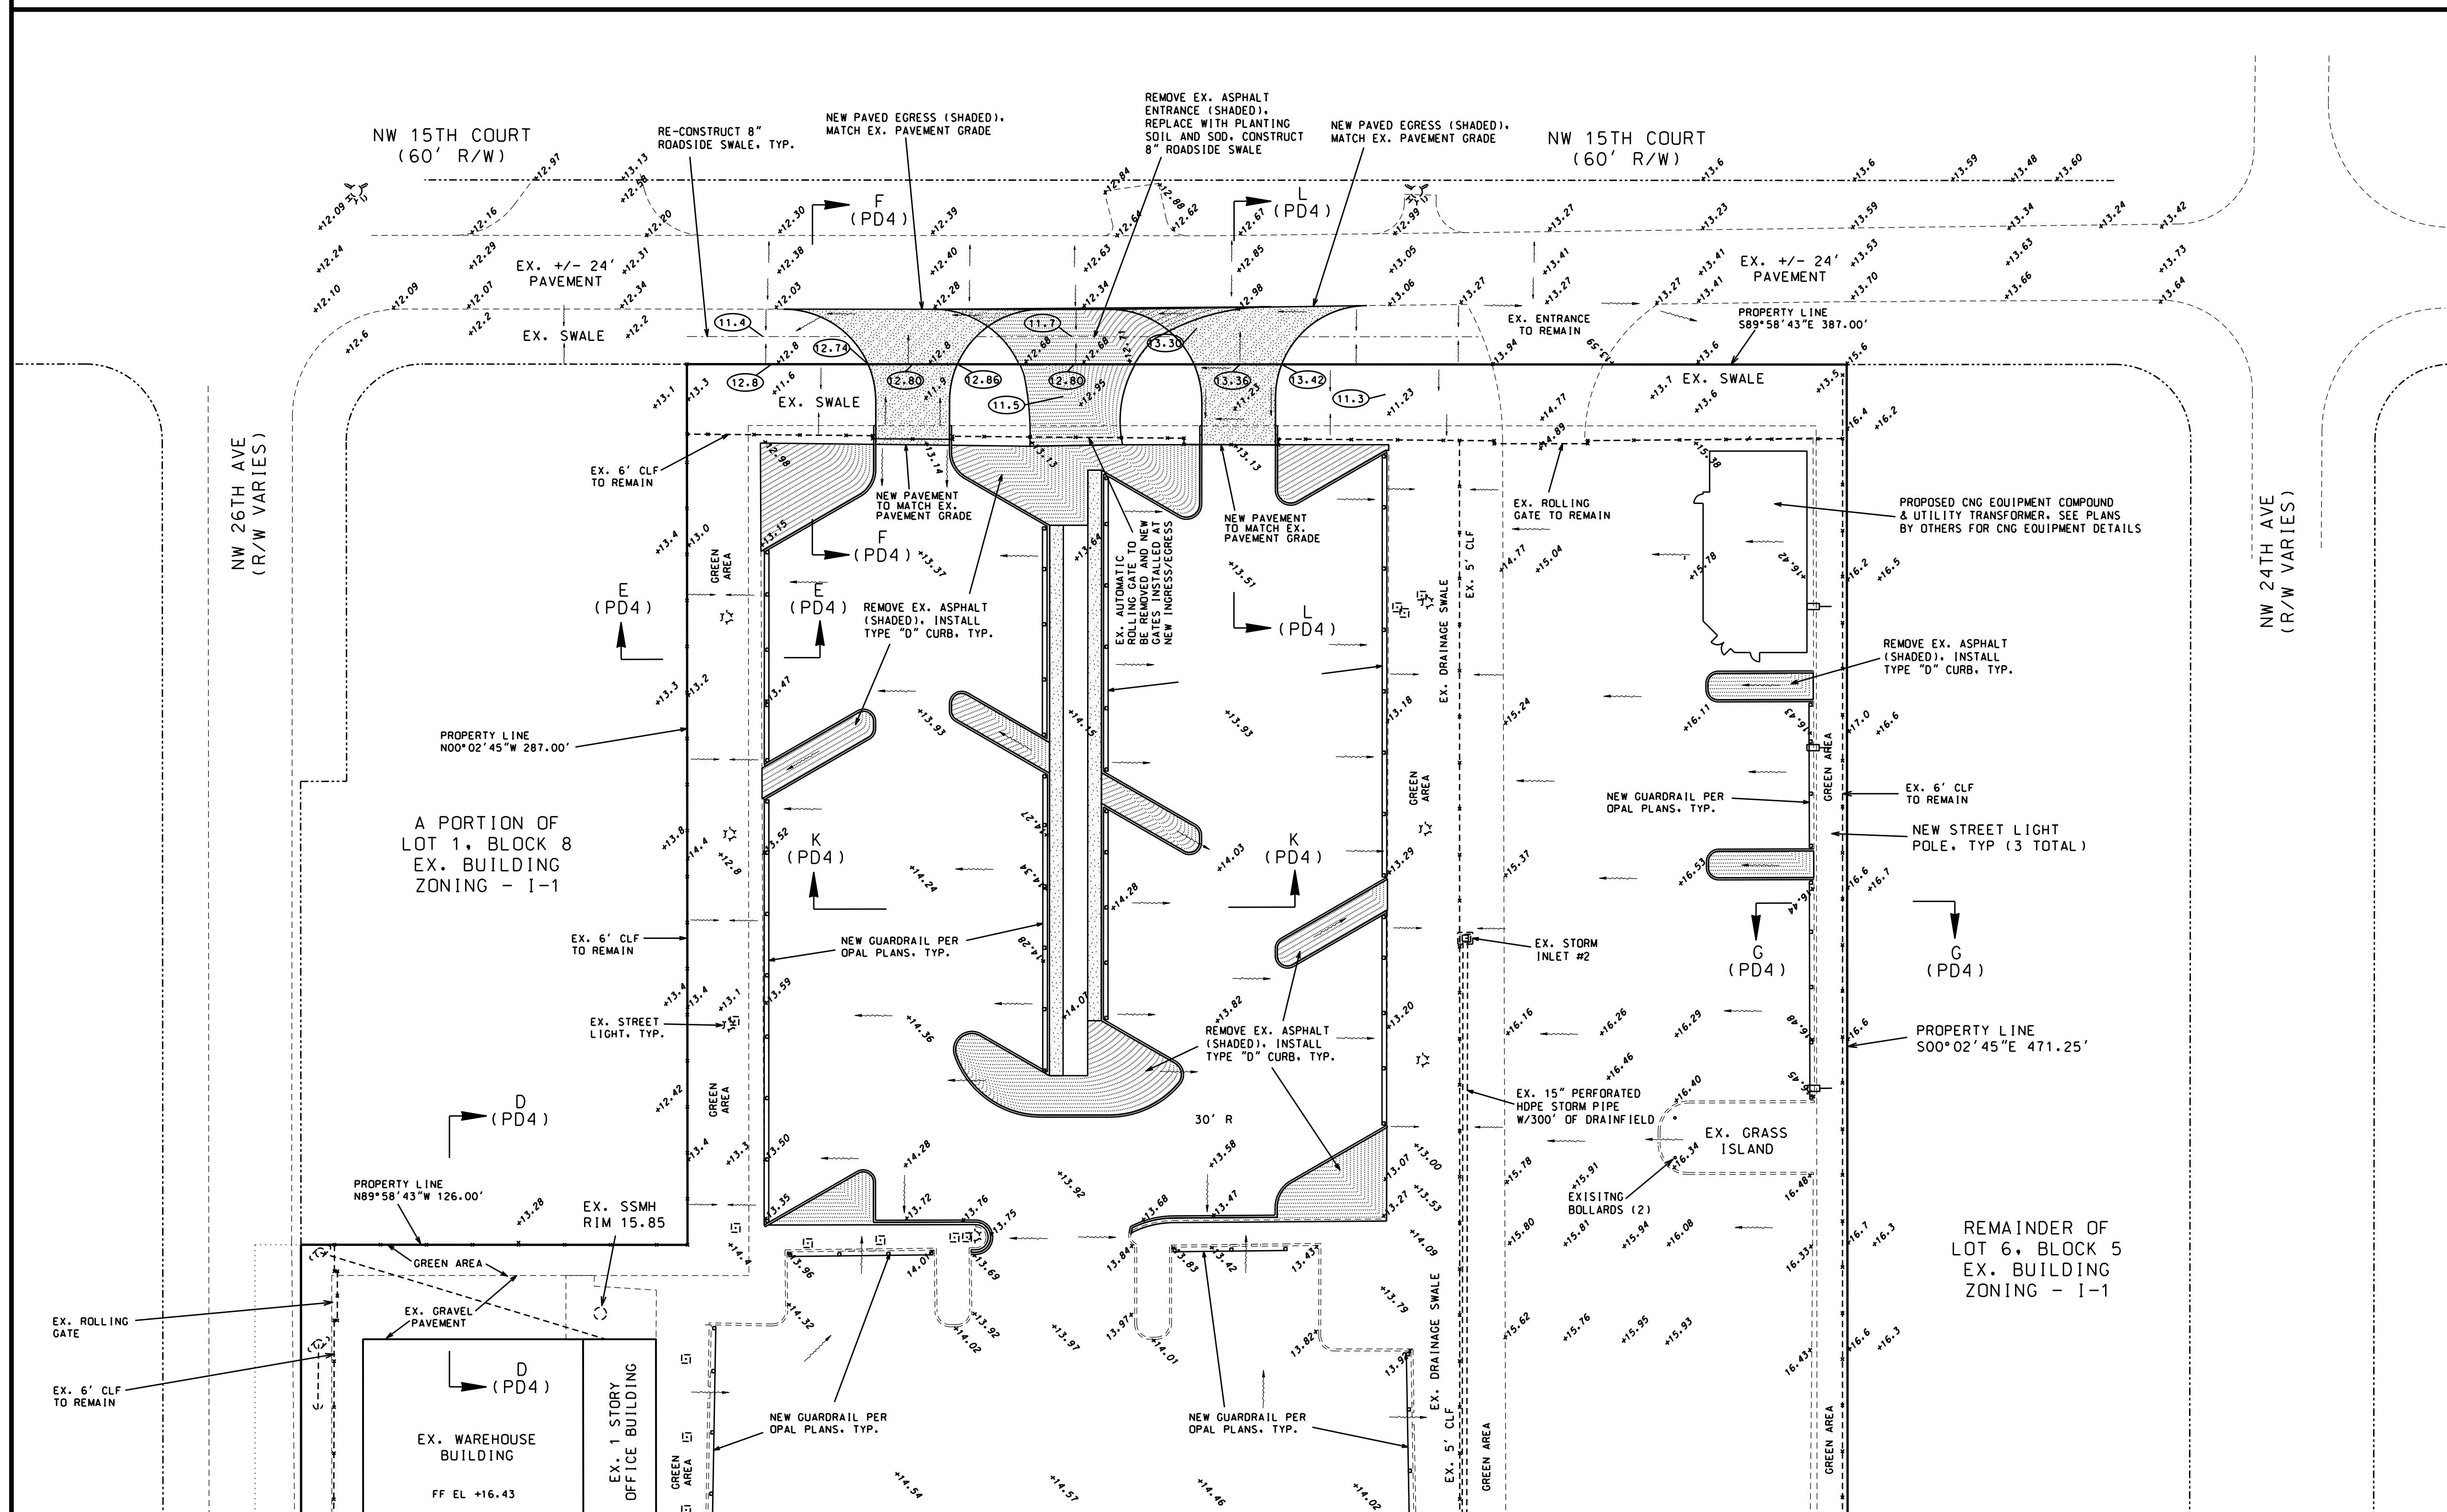[illegible]

AJ HYDRO
ENGINEERING, INC.
5932 NW 73RD COURT
PARKLAND, FL 33067
TEL (954) 347-3397
AJHYDRO@BELLSOUTH.NET
CA P96000078194

PROJECT:

COASTAL RECYCLING OF POMPANO
COASTAL 16 – CNG

2407 HAMMONDVILLE ROAD
POMPANO BEACH, FLORIDA

TITLE:

PAVING, GRADING & DRAINAGE PLAN

SEAL: