

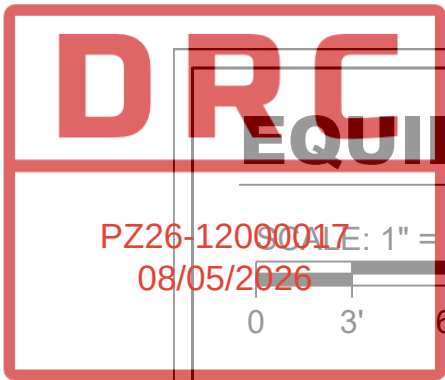
 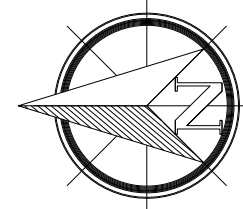


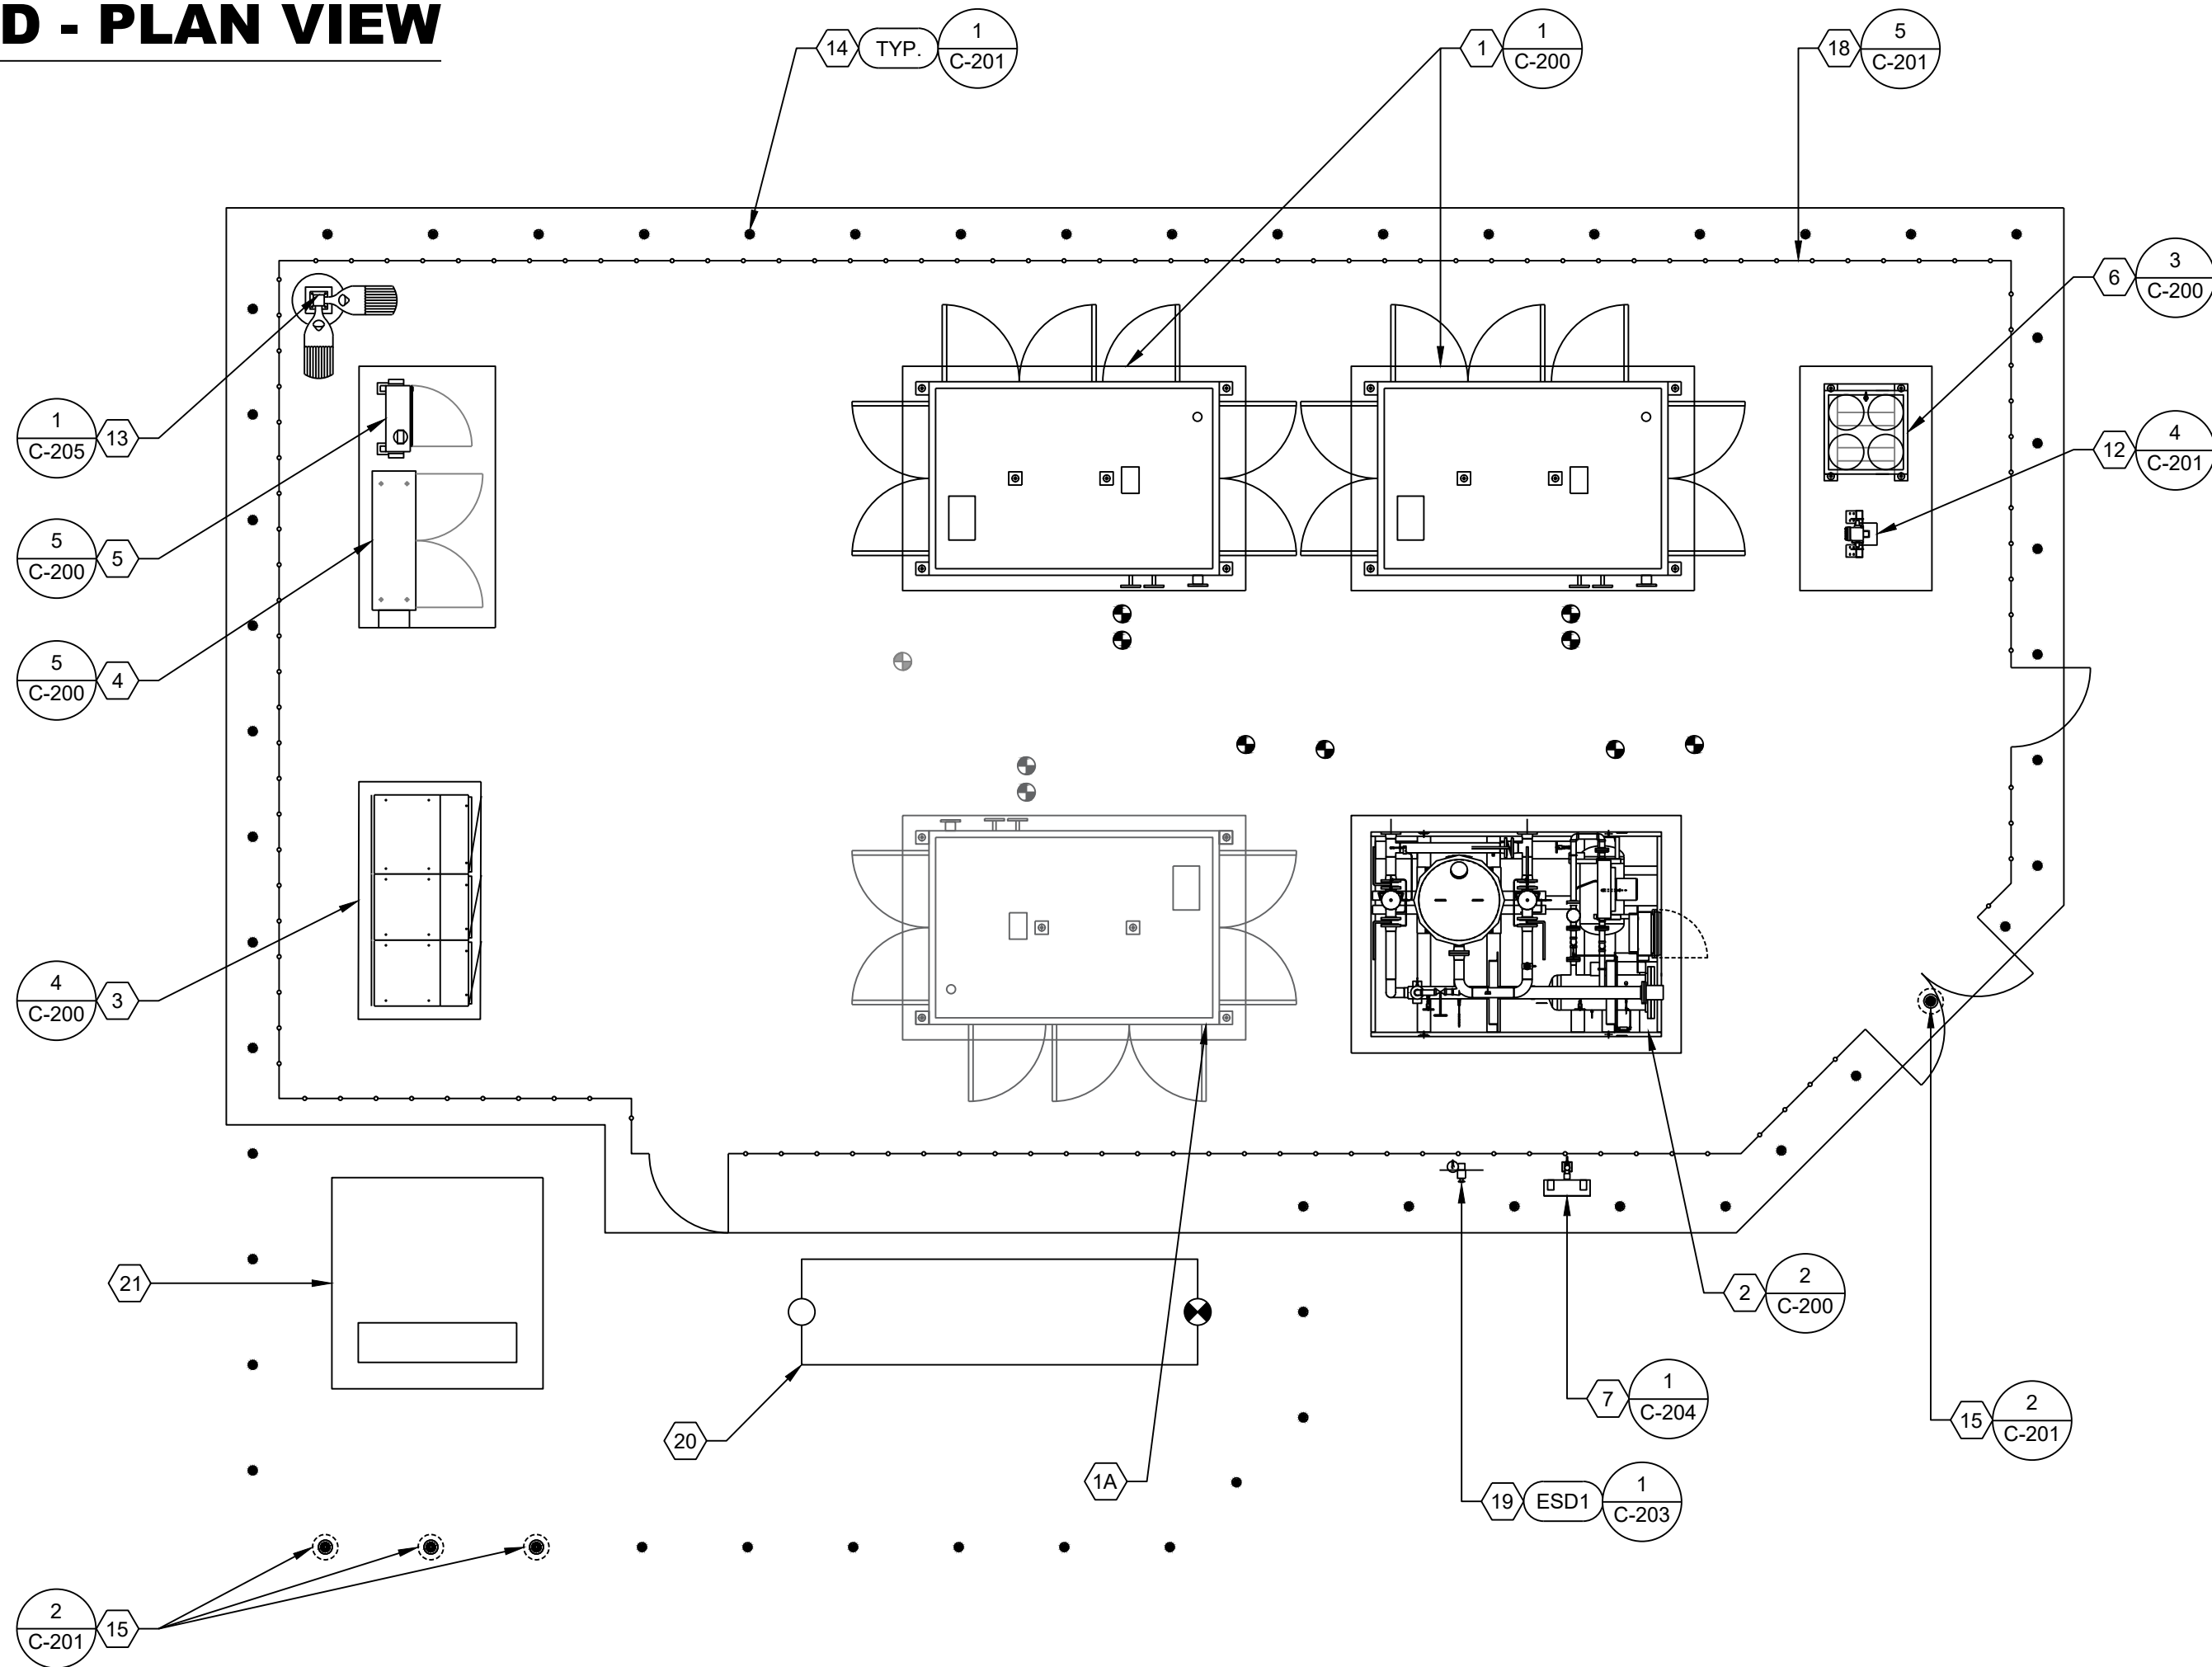

EQUIPMENT COMPOUND - PLAN VIEW

PZ26-1200017
08/05/2026



EQUIPMENT LIST		
ITEM	DESCRIPTION	Qty.
1	ANGI 200 HP COMPRESSOR	1
1A	FUTURE COMPRESSOR	1
2	CNG DRYER NG-SR-21-4-DDP-SP	1
3	1200 AMP 277/480V, 3 PH, SERVICE ENTRANCE RATED SWITCHGEAR	1
4	TRIPLE MOTOR STARTER PANEL - 1200A	1
5	COMMUNICATION PANEL	1
6	4-PACK BUFFER STORAGE	1
7	DIRECT FILL/DE-FUELING POST - DIRECT BURIAL - VENT TO ATMOSPHERE	1
8	DUAL HOSE TIME-FILL POST - DUAL FACING - DIRECT BURIAL - VENT TO ATMOSPHERE	4
9	SINGLE HOSE TIME-FILL POST - DIRECT BURIAL - VENT TO ATMOSPHERE	2
10	DUAL HOSE TIME-FILL POST - DUAL FACING - DIRECT BURIAL - VENT BACK	34
11	SINGLE HOSE TIME-FILL POST - DIRECT BURIAL - VENT BACK	8
12	DUAL FILTER POST AND FLOW METER ASSEMBLY - SURFACE MOUNT	1
13	20' DUAL HEAD LED LIGHT @ 90°	1
14	4" FIXED BOLLARD WITH 52" SLEEVE	52
15	6" REMOVABLE BOLLARD WITH 52" SLEEVE	4
16	SINGLE FILTER POST ASSEMBLY - DIRECT BURIAL	6
17	GUARD RAIL	1,163 LF
18	9' VINYL FENCE	193 L.F.
19	ESD POST W/34-08C FIRE EXTINGUISHER - DIRECT BURIAL	1
20	UTILITY METER SET ASSEMBLY	1
21	UTILITY TRANSFORMER	1

*SEE CIVIL & ELECTRICAL LAYOUT FOR CALLOUTS

OPAL
FUELS

COASTAL WASTE

2407 HAMMONDVILLE RD
POMPANO BEACH, FL 33069
CNG FUELING FACILITY



LARSON DESIGN GROUP, INC.
3000 WESTINGHOUSE DR, STE 40
CRANBERRY TWP, PA 16066
570-323-6603



No.	DATE	BY	REMARK
PERMITTING REVISIONS			

EQUIPMENT COMPOUND

DRAWN: WEH
CHECKED: EC
DATE: 08/12/25
PAPER SIZE: D SIZE
SCALE: 1" = 6'
JOB NO.: 24022

C-102

REV NO. 0

EQUIPMENT COMPOUND - ELEVATION VIEW

SCALE: 1" = 6'

