



DRC

PZ26-12000017
08/05/2026

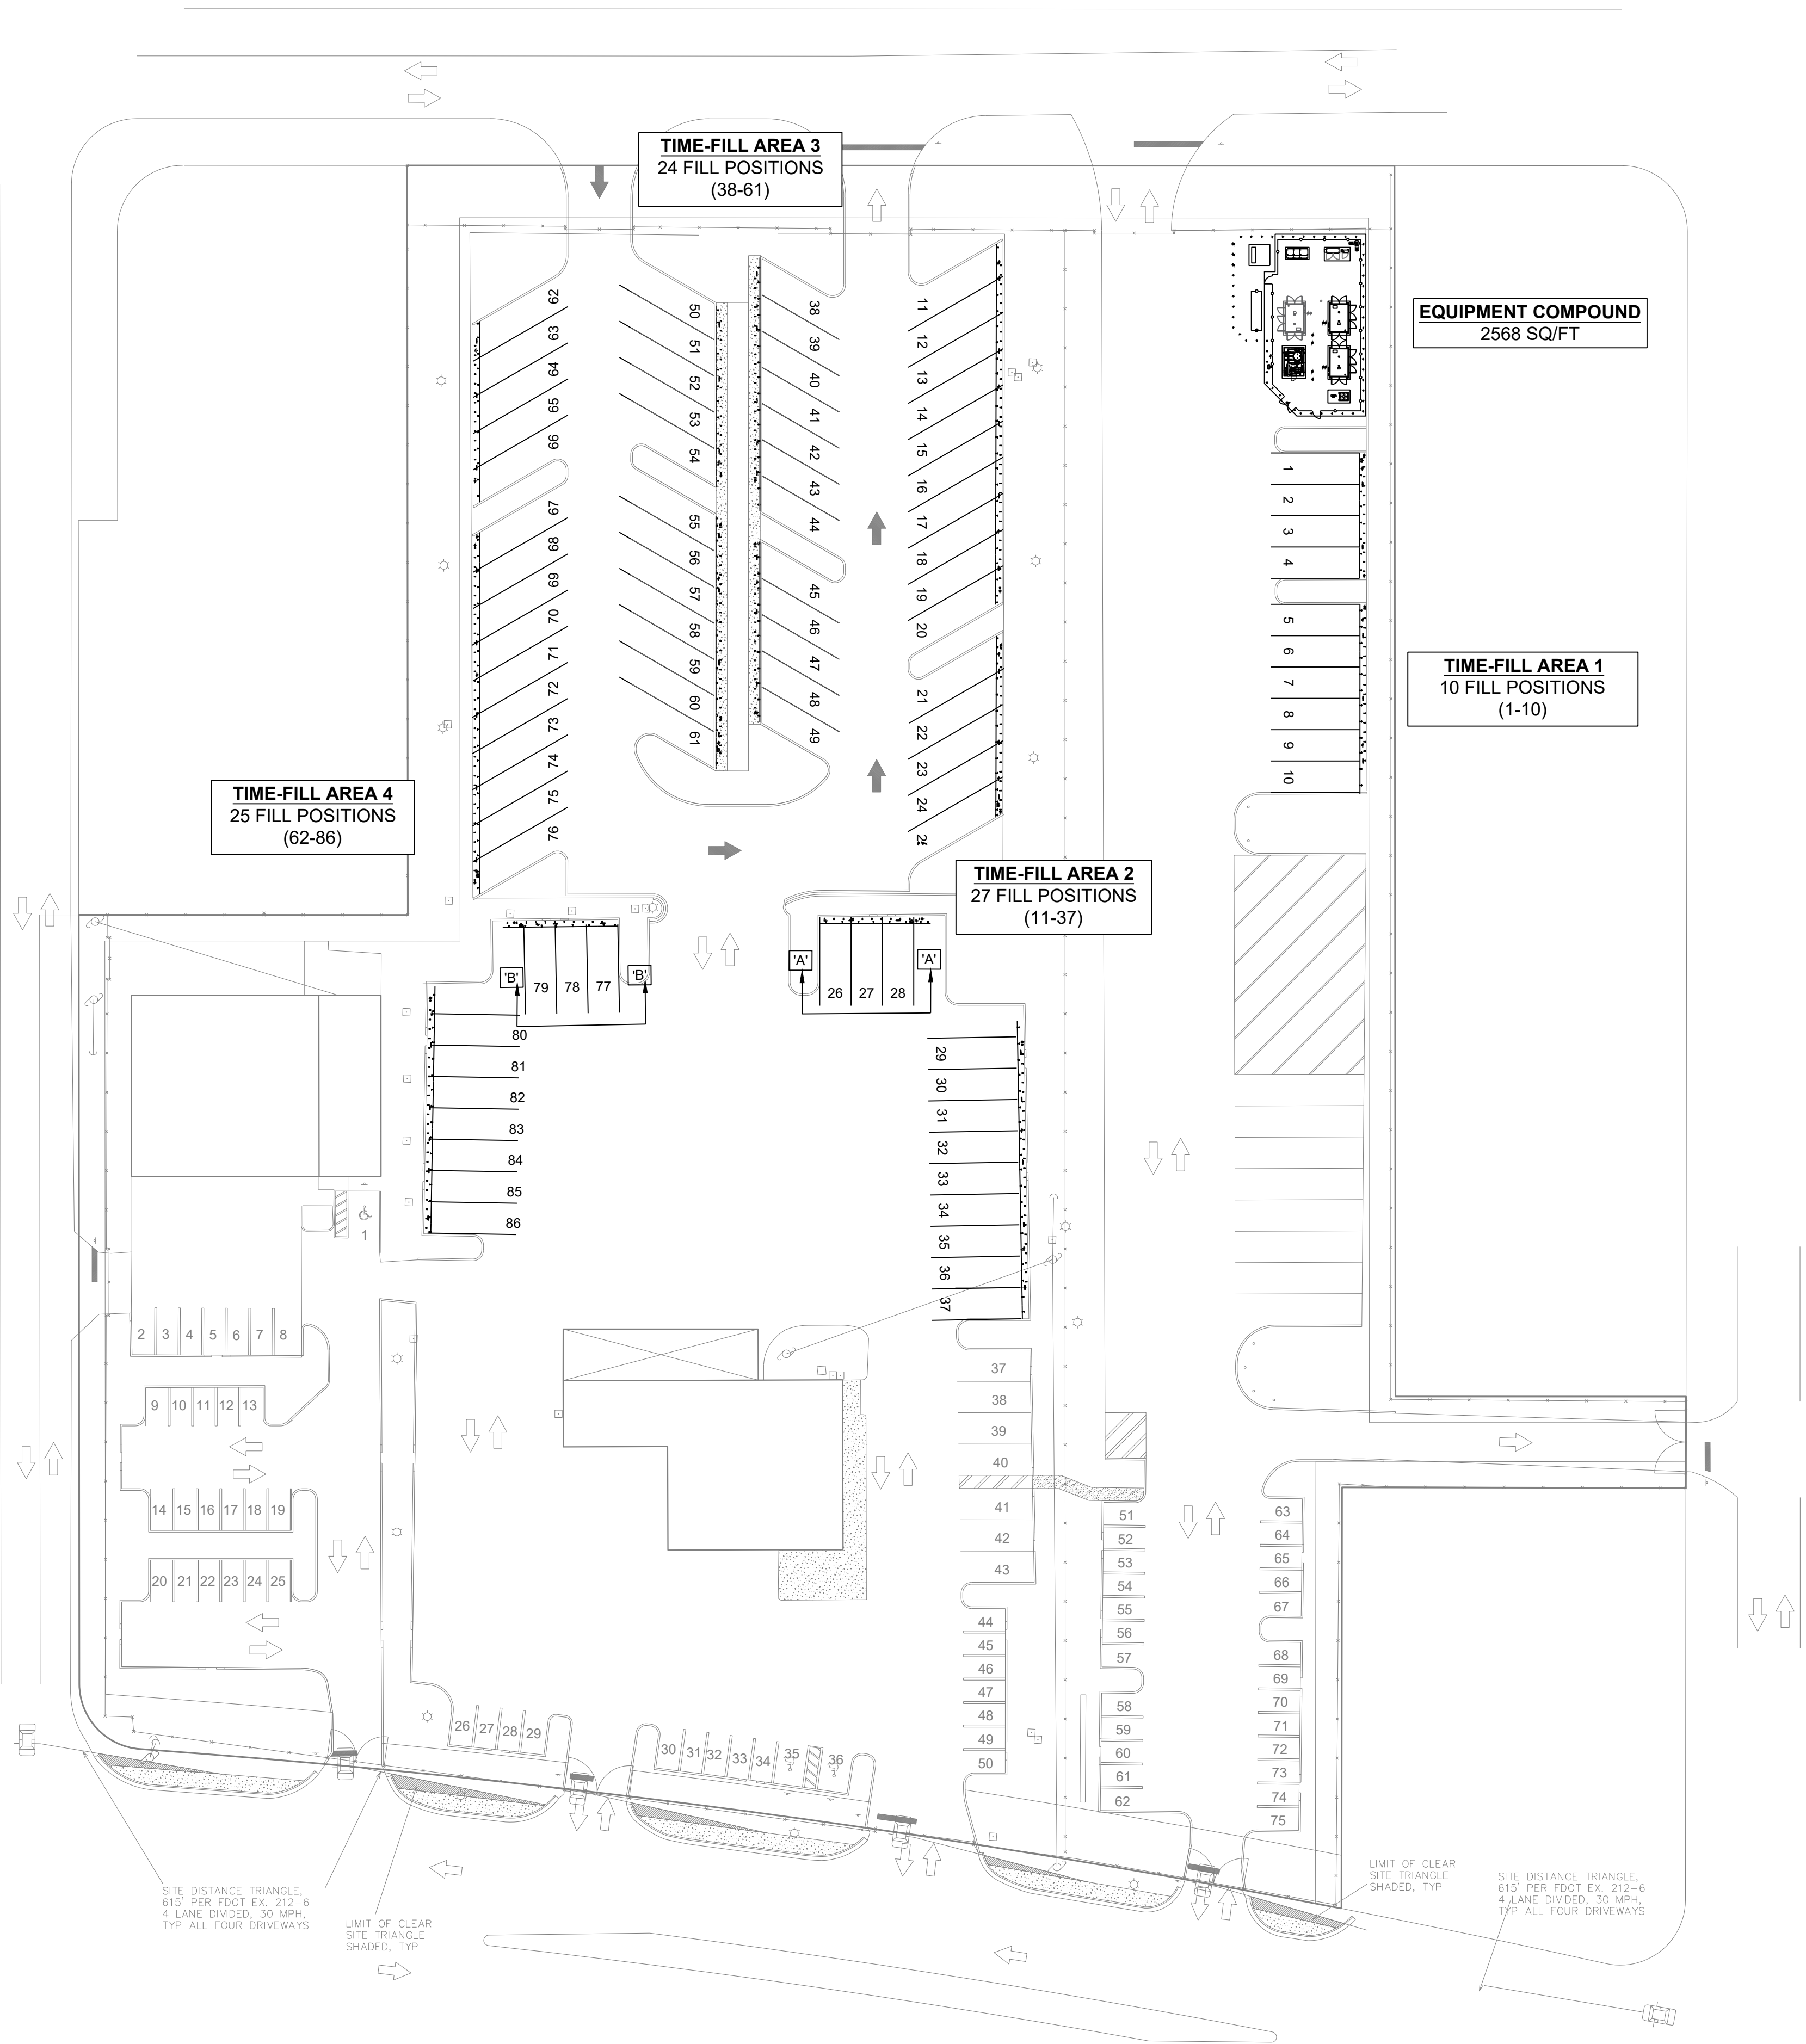

COASTAL WASTE
2407 HAMMONDVILLE RD
POMPANO BEACH, FL 33069
CNG FUELING FACILITY

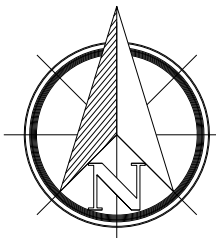

No.	DATE	BY	REMARK
PERMITTING REVISIONS			

SITE PLAN LAYOUT

DRAWN: MRZ
CHECKED: EC
DATE: 08/12/25
PAPER SIZE: D SIZE
SCALE: 1" = 40'
JOB NO.: 24022

C-100

REV NO. 0

SCALE: 1" = 40'
0 20' 40' 80'



Z:\MIGRATED\TutorEnergy\Projects\2024\24022 - Coastal Waste, Pompano Beach, FL\Engineering\Working Folder\Sheet Set\Sheet Layout\Drawings\GENERAL.dwg 6/23/2026 3:57 PM