



DRC
PZ26-12000017: 1" = 10'
08/05/2026


TIME-FILL AREA 1 - PLAN VIEW

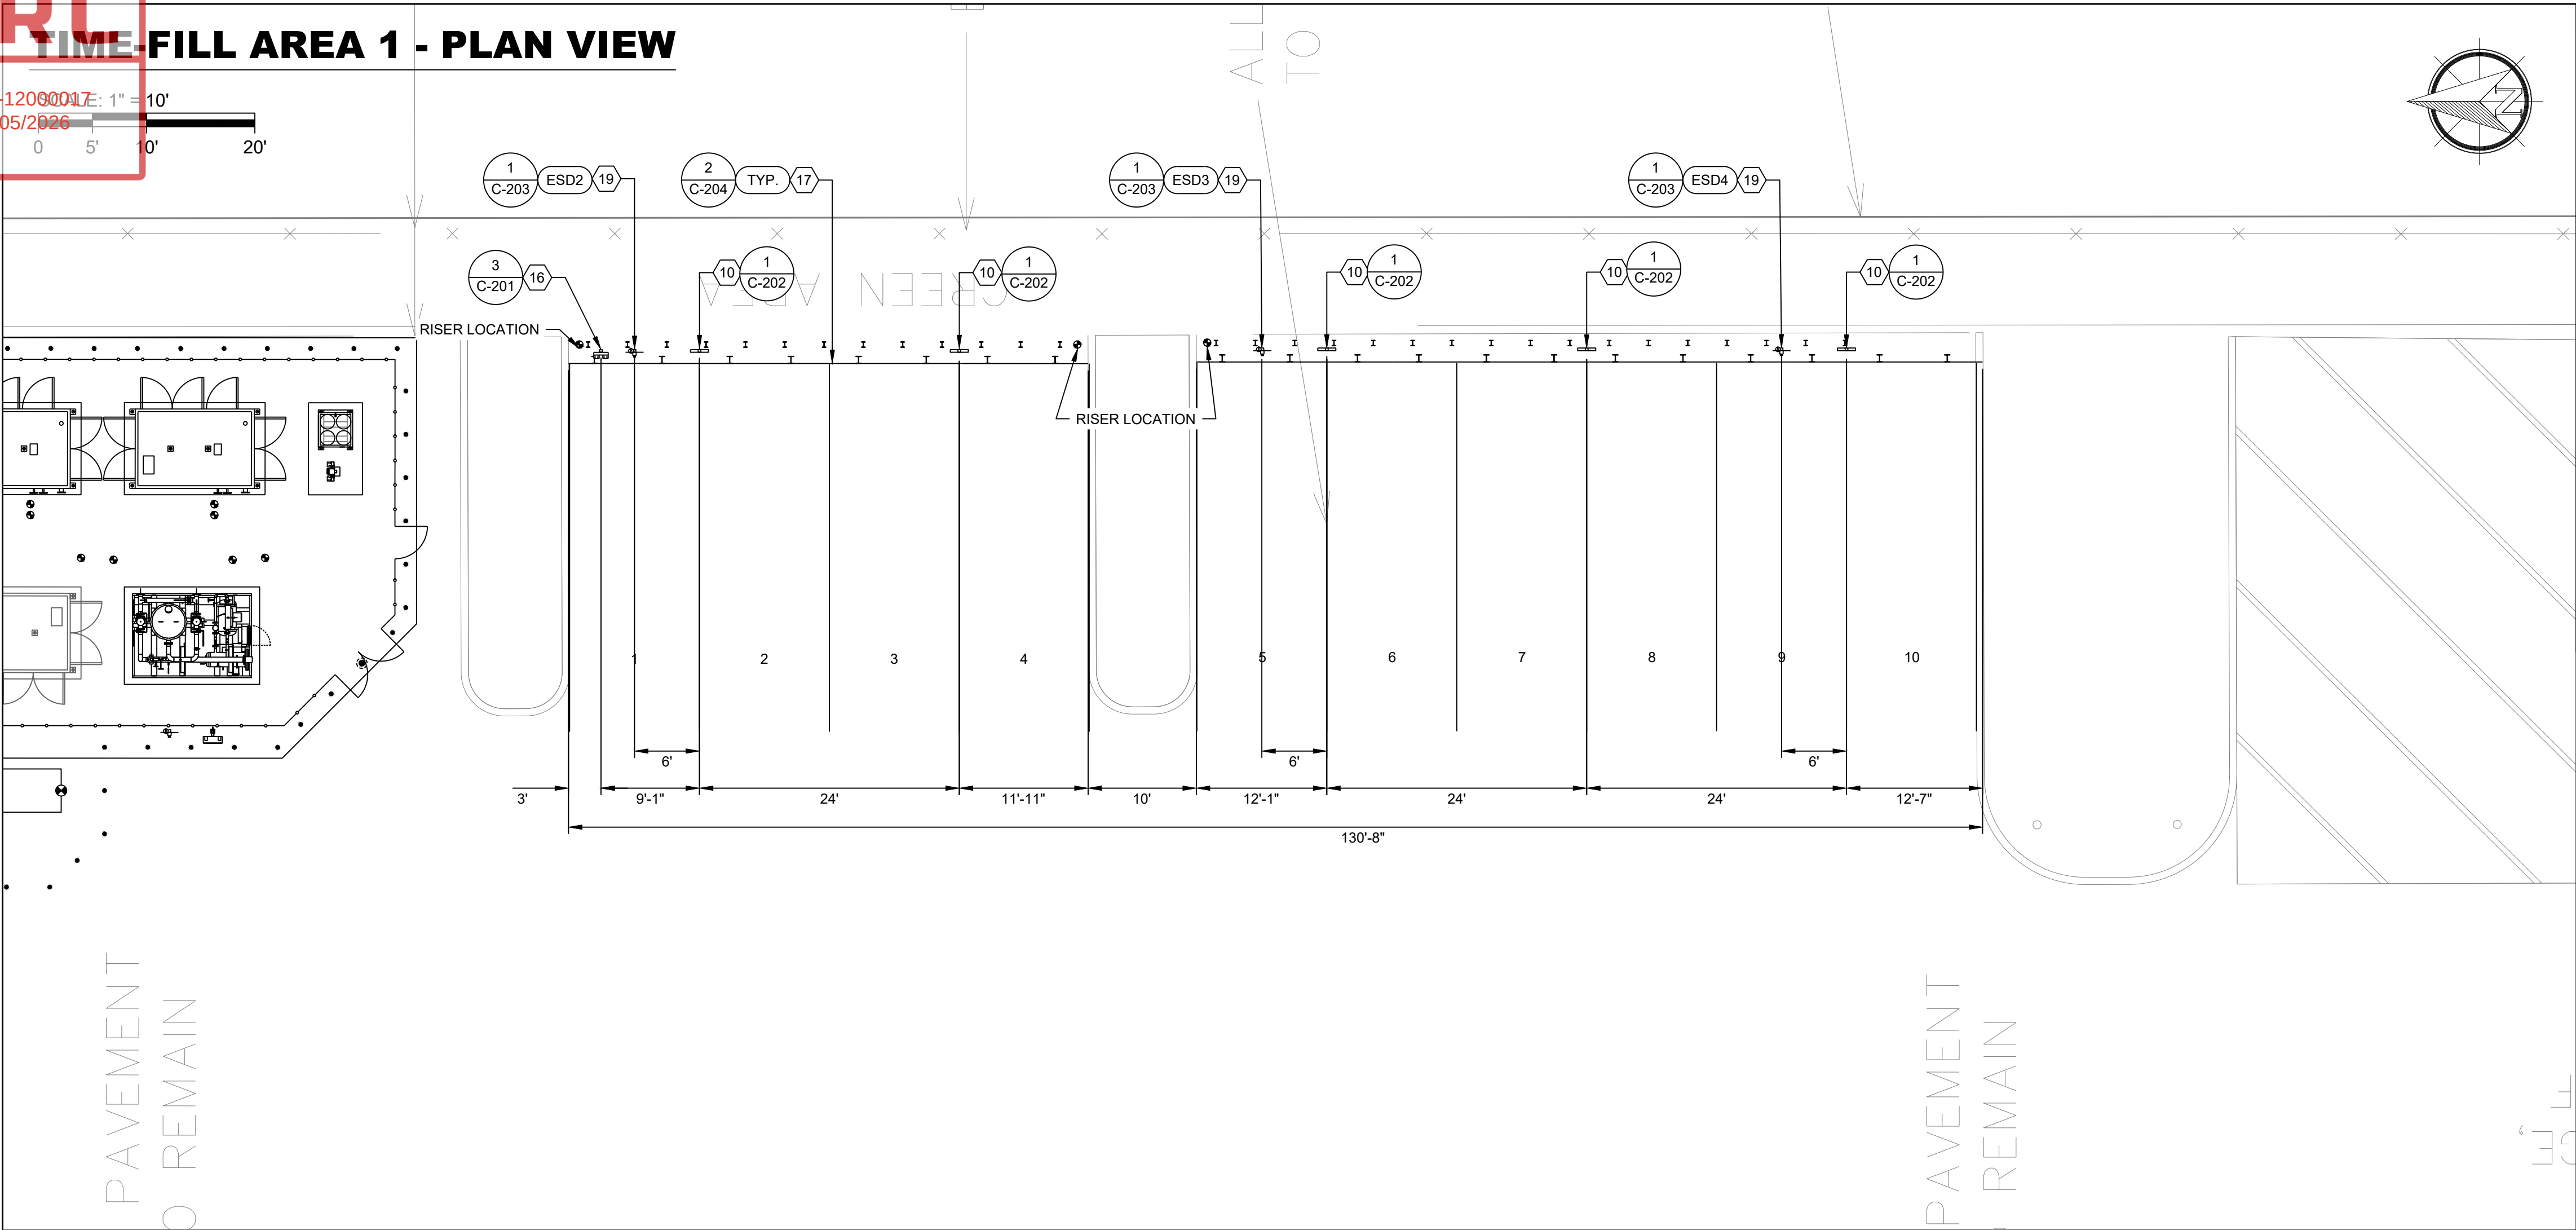

TIME-FILL AREA 1 - ELEVATION VIEW

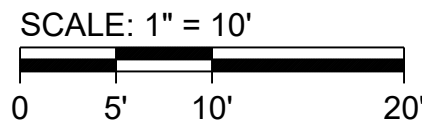

ALL POSTS IN THIS TIME-FILL AREA VENT BACK TO THE VENT AT THE STORAGE BOTTLES

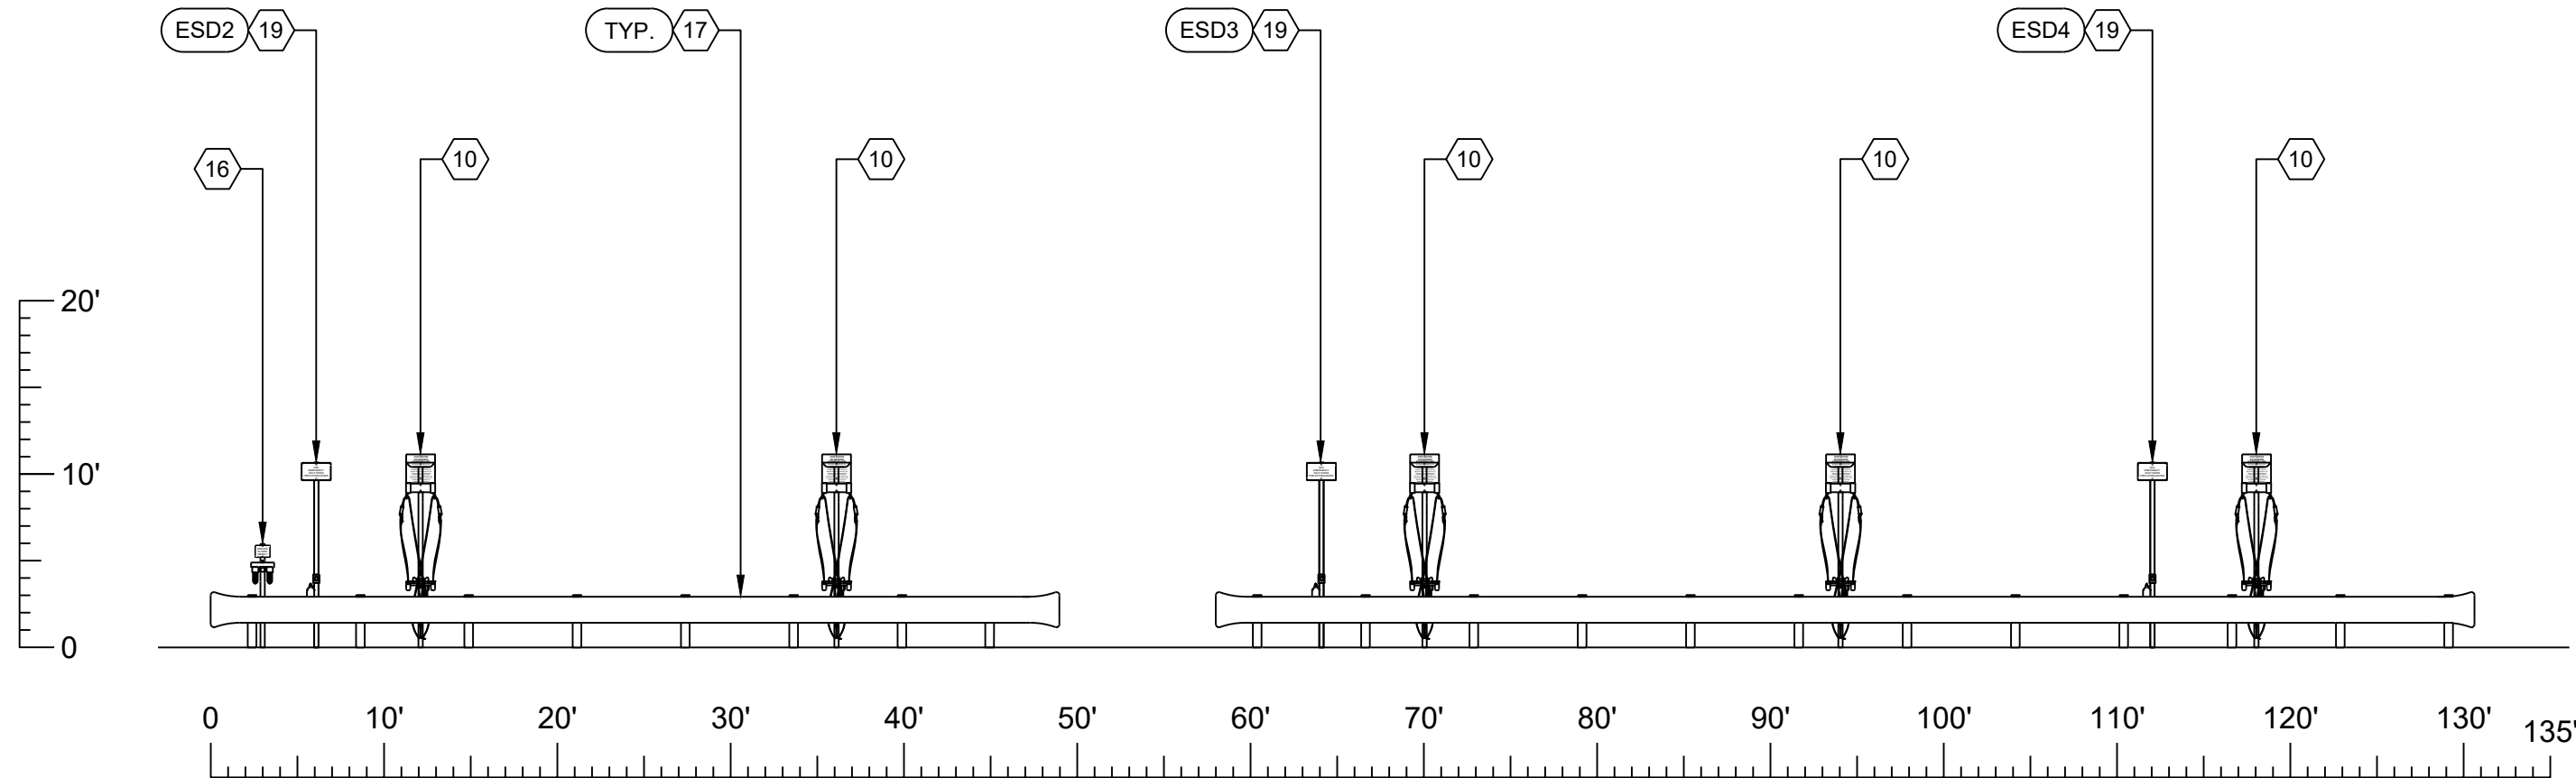

EQUIPMENT LIST		
ITEM	DESCRIPTION	Qty.
1	ANGI 200 HP COMPRESSOR	2
1A	FUTURE COMPRESSOR	1
2	CNG DRYER NG-SR-21.4-DDP-SP	1
3	1200 AMP 277/480V, 3 PH. SERVICE ENTRANCE RATED SWITCHGEAR	1
4	TRIPLE MOTOR STARTER PANEL - 1200A	1
5	COMMUNICATION PANEL	1
6	4-PACK BUFFER STORAGE	1
7	DIRECT FILL/DE-FUELING POST - DIRECT BURIAL - VENT TO ATMOSPHERE	1
8	DUAL HOSE TIME-FILL POST - DUAL FACING - DIRECT BURIAL - VENT TO ATMOSPHERE	4
9	SINGLE HOSE TIME-FILL POST - DIRECT BURIAL - VENT TO ATMOSPHERE	2
10	DUAL HOSE TIME-FILL POST - DUAL FACING - DIRECT BURIAL - VENT BACK	34
11	SINGLE HOSE TIME-FILL POST - DIRECT BURIAL - VENT BACK	8
12	DUAL FILTER POST AND FLOW METER ASSEMBLY - SURFACE MOUNT	1
13	20' DUAL HEAD LED LIGHT @ 90°	1
14	4" FIXED BOLLARD WITH 52" SLEEVE	52
15	6" REMOVABLE BOLLARD WITH 52" SLEEVE	4
16	SINGLE FILTER POST ASSEMBLY - DIRECT BURIAL	6
17	GUARD RAIL	1,163 LF
18	9" VINYL FENCE	193 L.F.
19	ESD POST W/3A40BC FIRE EXTINGUISHER - DIRECT BURIAL	27
20	UTILITY METER SET ASSEMBLY	1
21	UTILITY TRANSFORMER	1
*SEE CIVIL & ELECTRICAL LAYOUT FOR CALLOUTS		

OWNER:
COASTAL WASTE
DENNIS PANTANO
954-947-4000
2407 HAMMONDVILLE RD
POMPANO BEACH, FL 33069

GENERAL CONTRACTOR:
OPAL FUELS
(LIC# SCC131151866)
10225 PHILADELPHIA CT
RANCHO CUCAMONGA, CA 91730
(909)793-3700



COASTAL WASTE

2407 HAMMONDVILLE RD
POMPANO BEACH, FL 33069
CNG FUELING FACILITY



No.	DATE	BY	REMARK
PERMITTING REVISIONS			

TIME-FILL AREA 1

DRAWN: WEH
CHECKED: EC
DATE: 08/12/25
PAPER SIZE: D SIZE
SCALE: 1" = 10'
JOB NO.: 24022

C-104

REV NO. 0

