 



DRC

TIME-FILL AREA 3 - PLAN VIEW



PZ26-12000017: 1" = 10'  
08/05/2026



ALL POSTS IN THIS TIME-FILL AREA VENT  
BACK TO THE FIRST POST IN TIME-FILL  
AREA 2 SECTION A-A

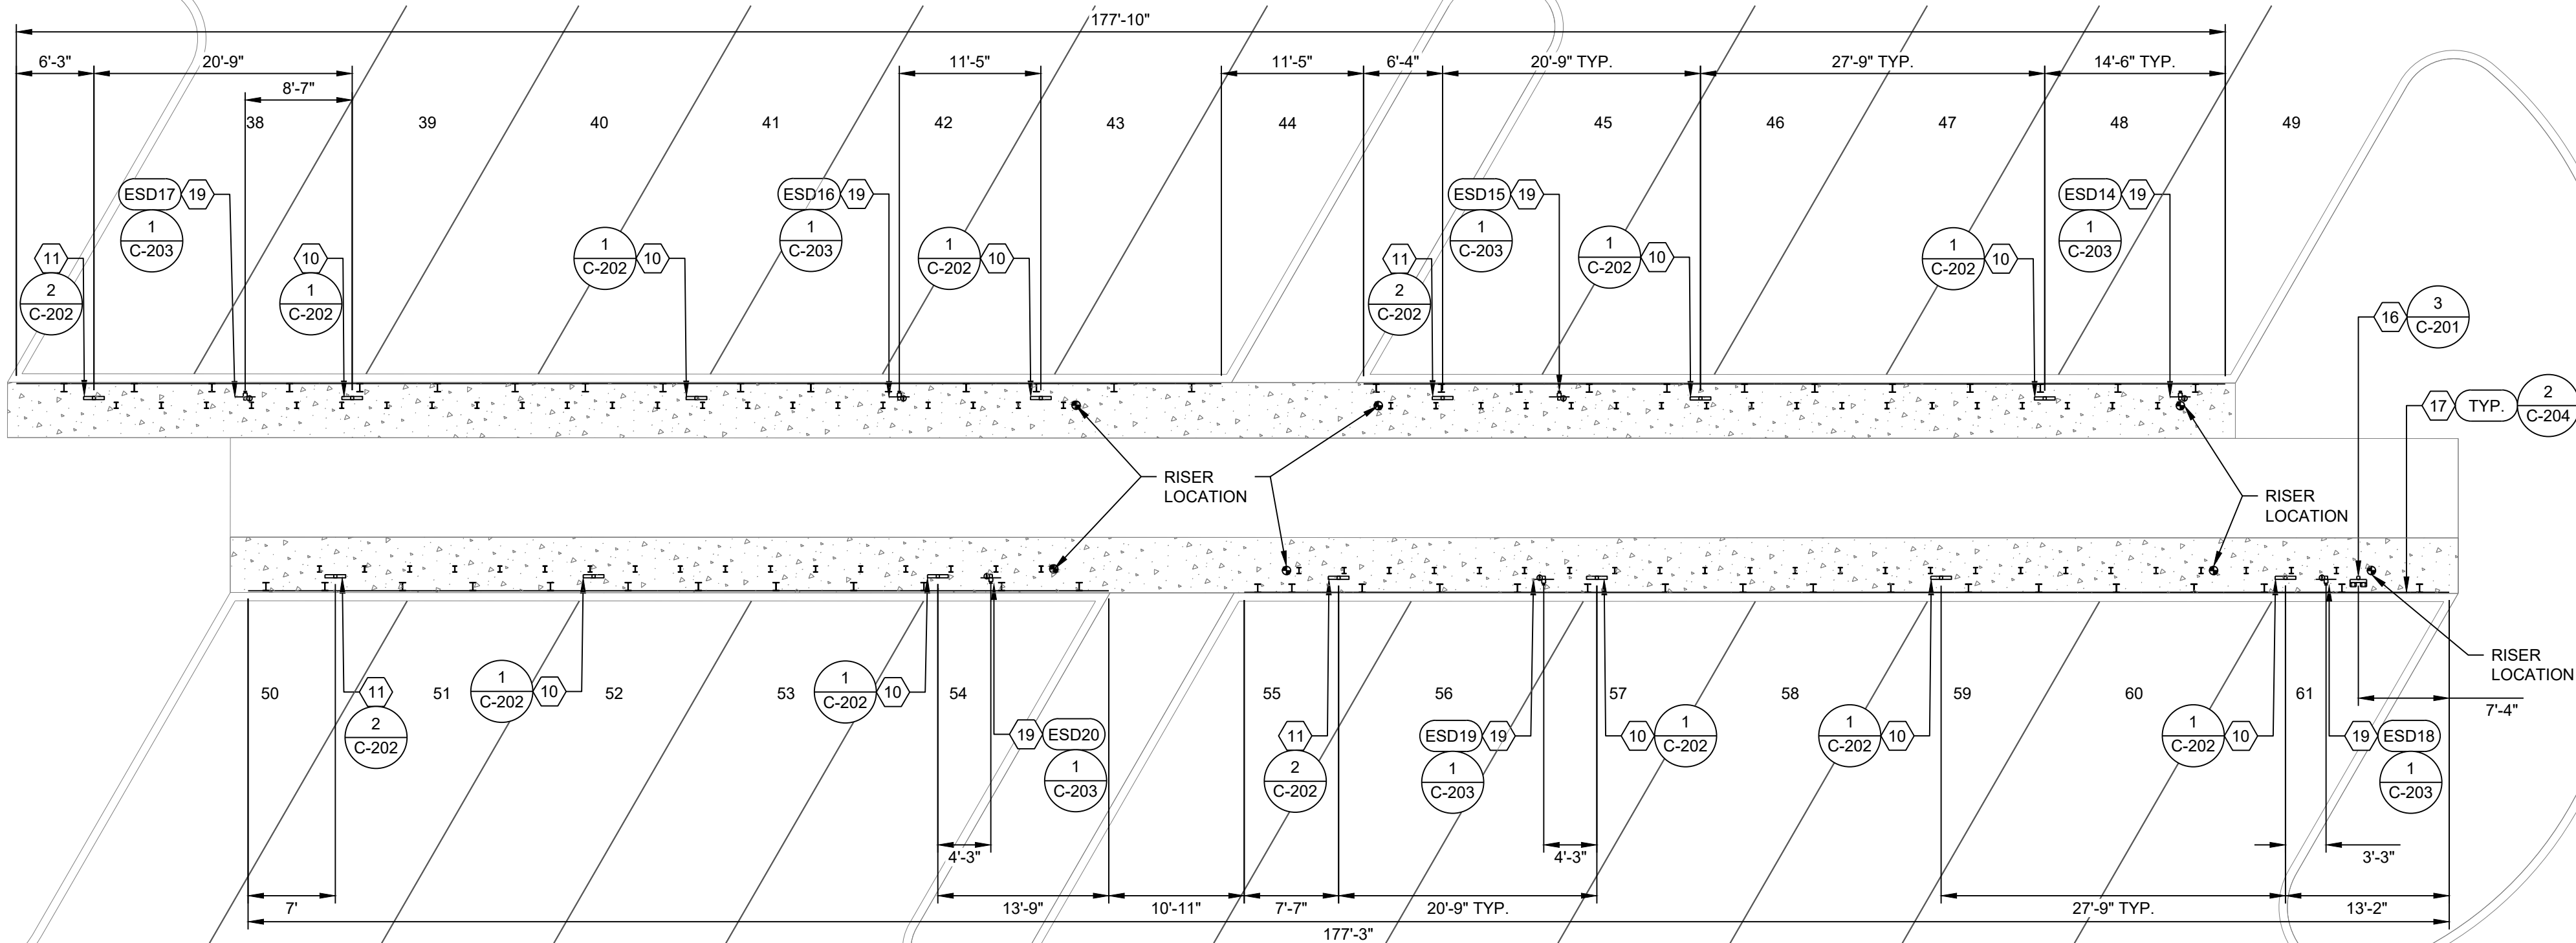

TIME-FILL AREA 3 - ELEVATION VIEW

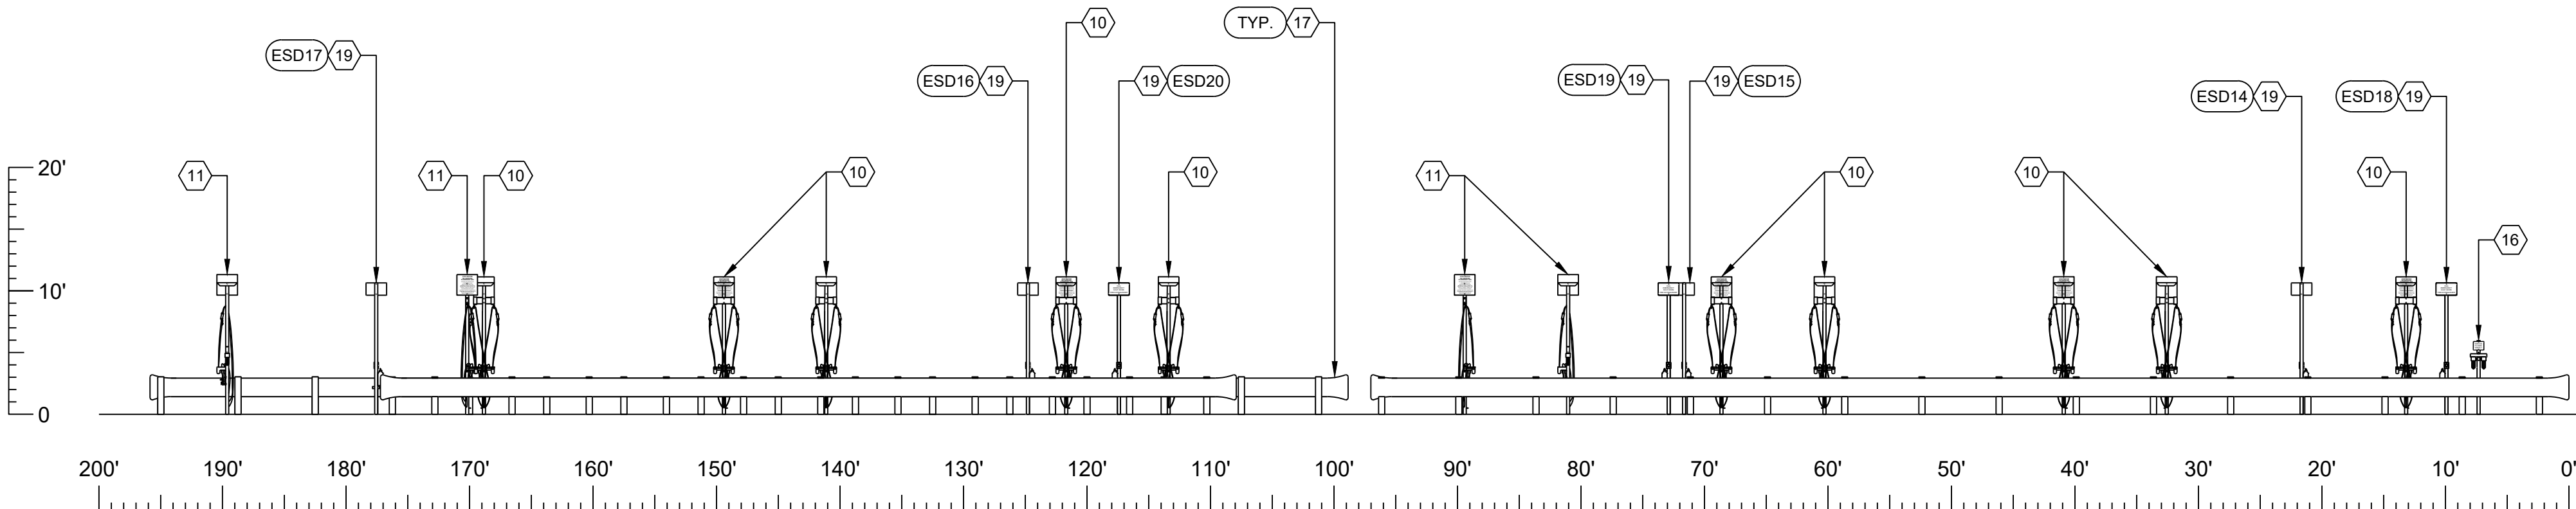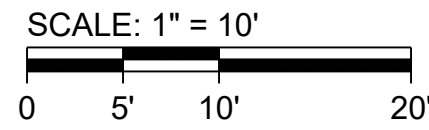

EQUIPMENT LIST

| ITEM | DESCRIPTION                                                                 | Qty.     |
|------|-----------------------------------------------------------------------------|----------|
| 1    | ANGI 200 HP COMPRESSOR                                                      | 2        |
| 1A   | FUTURE COMPRESSOR                                                           | 1        |
| 2    | CNG DRYER NG-SR-214-DDP-SP                                                  | 1        |
| 3    | 1200 AMP 277/480V, 3 PH. SERVICE ENTRANCE RATED SWITCHGEAR                  | 1        |
| 4    | TRIPLE MOTOR STARTER PANEL - 1200A                                          | 1        |
| 5    | COMMUNICATION PANEL                                                         | 1        |
| 6    | 4-PACK BUFFER STORAGE                                                       | 1        |
| 7    | DIRECT FILL/DE-FUELING POST - DIRECT BURIAL - VENT TO ATMOSPHERE            | 1        |
| 8    | DUAL HOSE TIME-FILL POST - DUAL FACING - DIRECT BURIAL - VENT TO ATMOSPHERE | 4        |
| 9    | SINGLE HOSE TIME-FILL POST - DIRECT BURIAL - VENT TO ATMOSPHERE             | 2        |
| 10   | DUAL HOSE TIME-FILL POST - DUAL FACING - DIRECT BURIAL - VENT BACK          | 34       |
| 11   | SINGLE HOSE TIME-FILL POST - DIRECT BURIAL - VENT BACK                      | 8        |
| 12   | DUAL FILTER POST AND FLOW METER ASSEMBLY - SURFACE MOUNT                    | 1        |
| 13   | 20' DUAL HEAD LED LIGHT @ 90°                                               | 1        |
| 14   | 4" FIXED BOLLARD WITH 52" SLEEVE                                            | 52       |
| 15   | 6" REMOVABLE BOLLARD WITH 52" SLEEVE                                        | 4        |
| 16   | SINGLE FILTER POST ASSEMBLY - DIRECT BURIAL                                 | 6        |
| 17   | GUARD RAIL                                                                  | 1,163 LF |
| 18   | 9" VINYL FENCE                                                              | 193 L.F. |
| 19   | ESD POST W/3A40BC FIRE EXTINGUISHER - DIRECT BURIAL                         | 27       |
| 20   | UTILITY METER SET ASSEMBLY                                                  | 1        |
| 21   | UTILITY TRANSFORMER                                                         | 1        |

\*SEE CIVIL & ELECTRICAL LAYOUT FOR CALLOUTS



COASTAL WASTE

2407 HAMMONDVILLE RD  
POMPANO BEACH, FL 33069  
CNG FUELING FACILITY



No. DATE BY REMARK  
PERMITTING REVISIONS

TIME-FILL AREA 3

DRAWN: WEH  
CHECKED: EC  
DATE: 08/12/25  
PAPER SIZE: D SIZE  
SCALE: 1" = 10'  
JOB NO.: 24022

C-106

REV NO. 0