



ELECTRICAL SYMBOL LEGEND	
	RECEPTACLE DUPLEX 120V
	SWITCHED RECEPTACLE
	RECEPTACLE @ CEILING
	FLOOR RECEPTACLE
	QUAD RECEPTACLE
	220V RECEPTACLE
	DISCONNECT SWITCH
	ELECTRICAL PANEL
	COMPUTER/PHONE JACK
	WP WEATHER PROOF
	GFCI GROUND FAULT CURRENT INTERRUPTER
	WR WATER RESISTANT
	VP VAPOR PROOF
	JUNCTION BOX
	LIGHT FIXTURE
	EXHAUST FAN
	SWITCH
	3 WAY SWITCH
	4 WAY SWITCH
	PUSH BUTTON
	PROGRAMMABLE THERMOSTAT
	TESTER
	SMOKE DETECTOR
	CARBON MONOXIDE DETECTOR
	SMOKE/CARBON MONOXIDE DETECTOR COMBO

CONTRACTOR TO VERIFY ALL EXISTING CONDITIONS AND NOTIFY ENGINEER IF THERE ARE ANY DISCREPANCIES PRIOR TO BUYING/INSTALLING ANY MATERIALS/EQUIPMENTS.

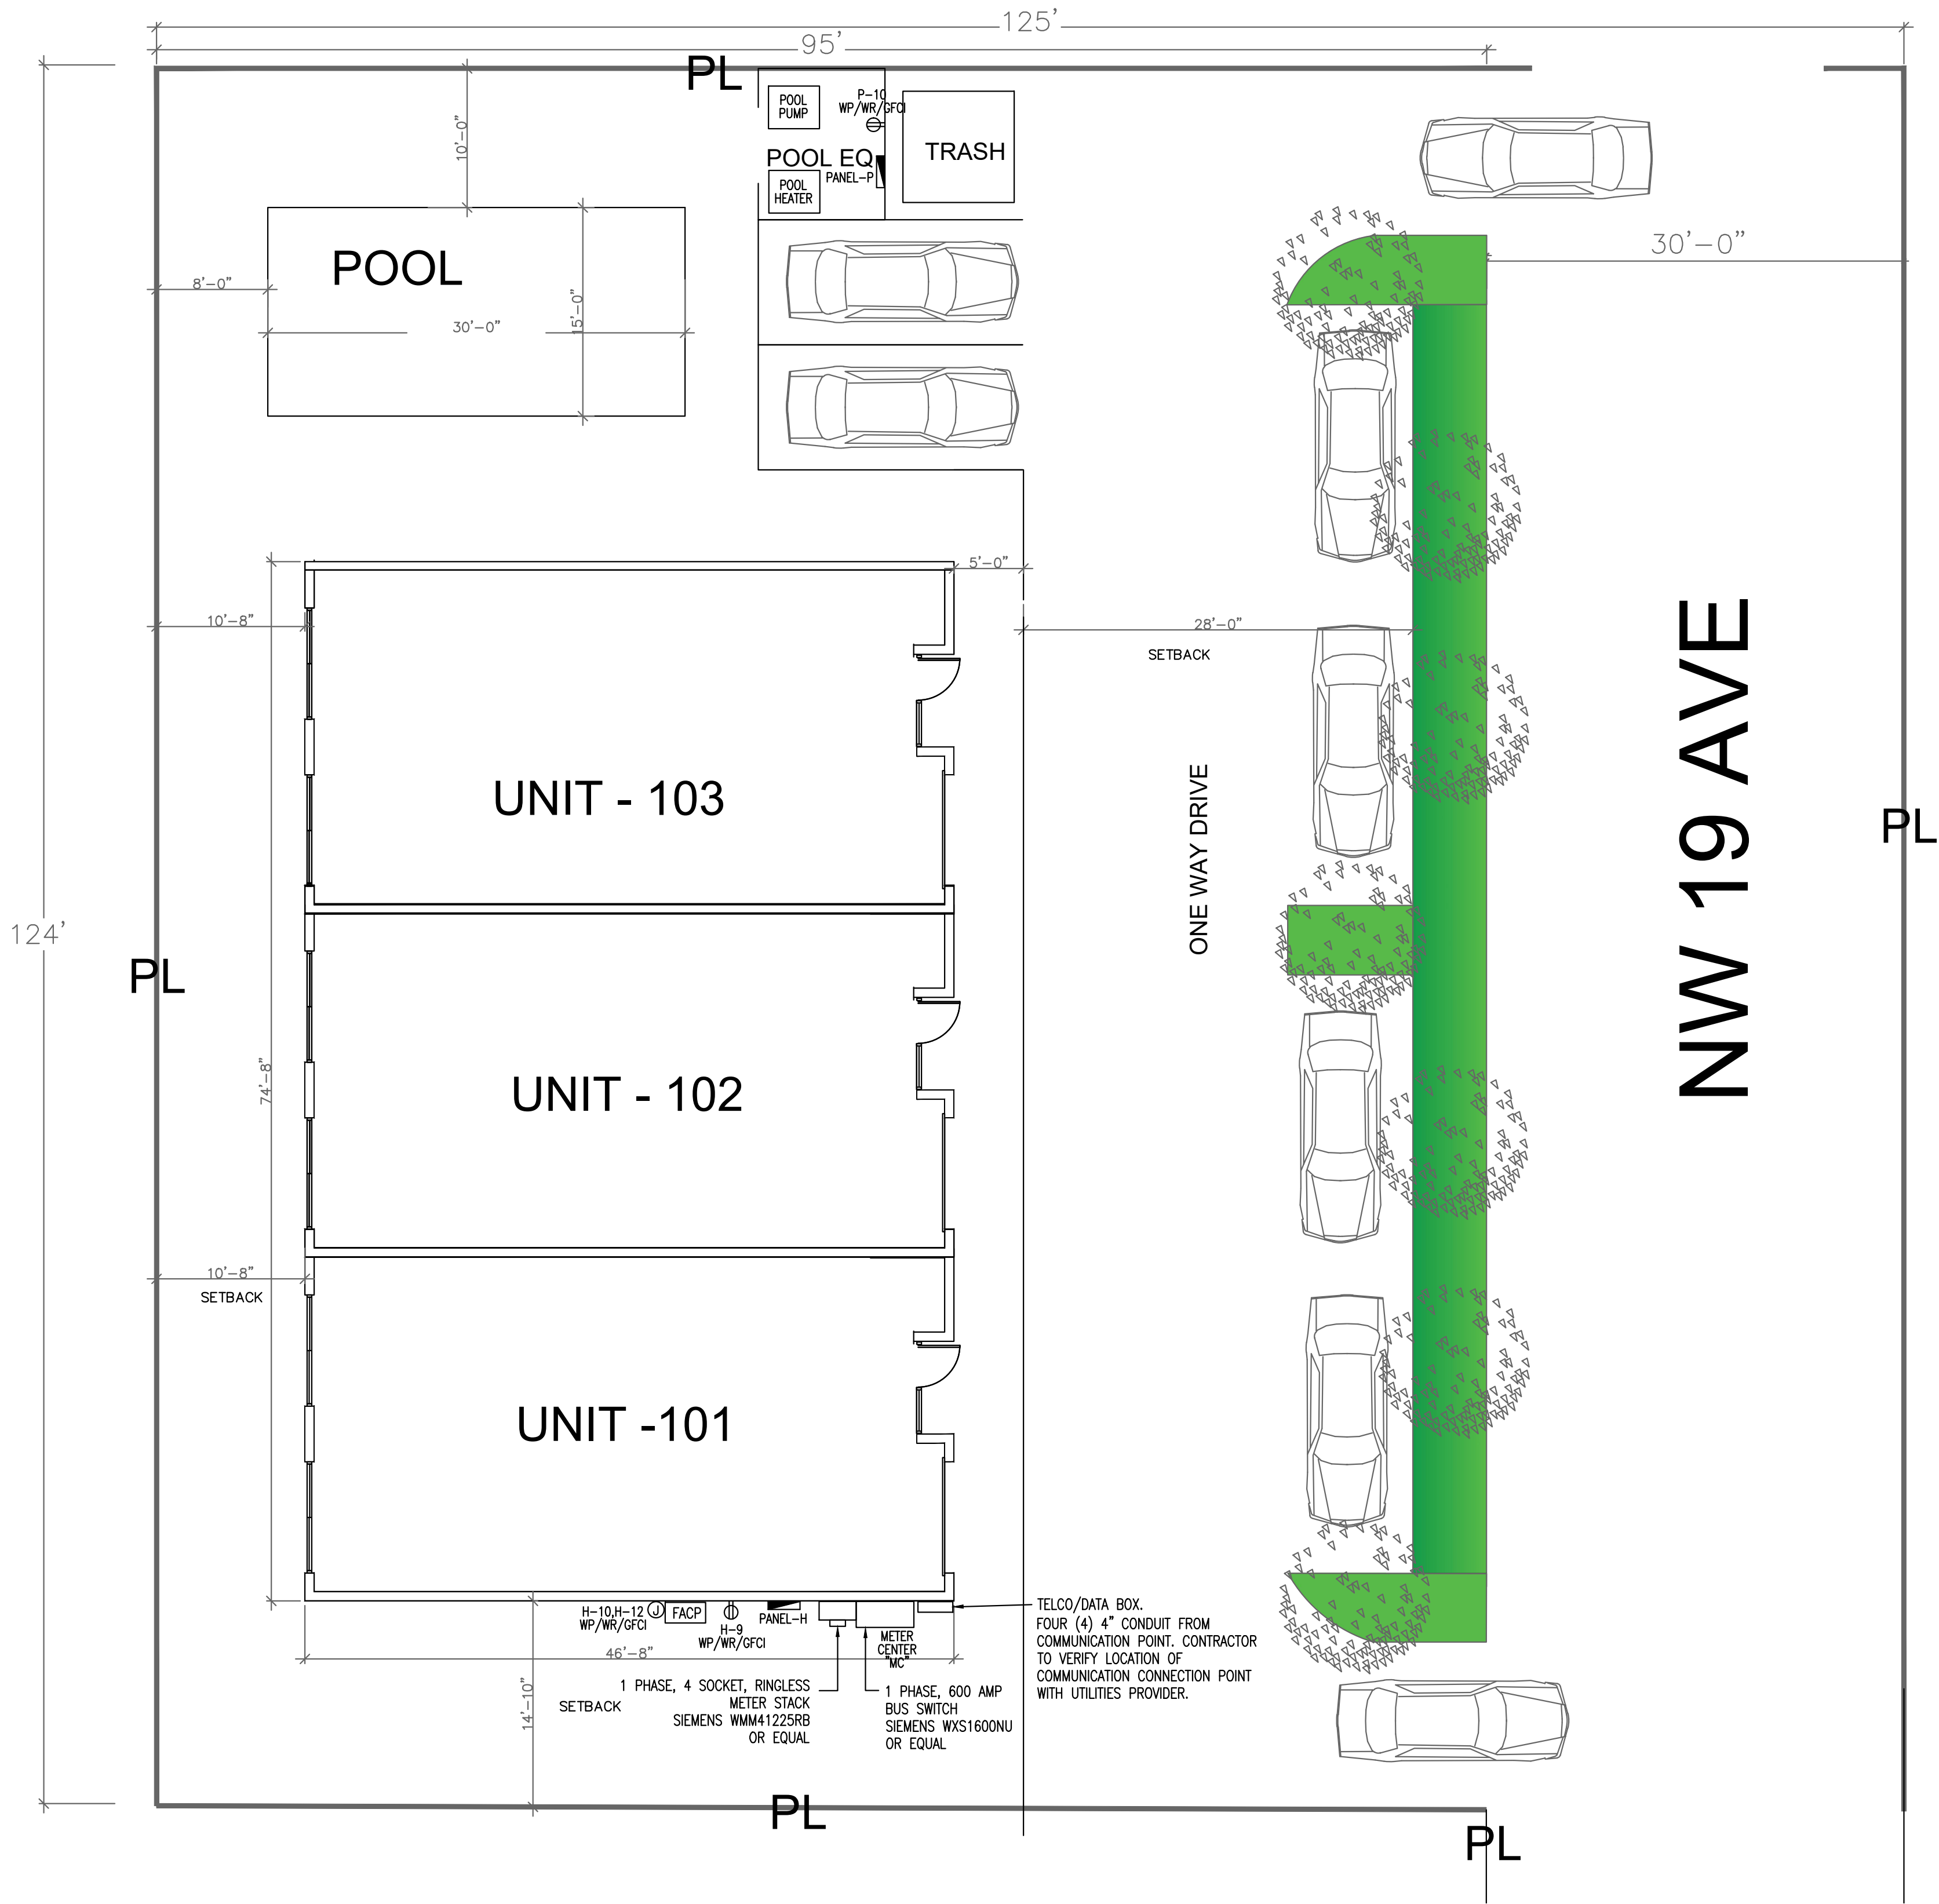

ELECTRICAL SITE PLAN

SCALE: 1/8" = 1'-0"

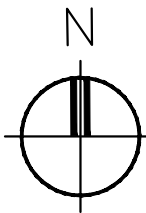


REVISIONS

TOWNHOUSES AT NW 19 AVE
POMPANO BEACH, FL 33069

MIAMI
ARCHITECT
INC.

7755 SW 117 ST. MIAMI, FL 33156
TEL: (305) 256-1720
AA 26000671

TAGHI AFKHAM
STATE OF FLORIDA
ARCHITECT
AR0014758
DATE: 11/23-20

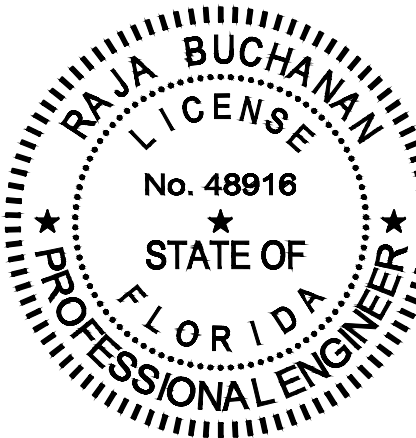

BUCHANAN P.E CONSULTING INC.

ELECTRICAL * MECHANICAL * PLUMBING
ENGINEERING

6191 W. ATLANTIC BLVD, SUITE# 2 MARGATE, FL 33063
Ph: 954-590-3300 Fax: 954-590-2232
Email: BUCHANAN@PEENGINEERS.COM

CERTIFICATE OF AUTHORIZATION # 8842
RAJA BUCHANAN P.E. # 48916