


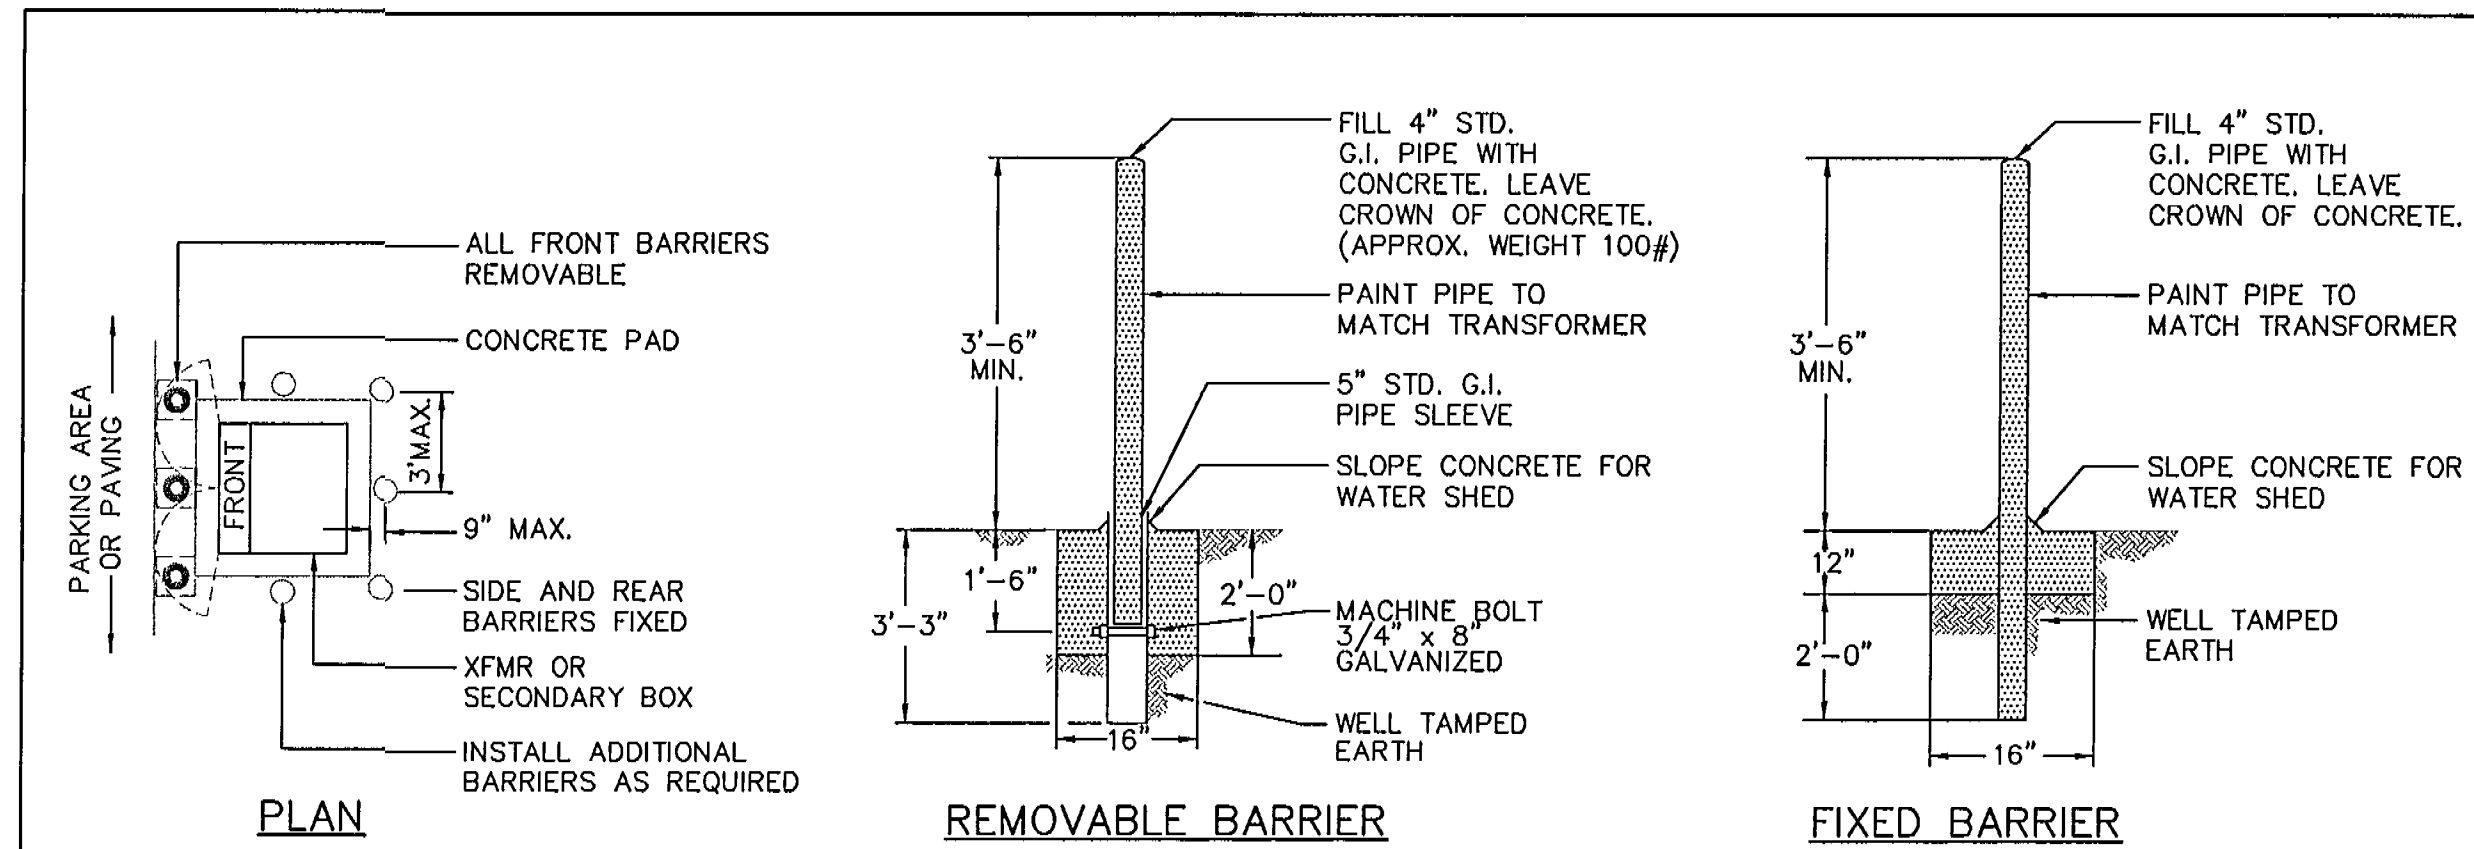

PROTECTIVE BARRIER AND PLANTING CLEARANCES FOR PADMOUNTED TRANSFORMERS


NO SCALE (COORDINATE WITH FP & L)

ELECTRICAL SITE PLAN NOTES

1. PROPOSED LOCATION OF FLORIDA POWER AND LIGHT PAD MOUNTED TRANSFORMER. COORDINATE EXACT LOCATION WITH F&M. COORDINATE ALL REQUIREMENTS WITH RON BURNSON PRIOR TO CONSTRUCTION AT (954) 781-1020.
2. APPROXIMATE TELCO ROOM LOCATION, REFER TO ELECTRICAL PLAN, SHEET E-3.1.
3. (2) 4" TELEPHONE CONDUITS WITH PULLWIRE. CAP EACH CONDUIT AT THE PROPERTY LINE. CONDUITS TO STUB UP 6" AFF AT TELEPHONE BOARD IN THE ELECTRICAL ROOM. COORDINATE WITH BILL SERPE AT BELL SOUTH PRIOR TO CONSTRUCTION AT (954) 423-6222.
4. (2) 4" CONDUITS TO PAD MOUNTED XFMR AS SHOWN. CONDUIT IS FURNISHED BY F&M FURNISHED 90 DEGREE TURNS AT THE PAD MOUNTED TRANSFORMER LOCATION. ELECTRICAL CONTRACTOR IS TO FURNISH AND INSTALL PULLWIRE IN CONDUIT. ELECTRICAL CONTRACTOR IS TO COORDINATE WITH F&M THE EXACT ROUTE OF THE CONDUIT. DEPTH AND OTHER REQUIREMENTS PRIOR TO CONSTRUCTION.

GENERAL NOTES

1. SPLICES IN GROUND JUNCTION BOXES SHALL BE THOROUGHLY COATED WITH AN APPROVED WATERPROOFING COMPOUND, SKOTCHKOTE OR EQUAL.

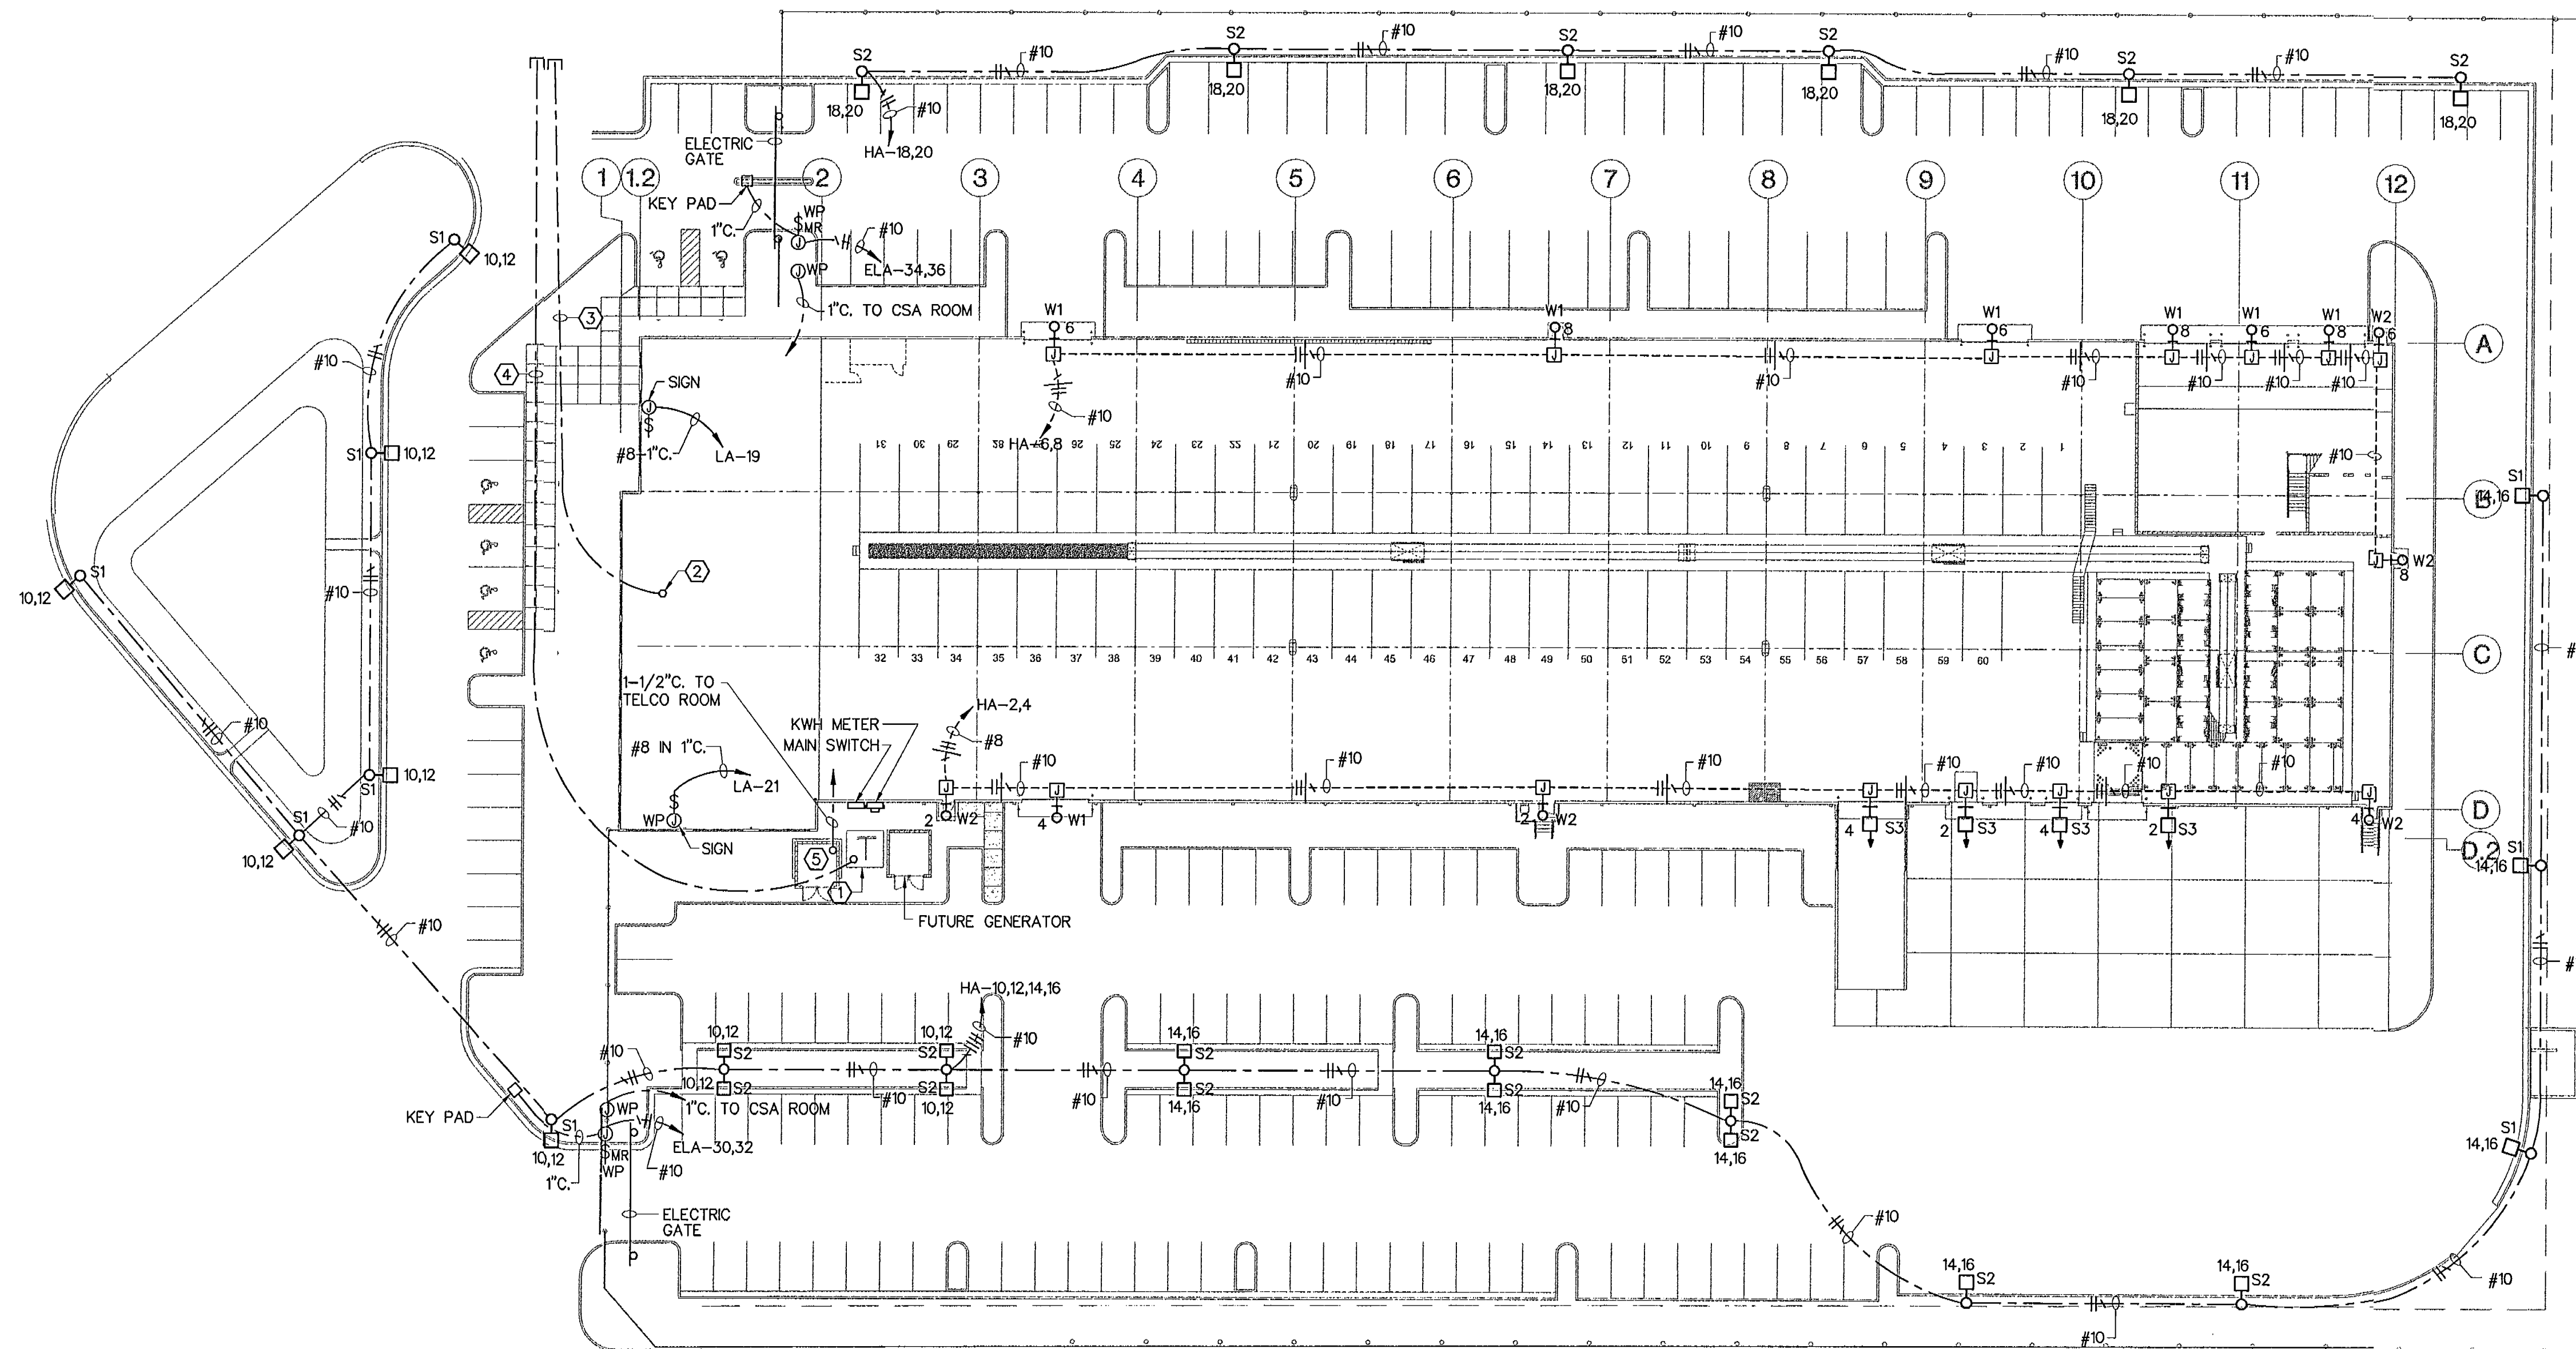

 1 ELECTRICAL SITE PLAN
SCALE: 1"=30'-0"

SCALE: 1"=30'-0"

**Horton,
Harley &
Carter, Inc.**
Architecture Planning Interiors
715 South Howard Avenue SUITE 200
Tampa, Florida 33606
(813) 258-5775 (813) 259-1010 FAX
STATE REGISTRATION NO. AA-00028925

THIS DRAWING IS THE
PROPERTY OF THE
ARCHITECT AND MAY NOT
BE REPRODUCED OR
USED WITHOUT HIS
WRITTEN PERMISSION.

STATE REGISTRATION NO.
AA-0002825

DATE	REMARKS
3/00	REVIEW SET
5/00	SITE AND FOUNDATION PERMIT

[illegible]

REVISIONS	
NO.	REMARKS

**Developments
International, Inc.**
Eastern Region
1100 Satellite Boulevard
Suwanee, Georgia 30174 (770) 252-1500

FedEx
TNT CITY STATION
@ Pompano Business Center "N"

SHEET	DRAWN	JAD	CHECKED	JOB NO.
	E-2			
			CI	70089