


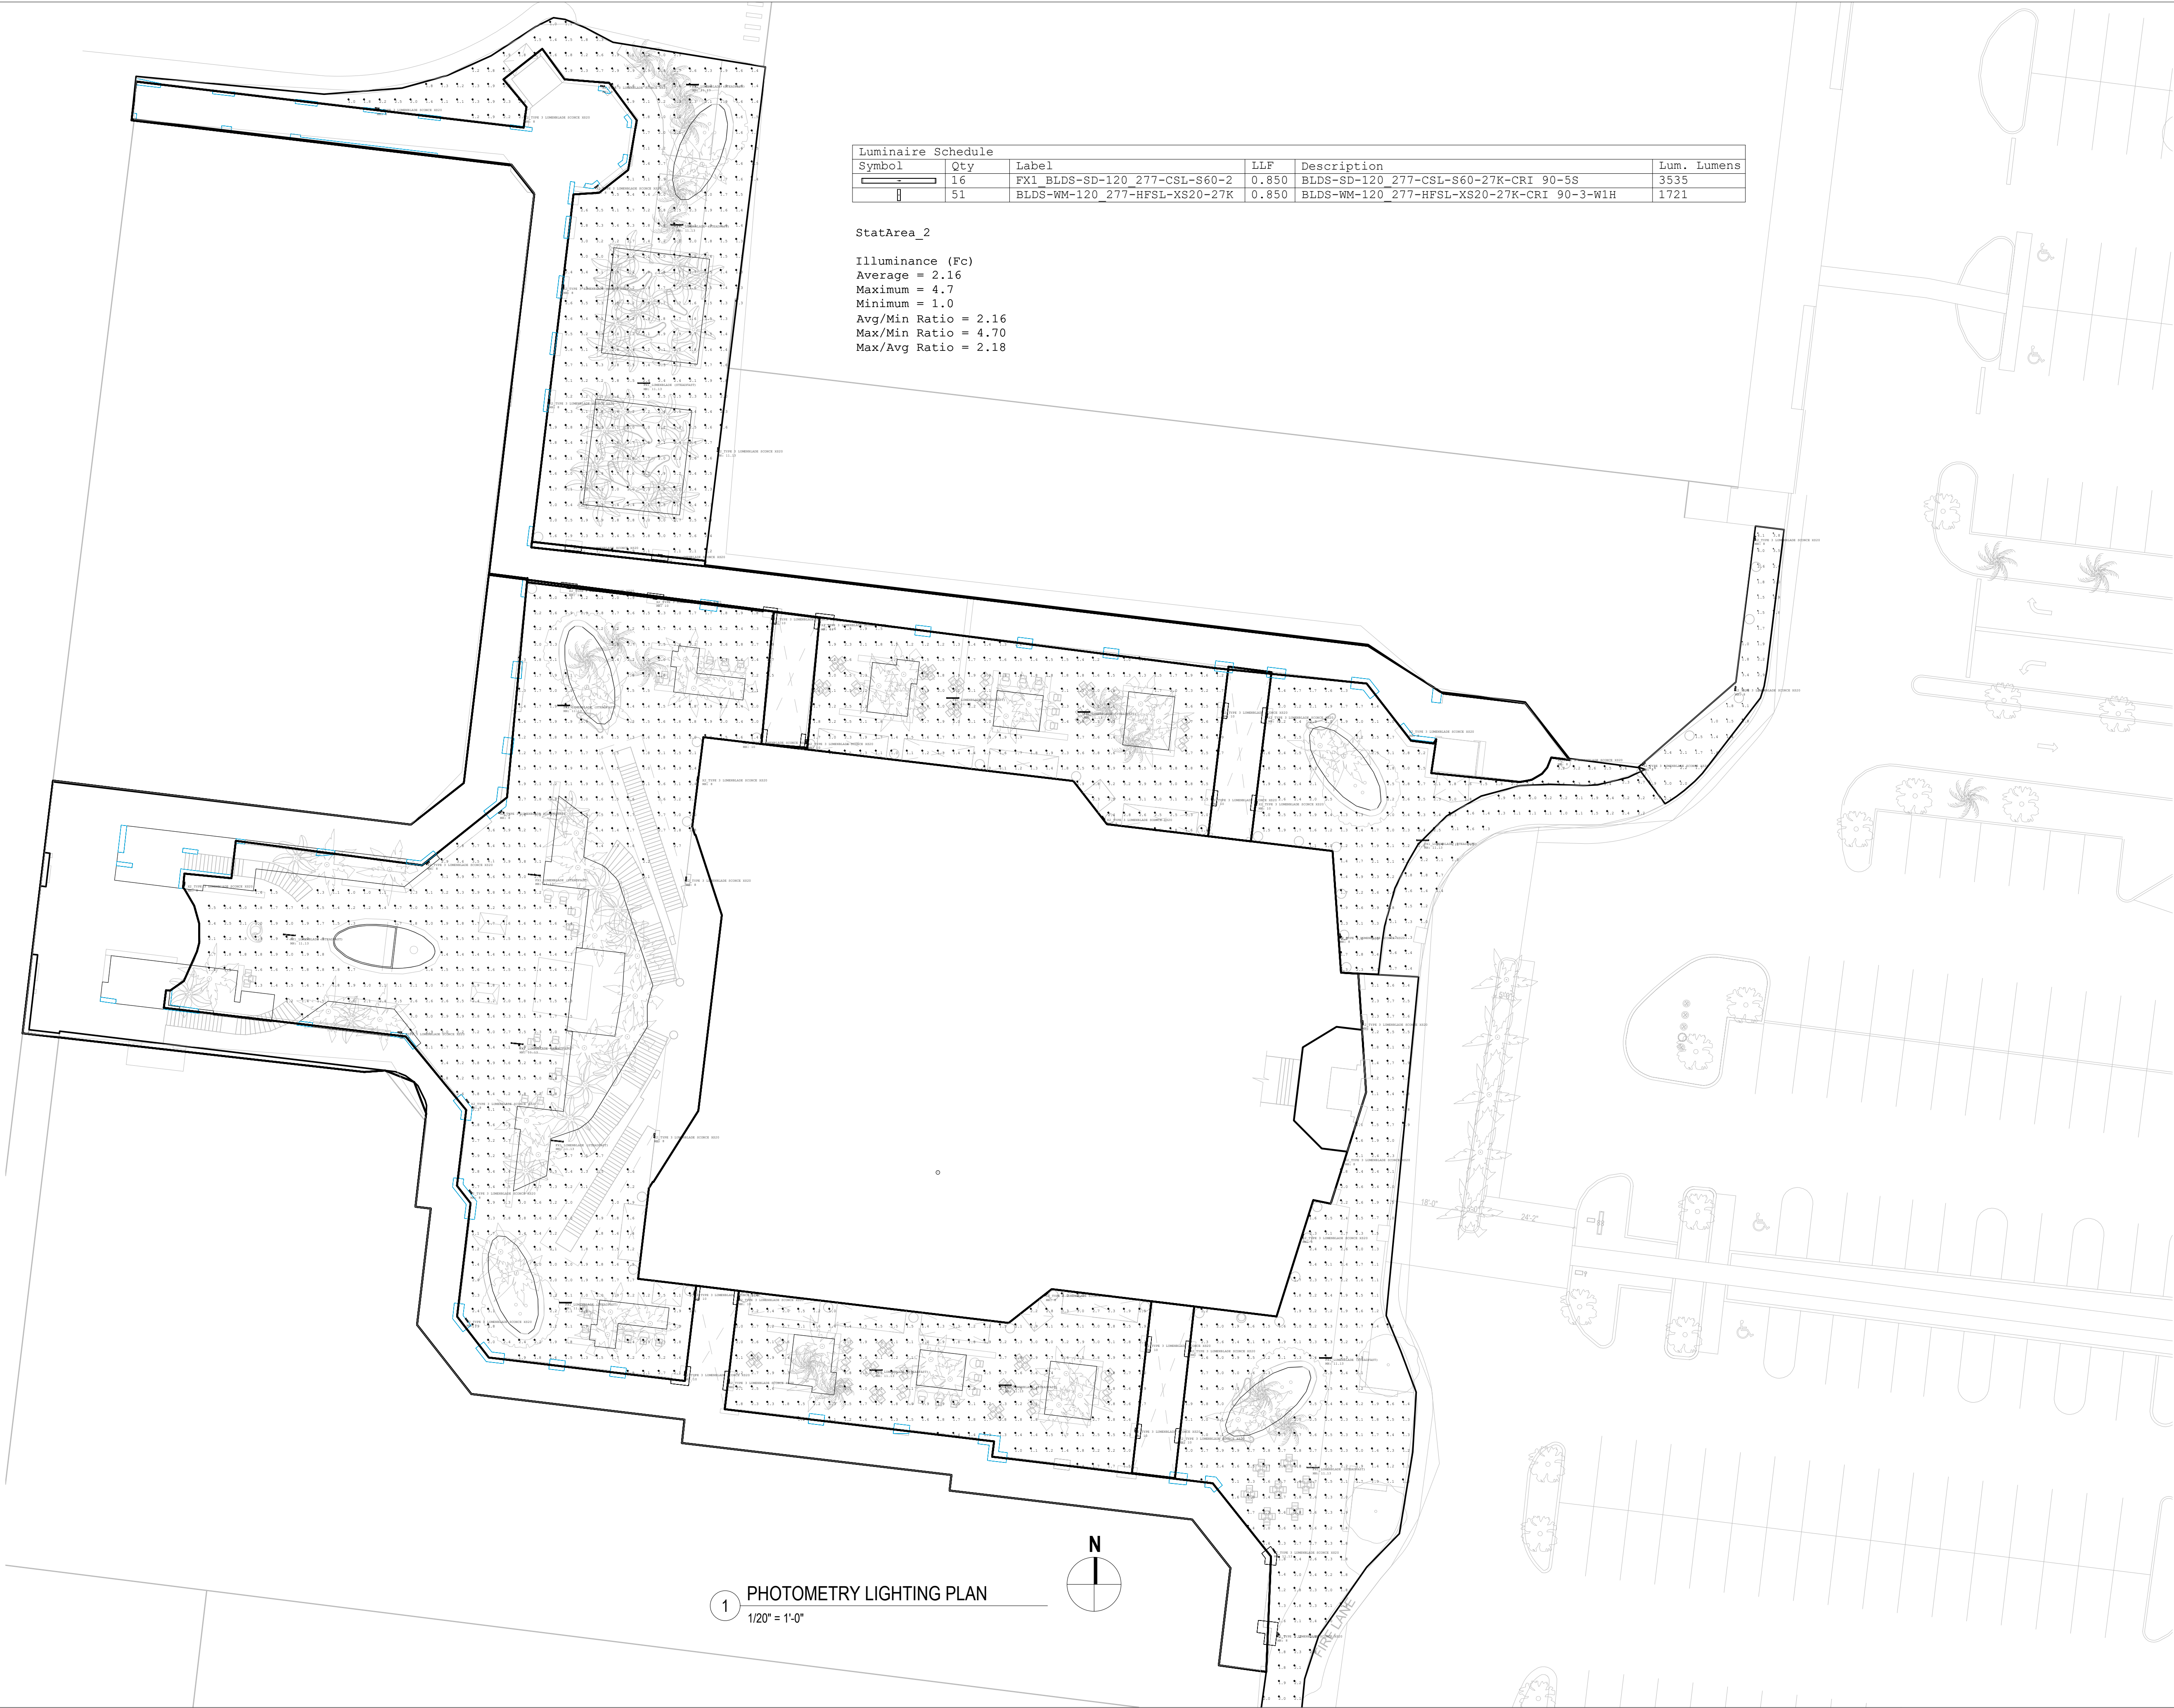

Luminaire Schedule					
Symbol	Qty	Label	LLF	Description	Lum. Lumens
	16	FX1 BLDS-SD-120 277-CSL-S60-2	0.850	BLDS-SD-120 277-CSL-S60-27K-CRI 90-5S	3535
	51	BLDS-WM-120 277-HFSL-XS20-27K	0.850	BLDS-WM-120 277-HFSL-XS20-27K-CRI 90-3-W1H	1721

StatArea_2
Illuminance (Fc)
Average = 2.16
Maximum = 4.7
Minimum = 1.0
Avg/Min Ratio = 2.16
Max/Min Ratio = 4.70
Max/Avg Ratio = 2.18

URBN

10800 BISCAYNE BLVD, SUITE 935, MIAMI, FL 33161
PHONE: 305.720.2079
C.O.A. 33221

ARCHITECT:

JORGE O'VALLE
LICENSE # 94068

LIGHTING DESIGNER:

This item has been digitally signed and sealed by Jorge O'Valle R.A. on the date adjacent to the seal. Printed copies of this document are not considered signed and sealed and the signature must be verified on any electronic copies.
Copyright 2026 By: URBN Design Architecture LLC

OWNER:

REVISIONS:

No.	DATE	DESCRIPTION

PROJECT MANAGER: JO

POMpano CITI CENTRE
COMMON AREAS REMODELING
SITE PLAN SUBMITTAL

1300 - 1460 NE 23 ST POMpano BEACH FL 33062
2251 - 2287 N FEDERAL HWY POMpano BEACH FL 33062

PHOTOMETRICS LIGHTING PLAN

PROJECT NUMBER: C015

PROJECT ISSUE DATE: 06-10-2026

SHEET NUMBER:

PH100