



1 COURT LIGHTING PLAN
SCALE: 3/32" = 1'-0" (24 x 36 sheet)

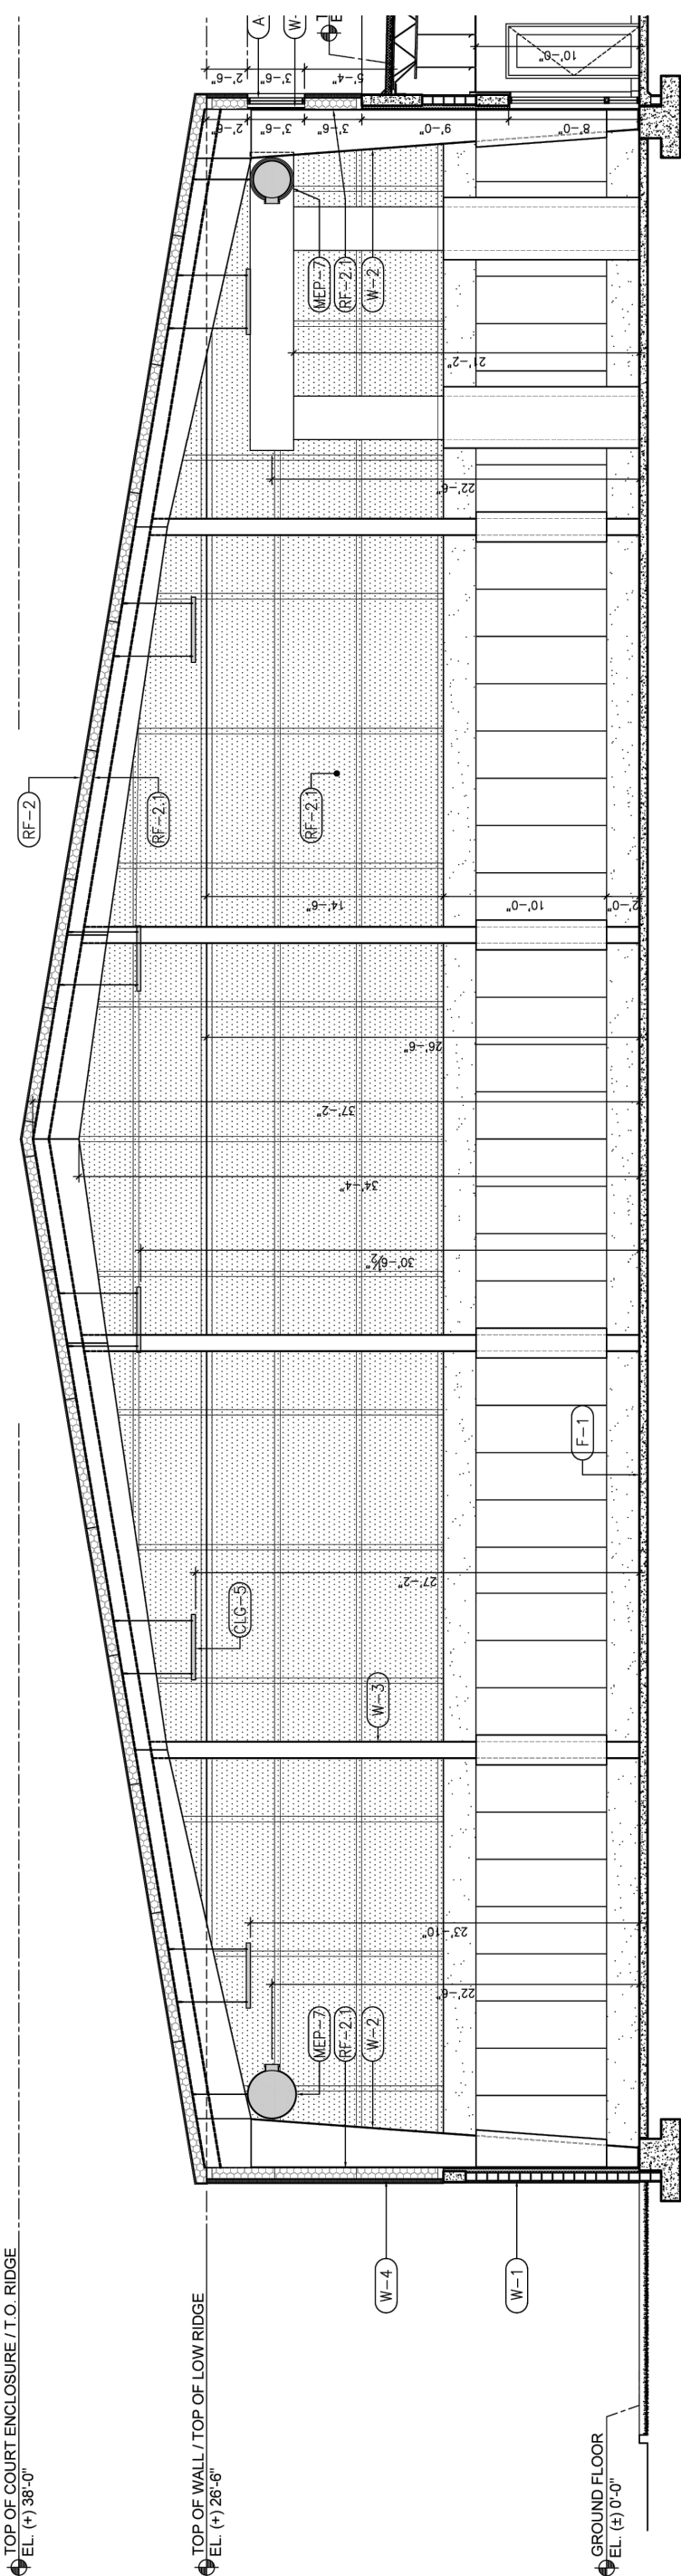

3 COURT LIGHTING ELEVATIONS
SCALE: 3/32" = 1'-0" (24 x 36 sheet)

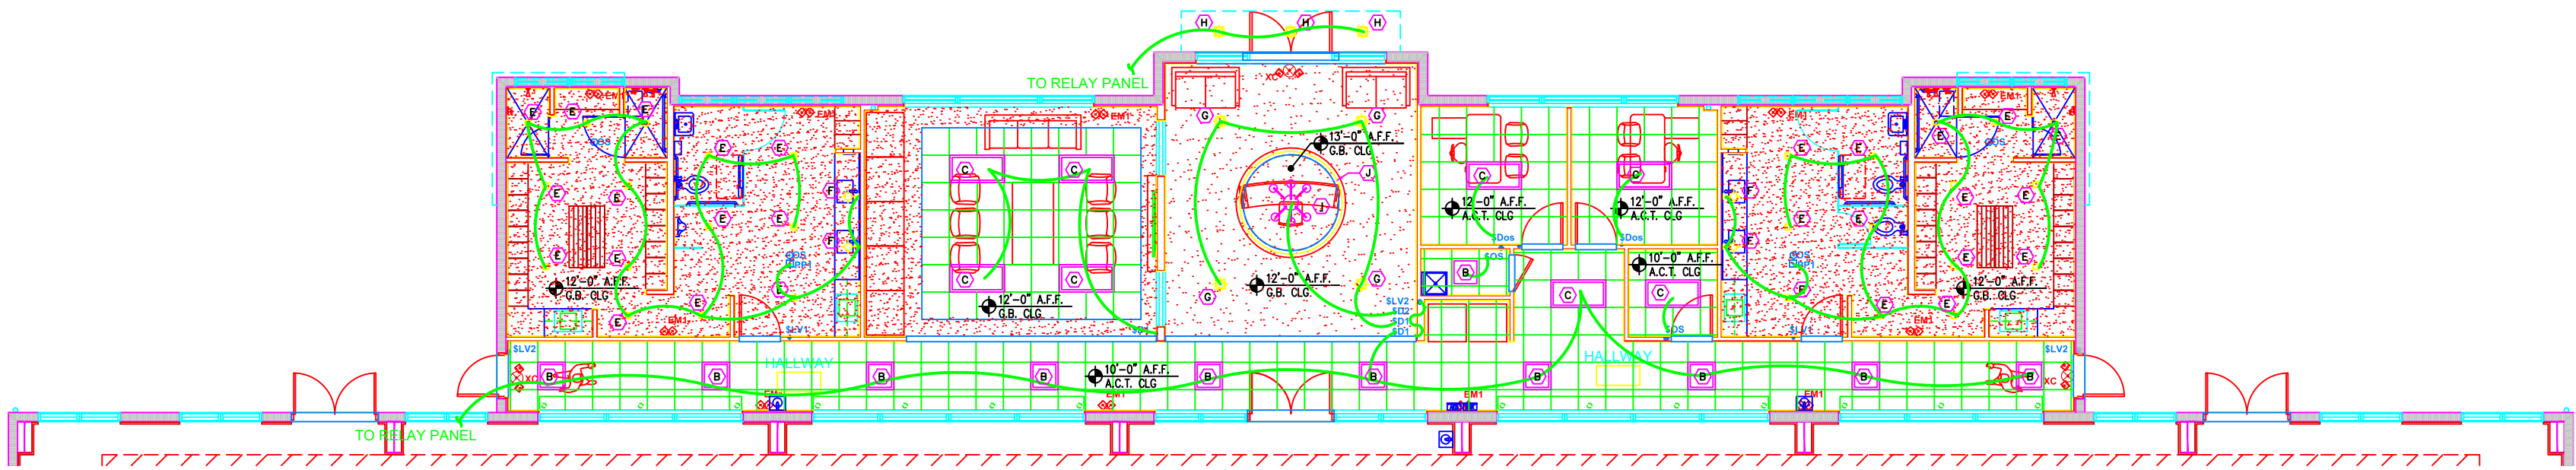


2 FIRST FLOOR OFFICE LIGHTING PLAN
SCALE: 3/32" = 1'-0" (24 x 36 sheet)

All electrical work shall comply with National, State, and Local codes including and not limited to the National Electric Code, NFPA 101 Life Safety Code, ASHREA and /or IECC Energy Codes.

The information contained in this document is proprietary to CBMC Lighting Solutions. This document is prepared for a specific site and incorporates calculations based on data available from the client at this time. By accepting and using this document, the recipient agrees to protect its contents from further dissemination, (other than that within the organization necessary to evaluate such specification) without the written permission of CBMC Lighting Solutions. the contents of this document are not to be reproduced or copied in whole or in part without the written permission of CBMC Lighting Solutions. copyright © 2025 CBMC Lighting Solutions all rights reserved.

CBMC • LIGHTING SOLUTIONS

5855 KOPETSKY DR. SUITE G. | INDIANAPOLIS, IN 46217
317-780-8350 | WWW.CBMCINC.COM

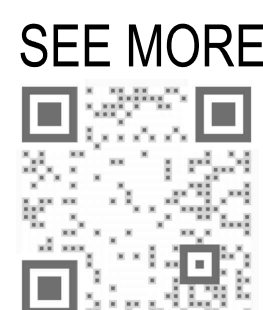

This lighting pattern represents illumination levels calculated from laboratory data taken under controlled conditions in accordance with IESNA approved methods. Actual performance of any manufacturer's luminaire may vary due to variation in electrical voltage, tolerance in lamps and LED lumen package, location adjustments, and other variable field conditions.

Contractor to check and verify all dimensions on site before commencing any work shown.

National Lighting Program Vendor
For pricing and technical assistance contact:
CBMC INC
317-626-1590
Pete Miller - Program Manager- pmiller@cbmcinc.com
Jennifer Karesh-Project Manager - jkaresh@cbmcinc.com
William Proctor - Project Engineer - wproctor@cbmcinc.com



DRAWING INDEX:
LP1: OVERVIEW OF LIGHTING PLAN
LP2: OFFICE LIGHTING / SCHEDULES
LP3: ENCLOSED TENNIS COURT LIGHTING PLANS
LP4: LIGHTING CONTROLS AND INSTALLATION DETAILS
LP5: EMERGENCY LIGHTING CALCULATIONS.
LP6: RENDERINGS

FLORIDA INDOOR TENNIS Lighting Plan & Renderings				Revision	
Scale:	1/16" = 1'-0"	Project No:	CB23408-SL-R2		
Date:		Drawn By:	WP		
Checked By:	PM / JK				

P223-12000009

03/05/2025