




**SITE LIGHTING PLAN**  
SCALE: 1/32" = 1'-0" (24 x 36 sheet)

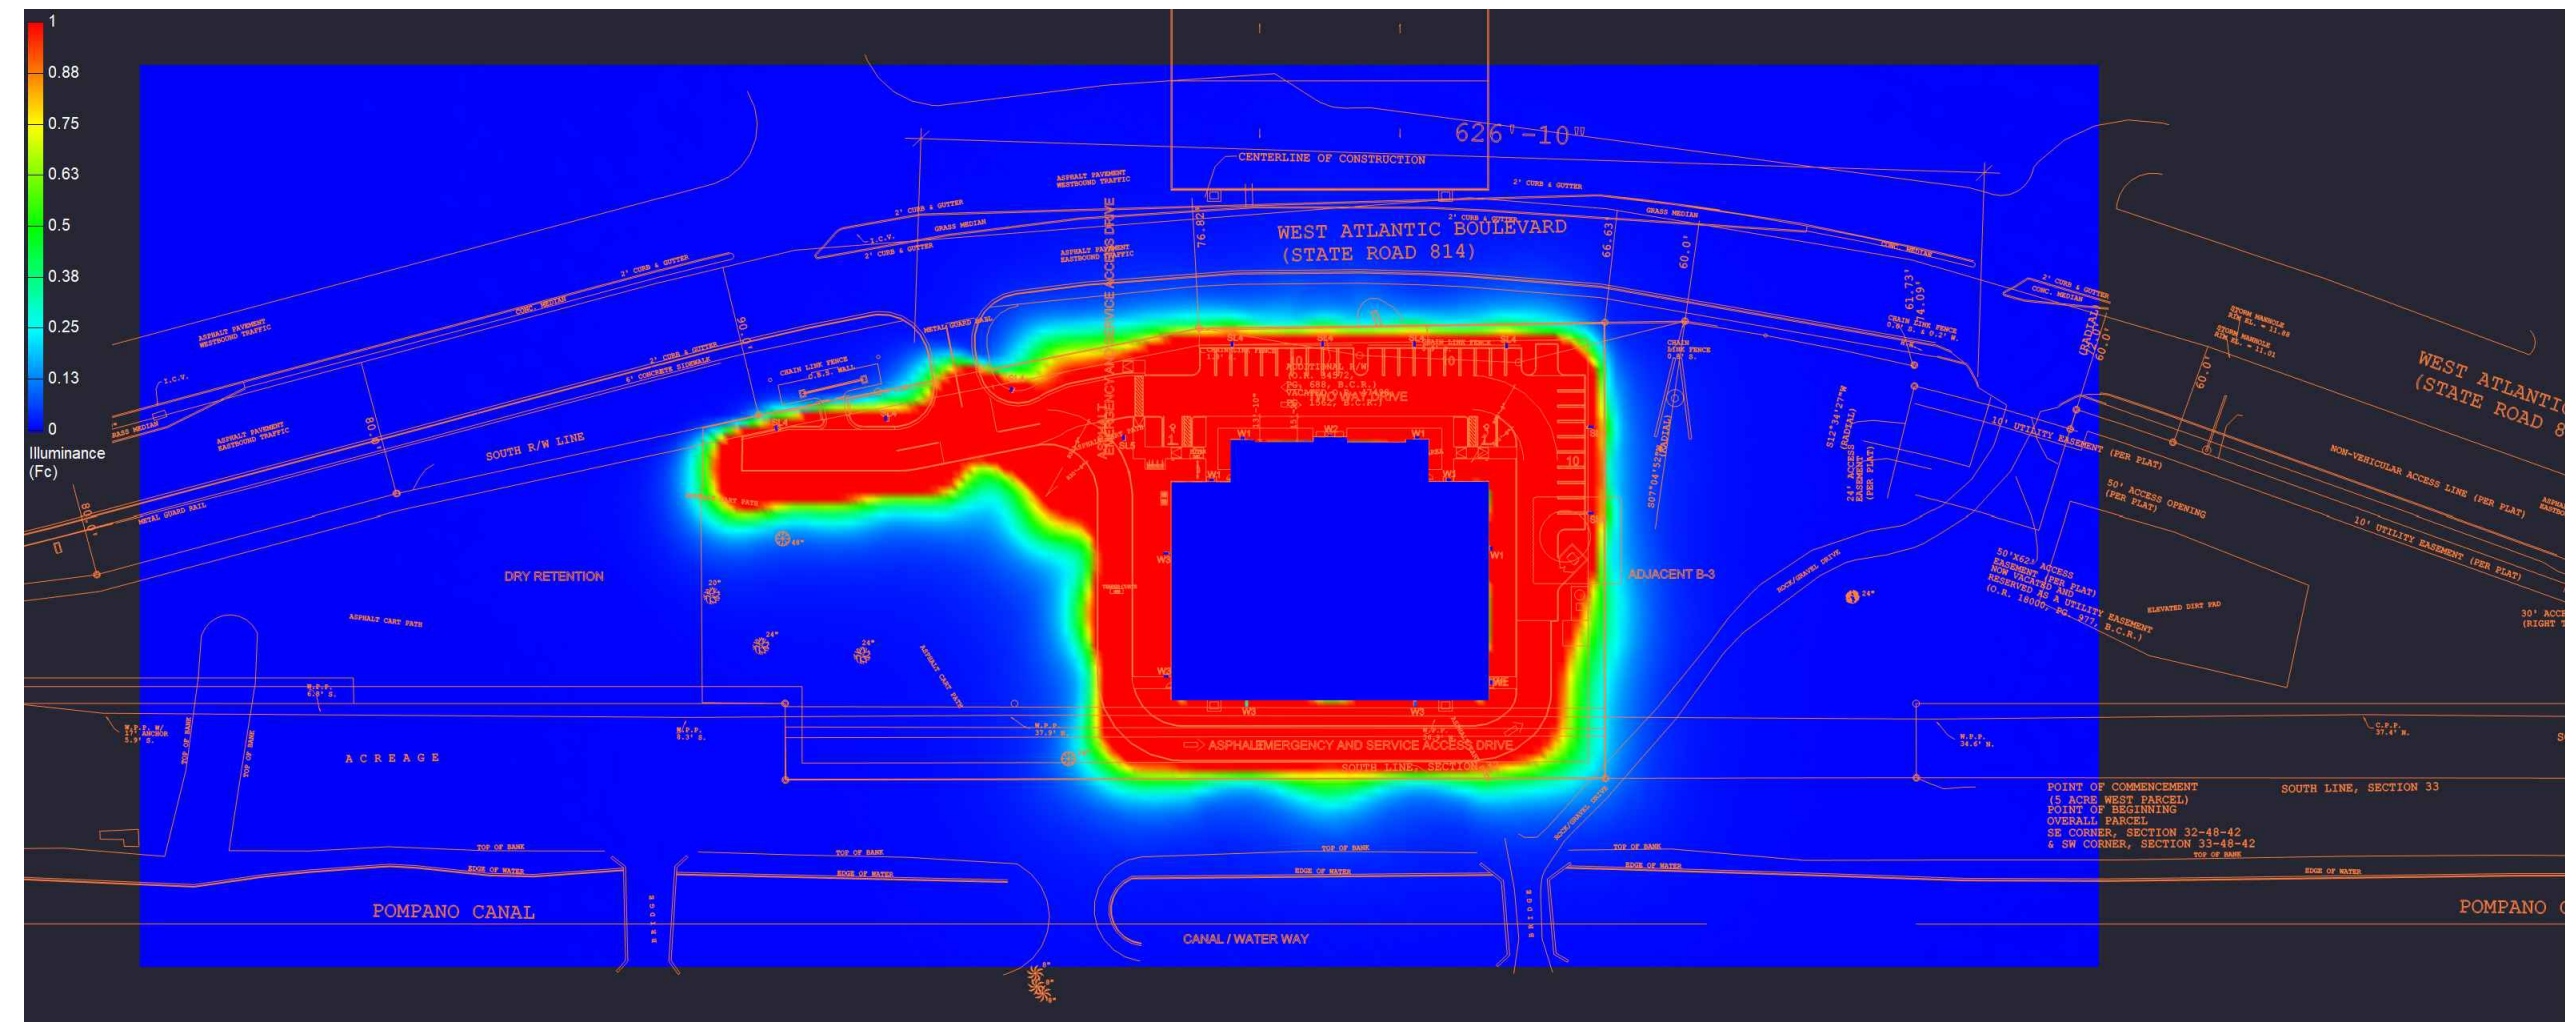

**PSEUDO COLOR PLAN VIEW RENDERING**  
SCALE: NTS

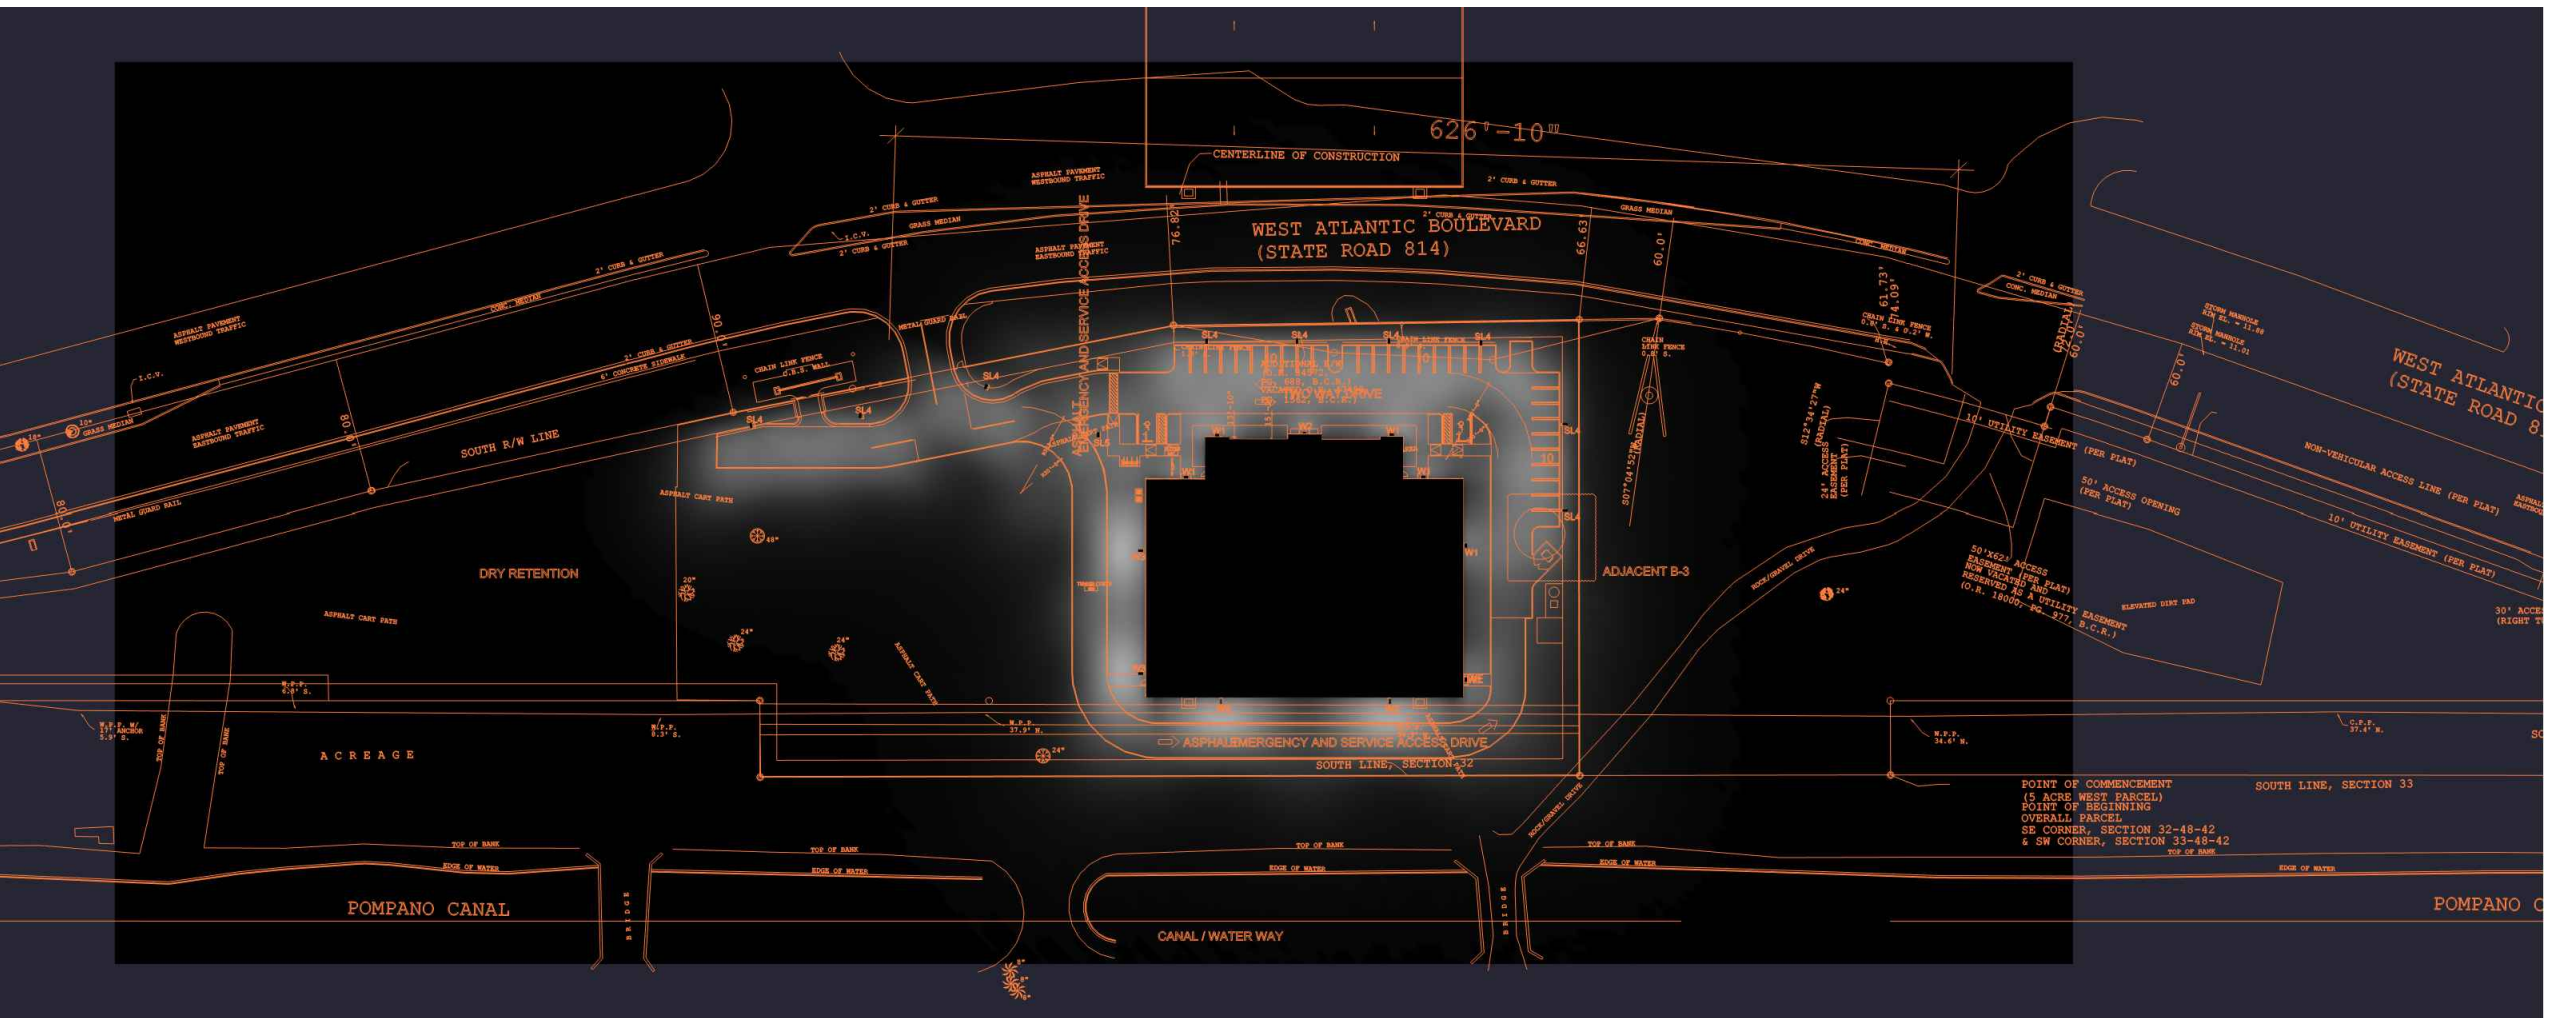

**GRAYSCALE PLAN VIEW RENDERING**  
SCALE: NTS

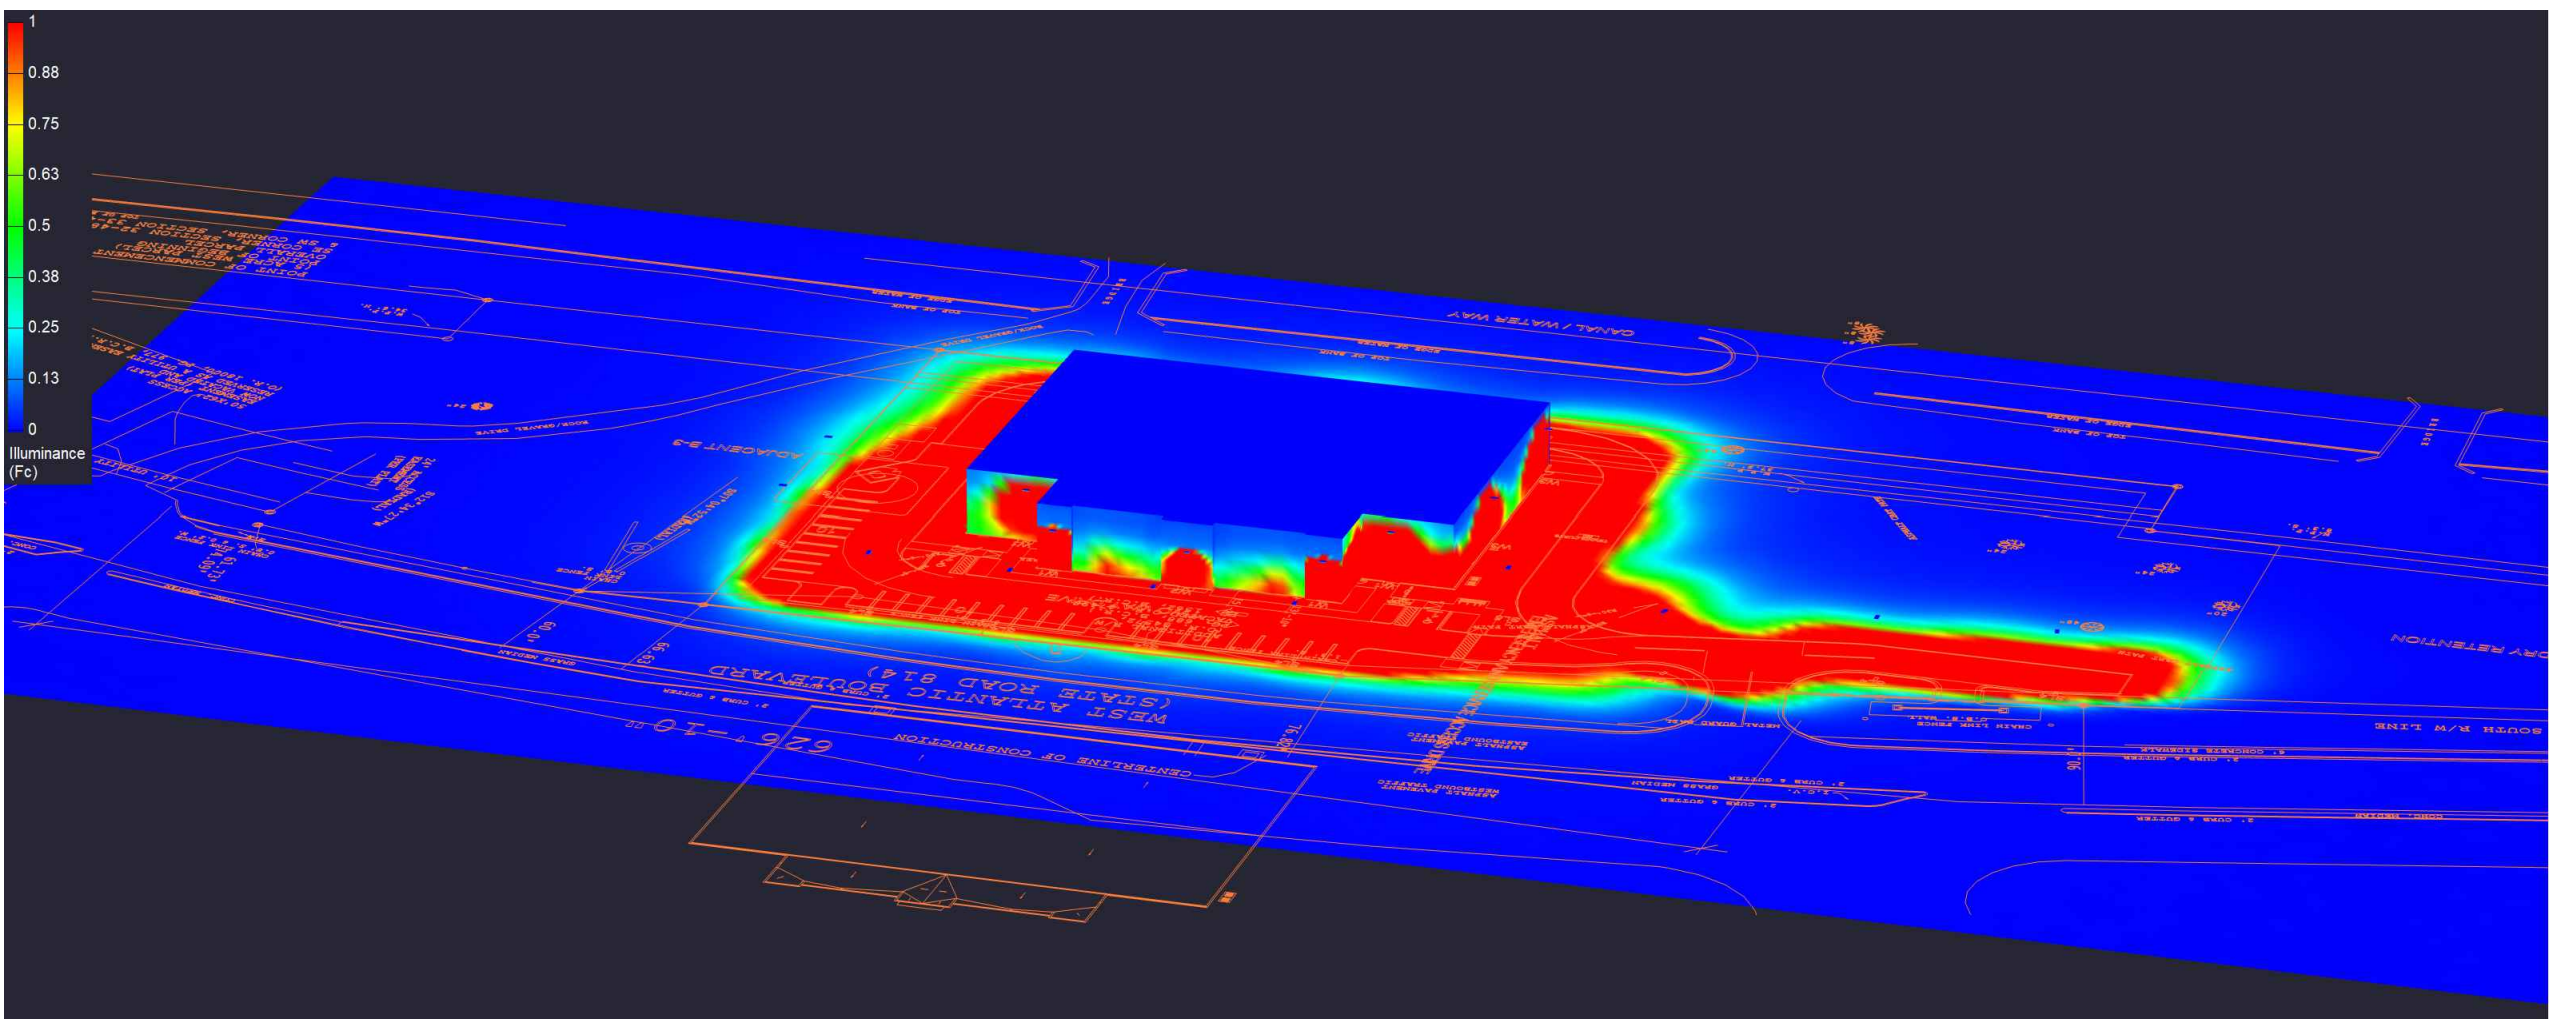

**ISOMETRIC PSEUDO COLOR RENDERING**  
SCALE: NTS

National Lighting Program Vendor  
For pricing and technical assistance contact:  
CBMC INC  
317-626-1590  
Pete Miller - Program Manager- [pmiller@cbmcinc.com](mailto:pmiller@cbmcinc.com)  
Jennifer Karesh-Project Manager - [jkaresh@cbmcinc.com](mailto:jkaresh@cbmcinc.com)  
William Proctor - Project Engineer - [wproctor@cbmcinc.com](mailto:wproctor@cbmcinc.com)

**DRAWING INDEX:**  
SL1: SITE LIGHTING PLAN AND RENDERINGS  
SL2: PHOTOMETRY  
SL3: LIGHTING CONTROLS AND DETAILS