


ROOF DRAINAGE PLAN
BUILDING 12

SCALE: 1/4"=1'-0"

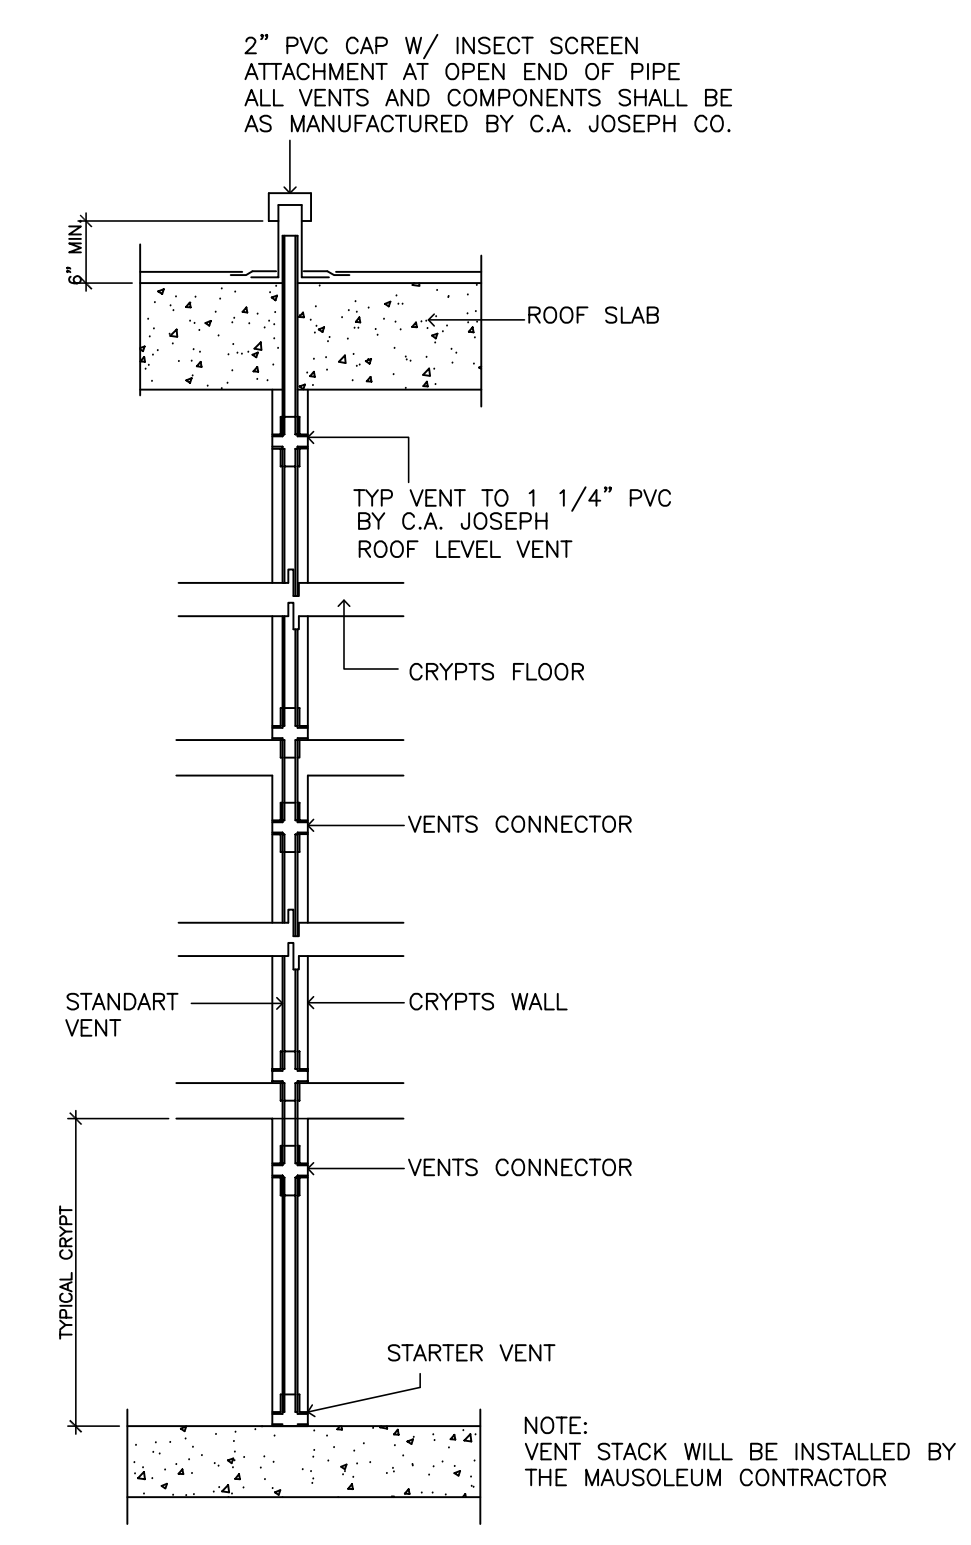

VENT STACK DETAIL
SCALE: NTS

