


Calculation Summary							
Label	CalcType	Units	Avg	Max	Min	Avg/Min	Max/Min
PL-EAST	Illuminance	Fc	0.32	1.3	0.0	N.A.	N.A.
PL-SOUTH	Illuminance	Fc	0.00	0.0	0.0	N.A.	N.A.
PL-WEST	Illuminance	Fc	0.78	1.7	0.0	N.A.	N.A.
TRUCK PARKING_Planar	Illuminance	Fc	2.50	4.6	1.0	2.50	4.60

Luminaire Schedule									
Symbol	Label	[MANUFAC]	Description	Qty	Arrangement	Total Lamp Lumens	LLF	Lum. Watts	Total Watts
	FPL-1	①	ARCH-N-PA1-40-730-U-T3-42W	1	Single	N.A.	0.900	42	42
	P4S	LSI LIGHTING	VALM-42L-4F-30K8-IS	2	Single	N.A.	0.900	261	522

SOUTH ANDREWS AVENUE  
S.W. 12th AVENUE

KEY NOTES	
①	LED STREET LIGHT LEASED FROM FPL, MOUNTED ON POWER POLE AT 15' AFG.

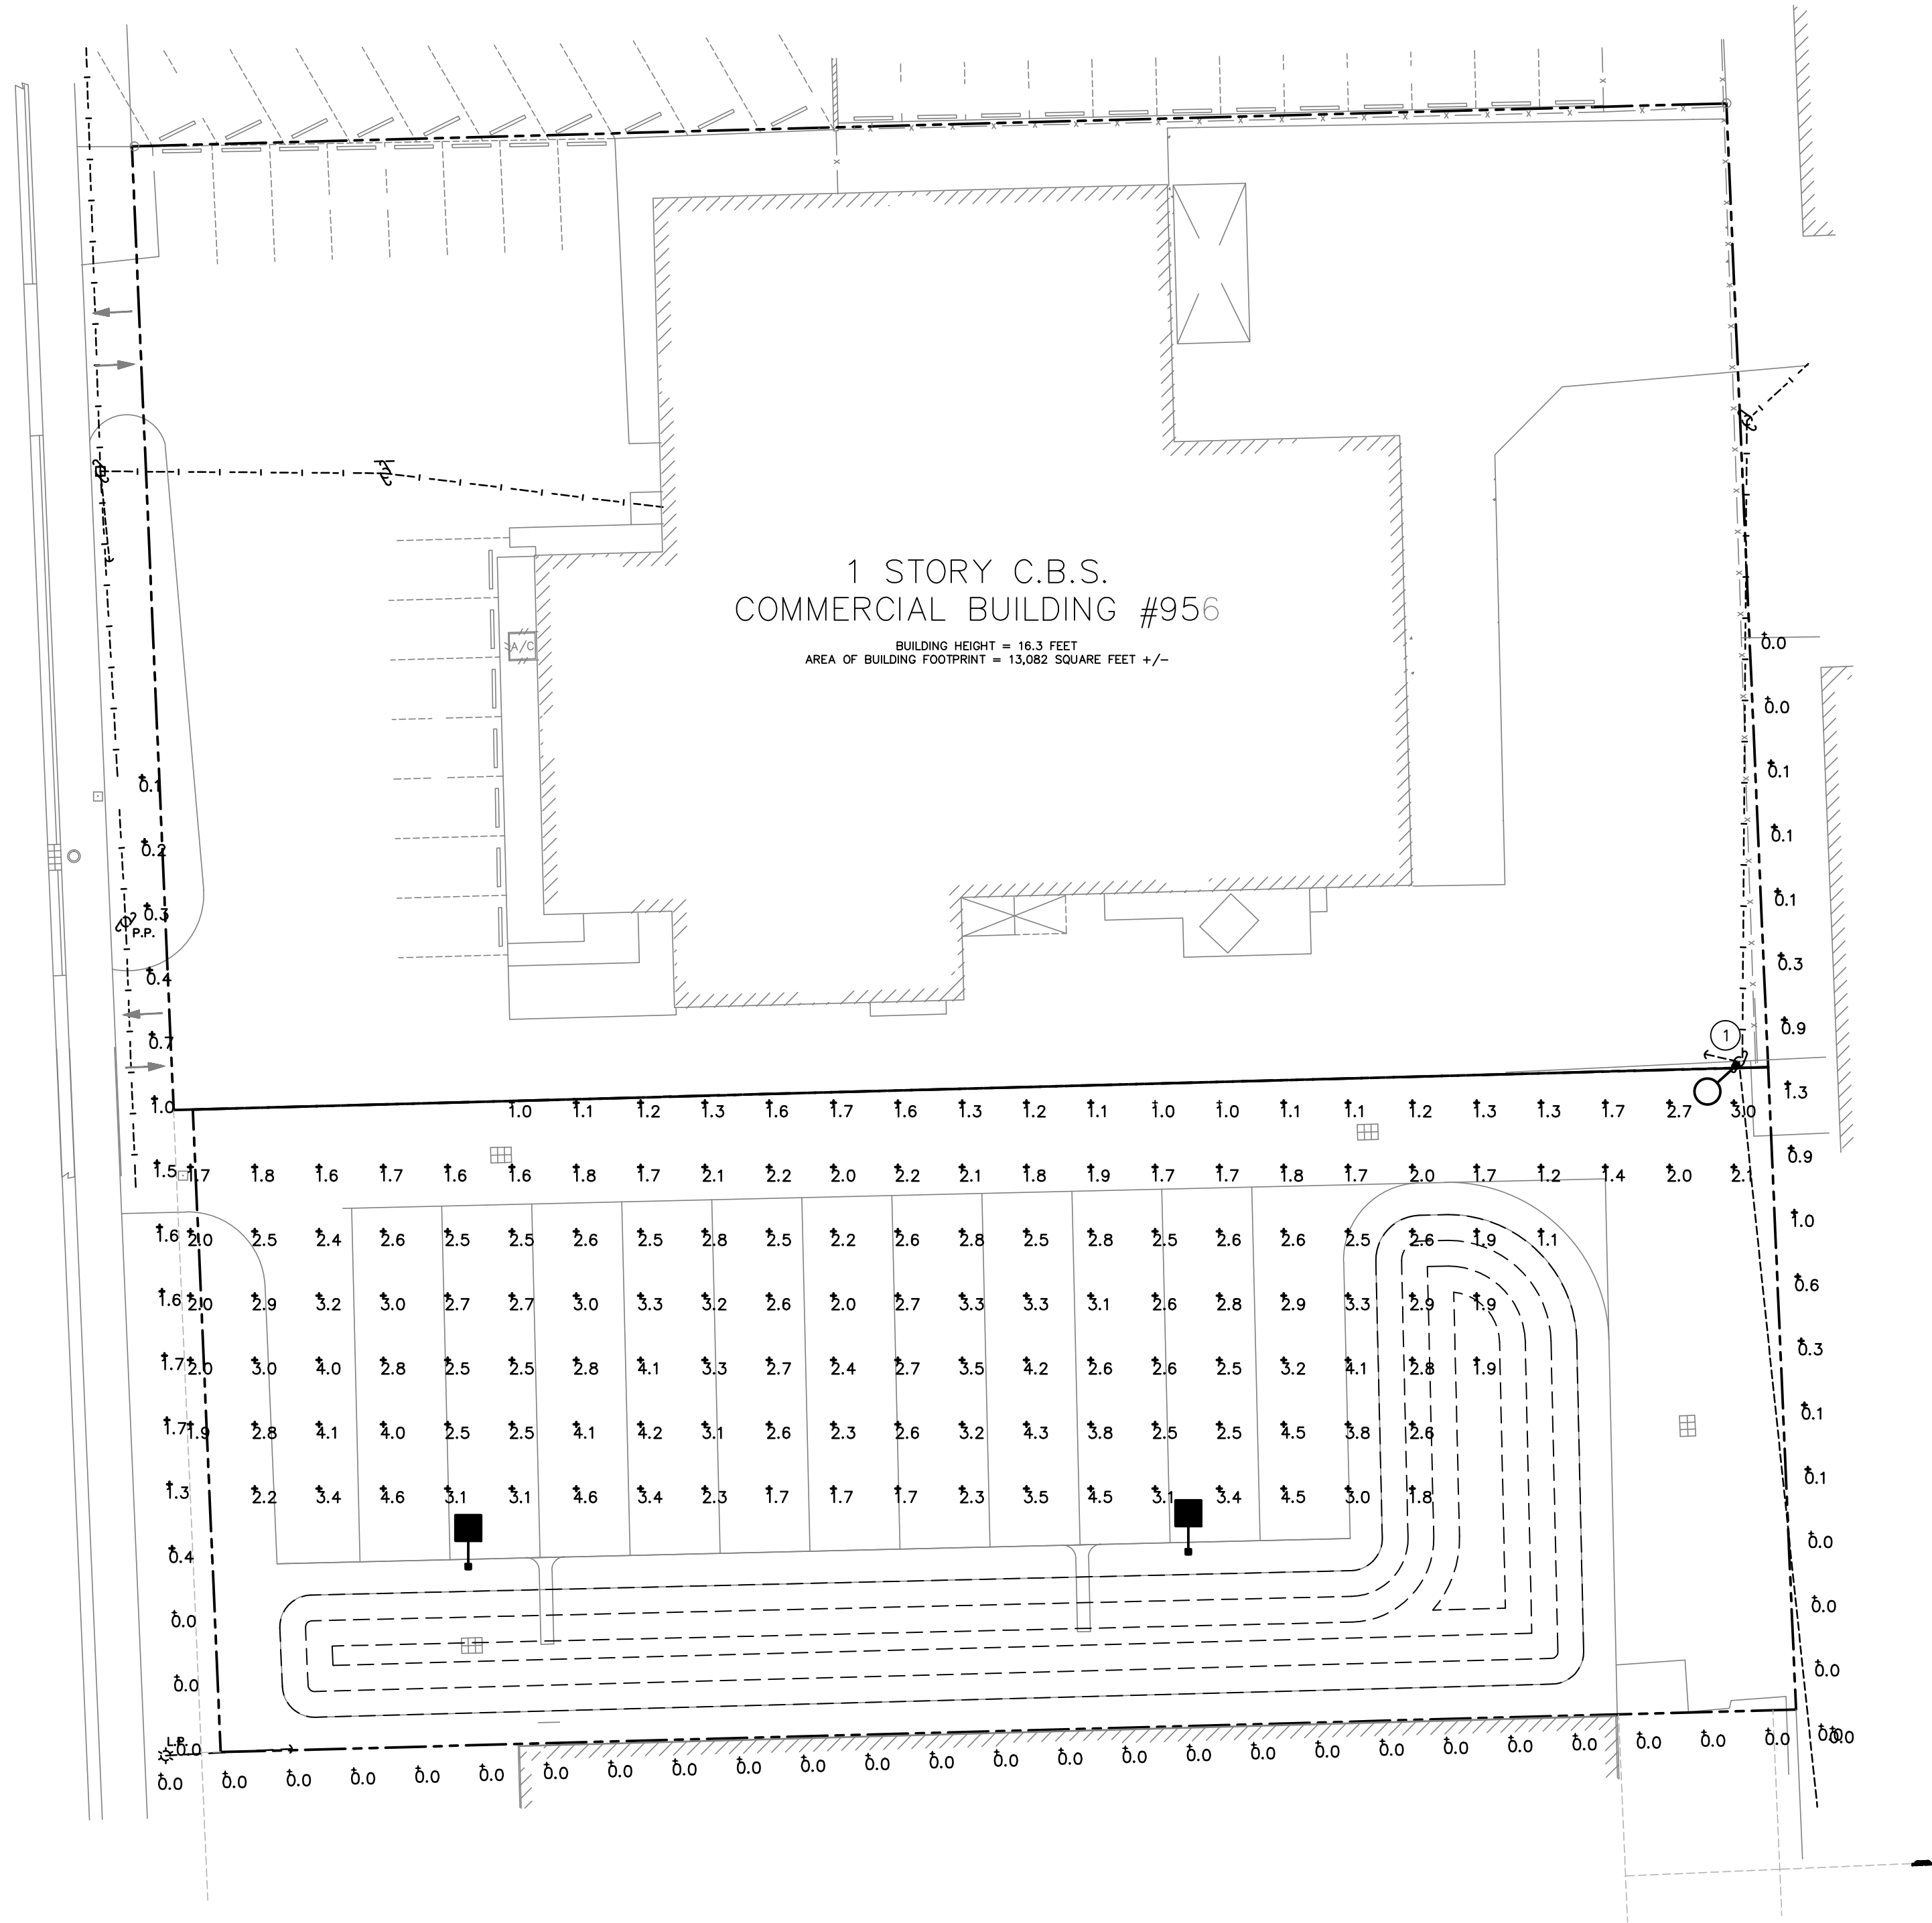

**SITE PHOTOMETRIC PLAN**

1"=20'-0" NORTH

PERMIT ISSUED  
CONSTRUCTION ISSUED

**DRC**

date	
revision	

1407 West Newport Center Drive  
Pompano Beach, FL 33062  
Phone 954.949.2200 Fax 954.949.2201  
Engineering & Construction Consulting  
KAMM Consulting  
4-1-2025  
date  
signed

Joefran Investments  
980 SW 12TH AVENUE  
POMPAHO, FLORIDA

**SITE PHOTOMETRIC PLAN**

project title:  
sheet title:

proj. no.:	2025-0094
project manager:	GK
checked by:	RAK
scale:	AS NOTED
date:	03/24/2025

sheet

**E1.1**

project