


DESIGNED	DRAWN	CHECKED
JY	JJ	JY

REVISIONS

DATE:	COMM:
01/12/24	22019


580 BRINY AVE.

580 BRINY AVE.
POMPAN0 BEACH, FL

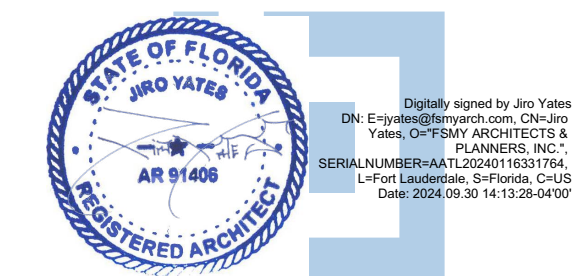

GROUND LEVEL
PHOTOMETRIC PLAN
SITE PLAN APPROVAL

A-501

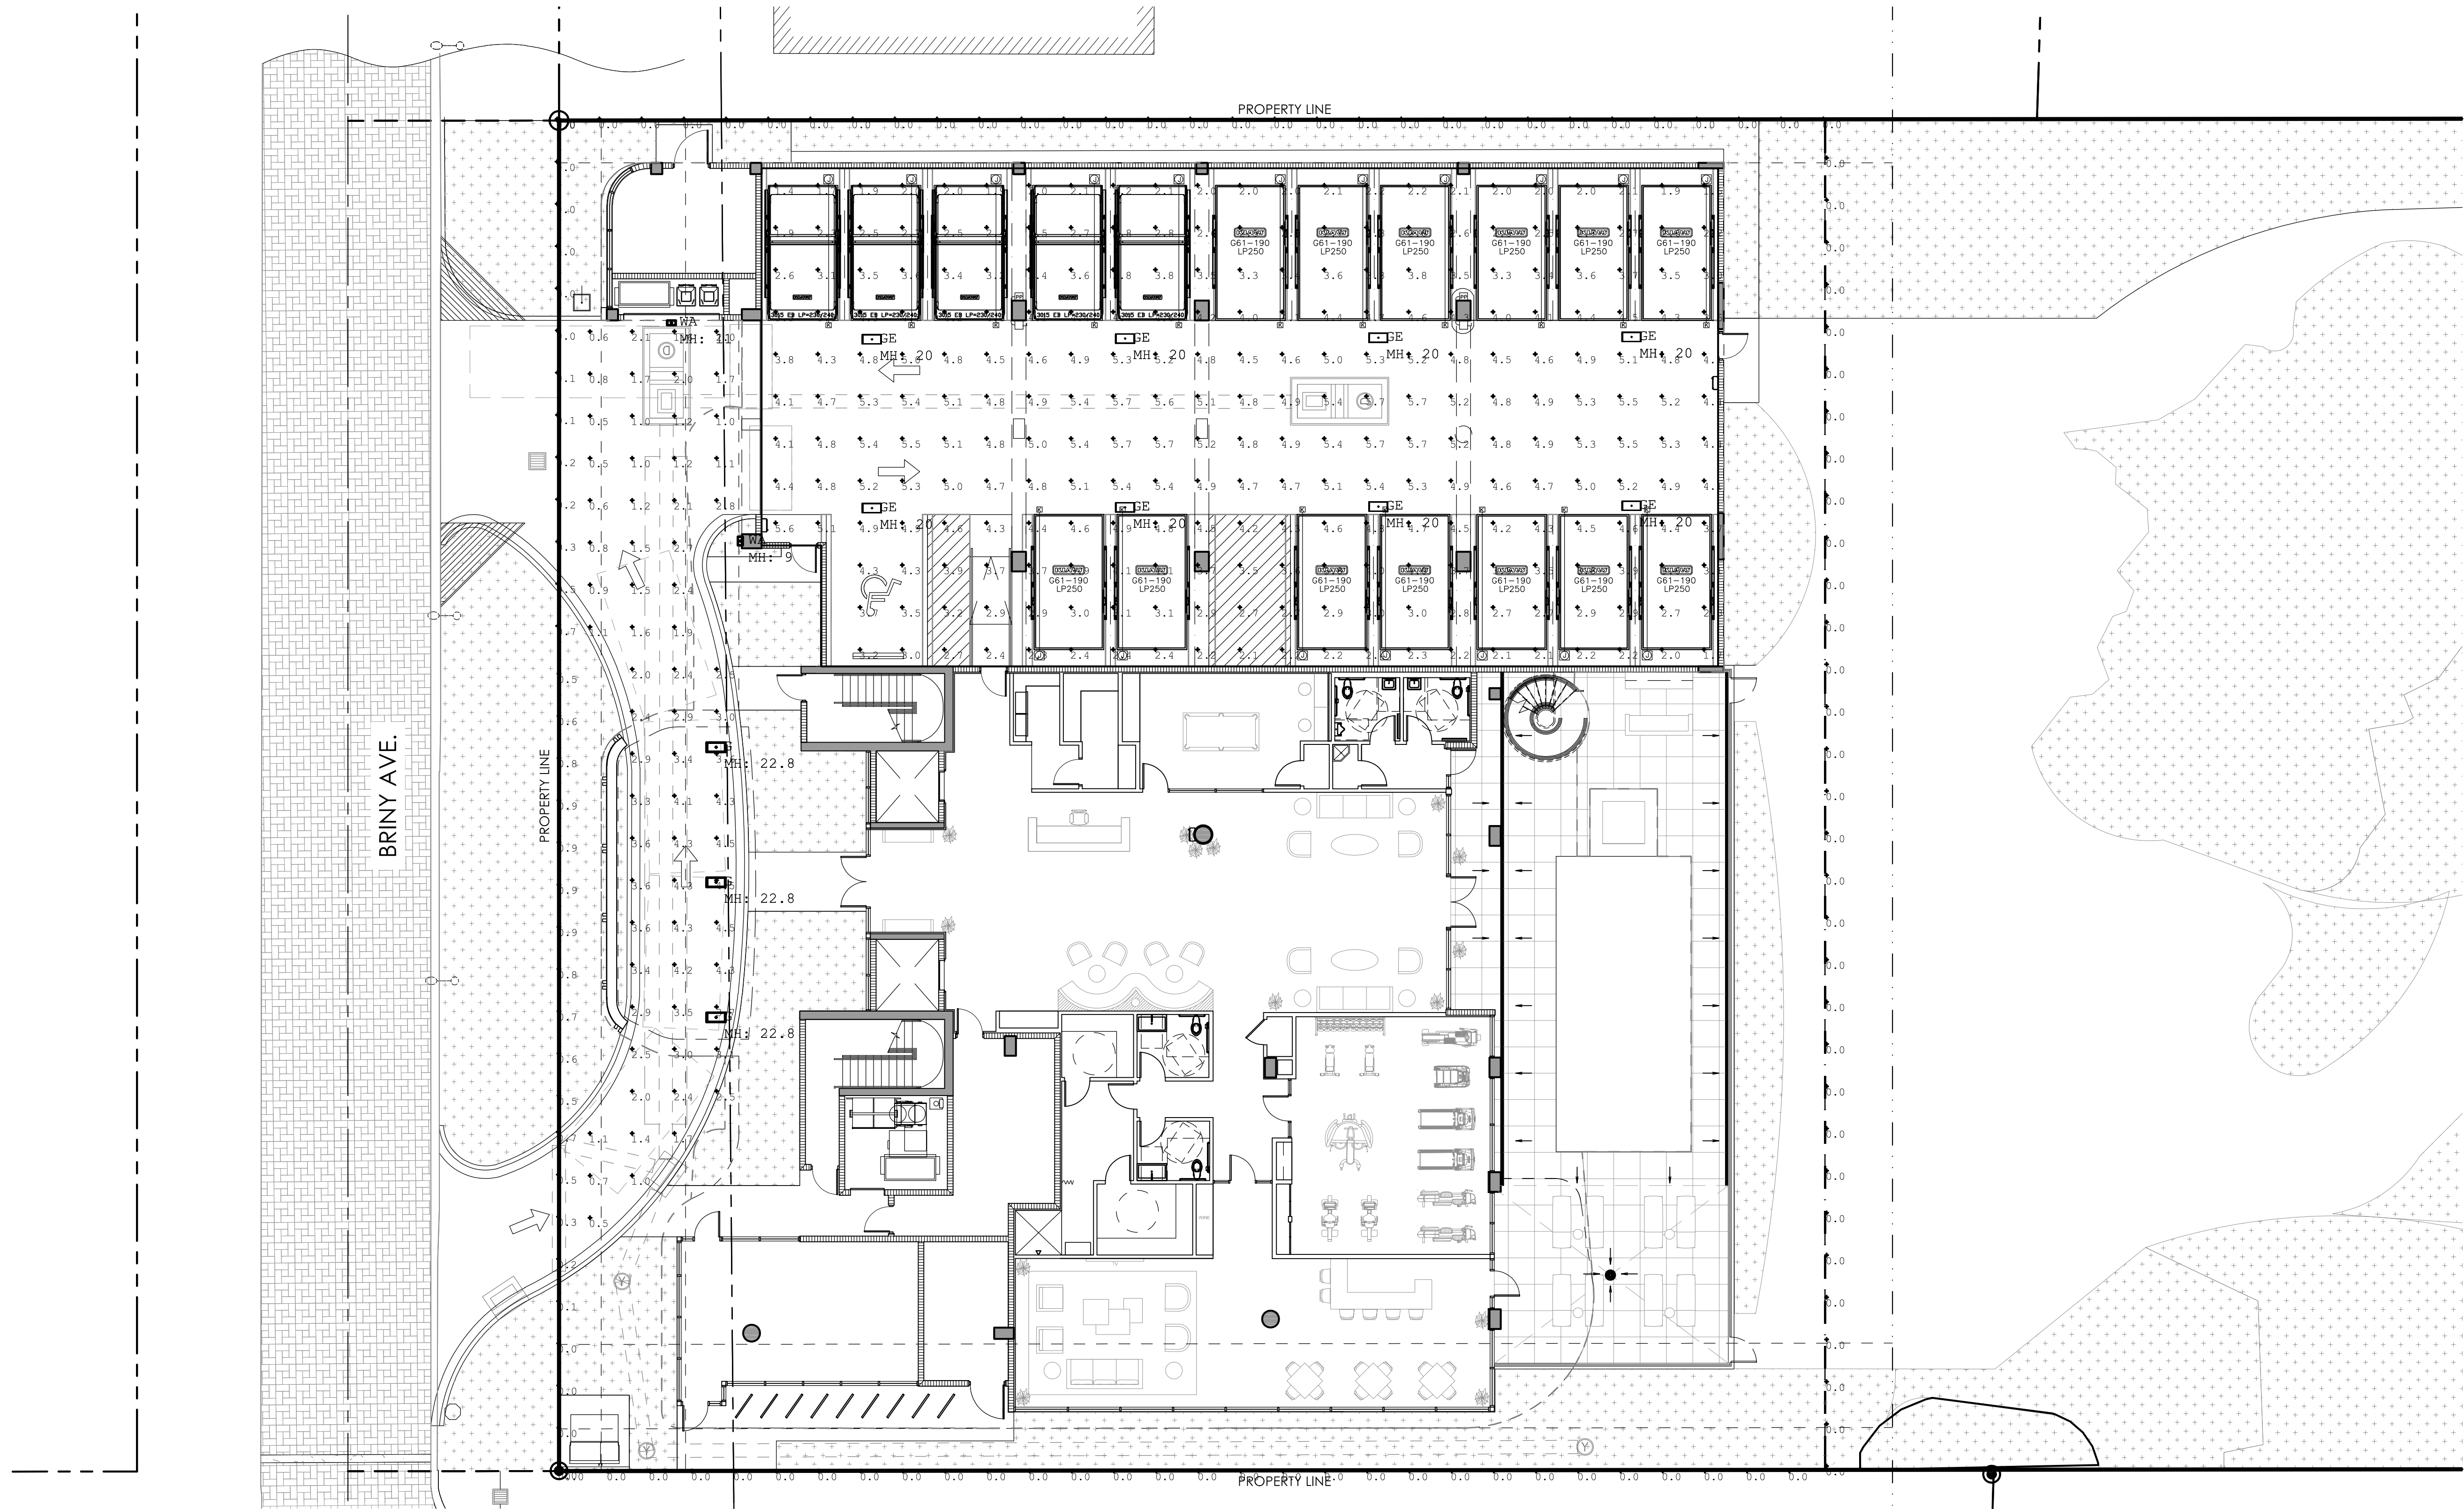


Luminaire Schedule								
Symbol	Qty	Label	Arrangement	Description	LLF	Luminaire Lumens	Luminaire Watts	Total Watts
	3	G	Single	Xtra Light VTH2-52-AMB-DIM-FCP-STD	0.900	3634	51.2	153.6
	8	GE	Single	Xtra Light VTH2-52-AMB-DIM-FCP-STD-EM	0.900	3634	51.2	409.6
	2	WA	Single	VNTW0253MNDIMAXXXBZWS	0.900	748	25.5	51

LIGHTING FIXTURE SCHEDULE									
TYPE	MANUFACTURER	CATALOG NUMBER	DESCRIPTION	LAMPS		VOLTS	MOUNTING	REMARKS	INPUT WATTS
				Qty	Type				
G	XTRALIGHT	VTH2-52-AMB-DIM-FCP-STD	TURTLE AMBER LED GARGE LUMINAIRE	1	LED INCLUDED	XX	XX		52W
GE	XTRALIGHT	VTH2-52-AMB-DIM-FCP-STD-EM	TURTLE AMBER LED GARGE LUMINAIRE WITH EM.	1	LED INCLUDED	XX	XX		52W
WA	XTRALIGHT	VNTW25ADIM3MN-XX	TURTLE AMBER LED WALL LUMINAIRE	1	LED INCLUDED	XX	WALL	LUMENS LESS THAN 900 (AT 748 LUMENS) PER CITY CODE	26W

GROUND FLOOR PHOTOMETRIC PLAN
SCALE: 3/32" = 1'-0"

AAC
PZ24 12000003
11/05/2024

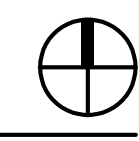

PRINTED ON: 09.26.24